


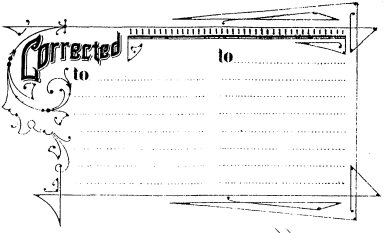

Port Dickinson  
 25



Population 45,000. Prev Winds West


**WATER FACILITIES**  
 Binghamton - Holly System of Water Works. Unlimited supply. 1 Holly Compound Condensing Pump + Cylinders. Capacity 6 Million Galls. per day. 2 Gaskill Compound Pumping Engines. Capacity 12 Million Galls. each per day. Average daily consumption 5 Million Galls. 25 Miles of Iron Water Pipes, 4" to 20" diam. 625 Double and Triple Hydrants. Fire Alarm Telegraph connects with pumping station.  
 Lestershire - Stand Pipe. Capacity 265,000 Galls. Elevation gives a pressure of 40 lbs. per sq. inch, is supplied from wells by 600 Gall. force pump. 5 Miles of Water Pipes 3" to 6" diam. 47 Hydrants. An additional supply of 200,000 Galls. is available from factories in the vicinity. Fire Pumps of adjacent factories connected with town mains which are connected with Binghamton City mains.

**FIRE DEPARTMENT**  
 Binghamton - 333 Men, 17 Fully Paid, 6 Partly Paid, 510 Volunteers. 17 Men on constant duty. 1 Third Class Sissy and 1 Third Class La France Steam Fire Engines. 1 Chemical Engine. 3 Hook & Ladder Trucks. 7 Hose Carts. 2 Supply Wagons. All are drawn by horses. 18 Horses always ready for service. 7200 Ft. of Cotton; Rubber lined, Hose. Gamewell Fire Alarm System. 42 Boxes.  
 Lestershire - 80 Men, Volunteer. 1 La France Third Class Steam Fire Engine. 1 Chemical Engine drawn by horses. 2 Independent Hose Carts. 1 Hook & Ladder Truck. 1500 Ft. of Cotton - Rubber Lined Hose. 2000 Ft. of Hose in reserve. Gamewell Fire Alarm System 5 Boxes.

**KEY**

	Fire Proof Building
	Iron Building
	Brick Building with Metal Cornice
	Brick Building with Frame
	Brick Building with Side
	Brick Building with Stone Front
	Special with Frame Side
	Frame Building, not a special
	Iron Clad
	Special with openings
	Wall 12" no opening through it
	Fire Wall 6" inches above roof
	Opening in Division Wall with Iron Door
	Windows with Iron Shutters
	Window opening in 1st Story
	Stable
	Brick Chimney
	Iron Chimney
	Vertical Steam Boiler
	Horizontal Steam Boiler
	Hydrants
	Fire Alarm Box

37

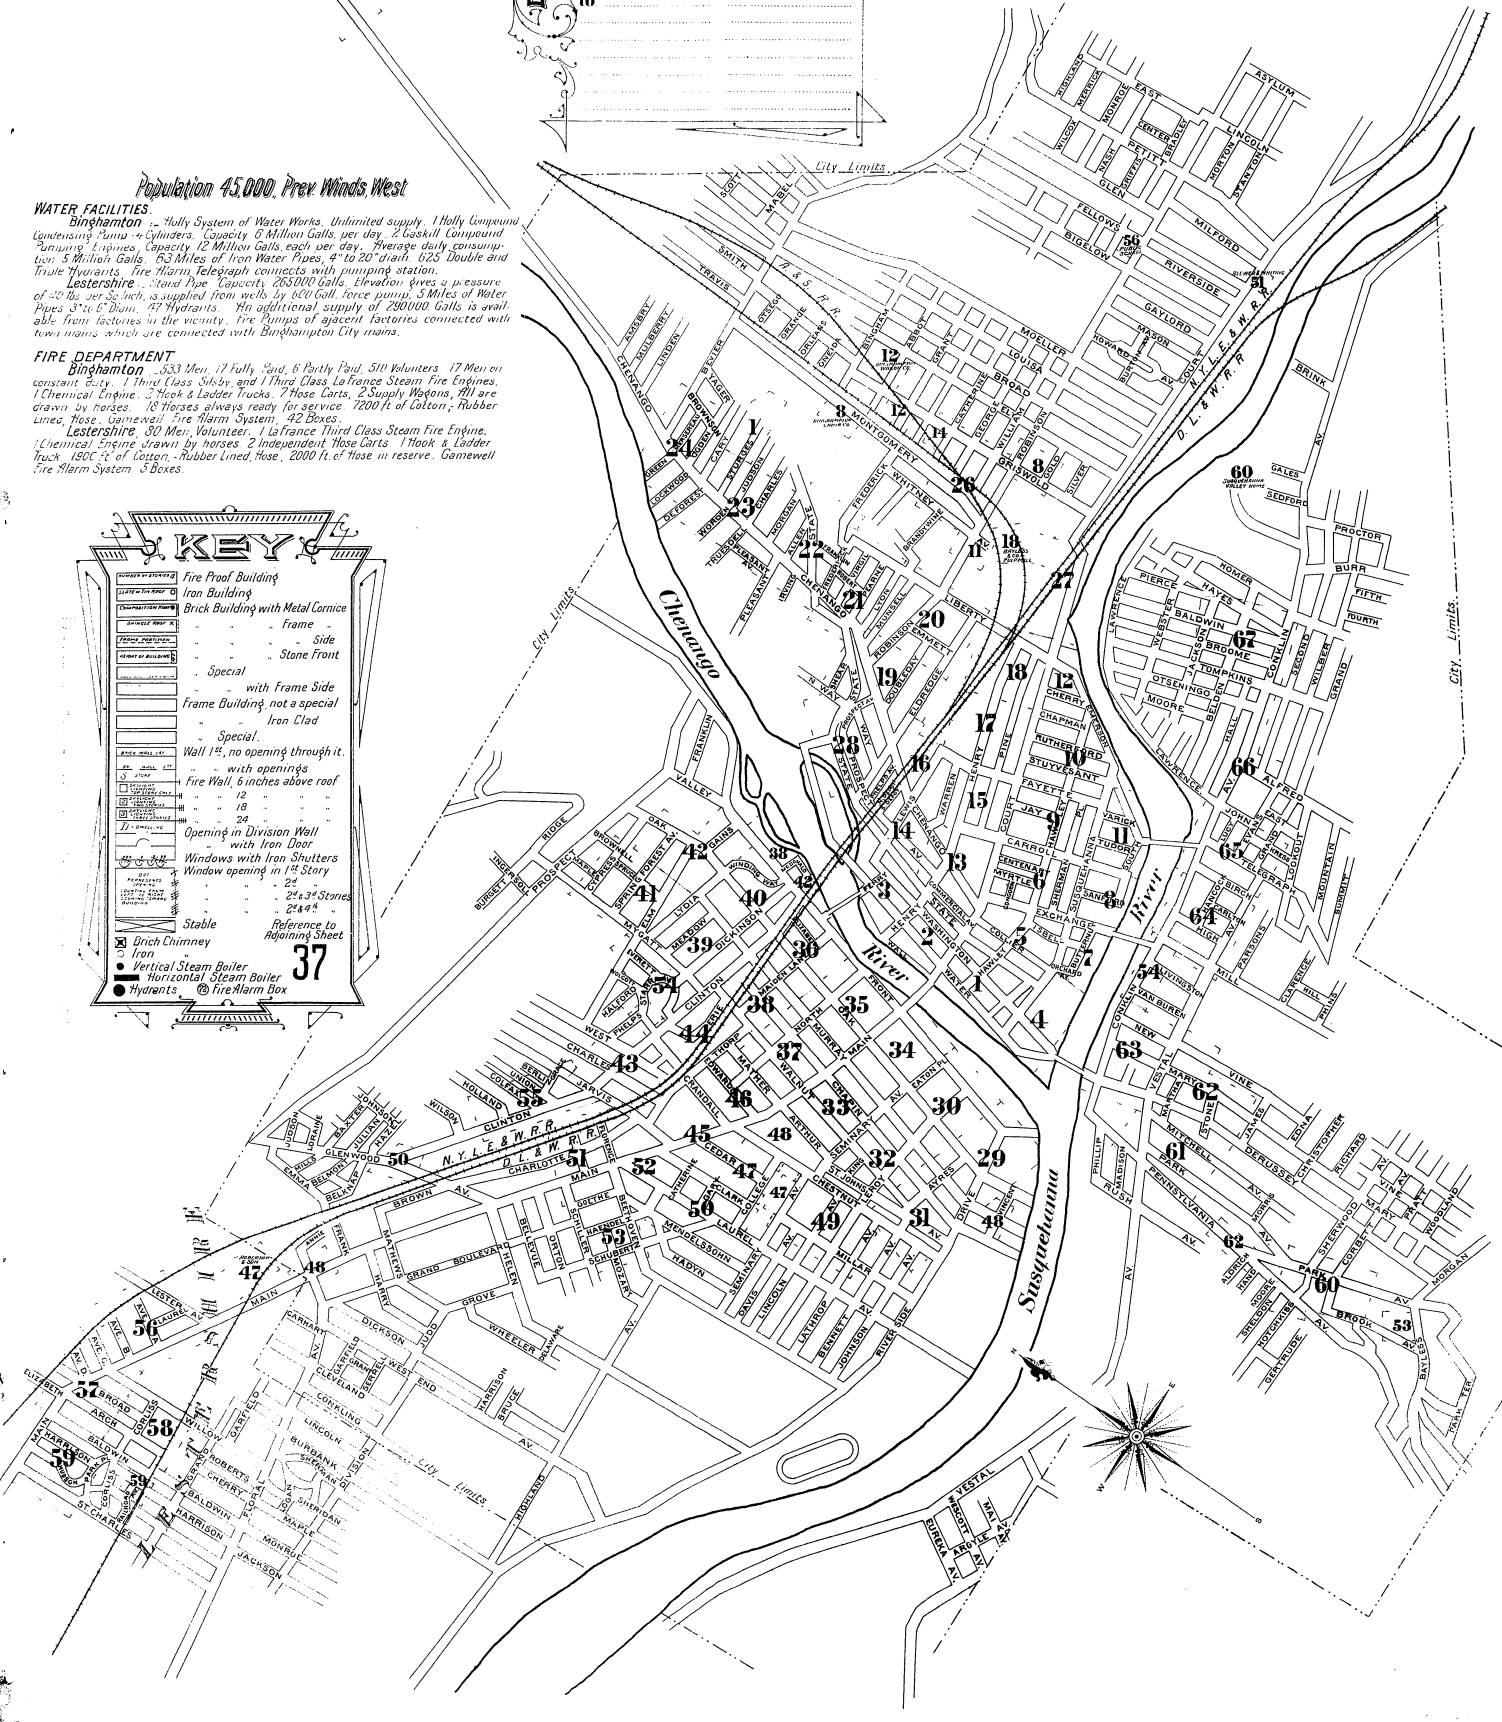




WALL ST.

COURT

River

 Chenango



WATER

HAWLEY

 
WASHINGTON

HAWLEY

STUART


HARRISON AV.

STATE



Chenango River


BUNDY MAN'S CO.  
NO WATCHMAN - POWER AND HEAT FROM BENNETT MAN'S CO.  
LIGHTS GAS - GRANNELL FLYING SPRINKLERS TINDO OUT  
OFF WATER (GAS) - FIRE TILLS AND CHEMICAL EXTINGUISHERS

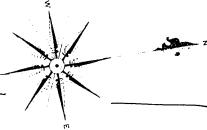

COURT

5


 
COLLIER ST.



13

Chenango

 River


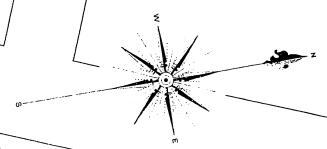


COLLIER ST.

12/10

3

14

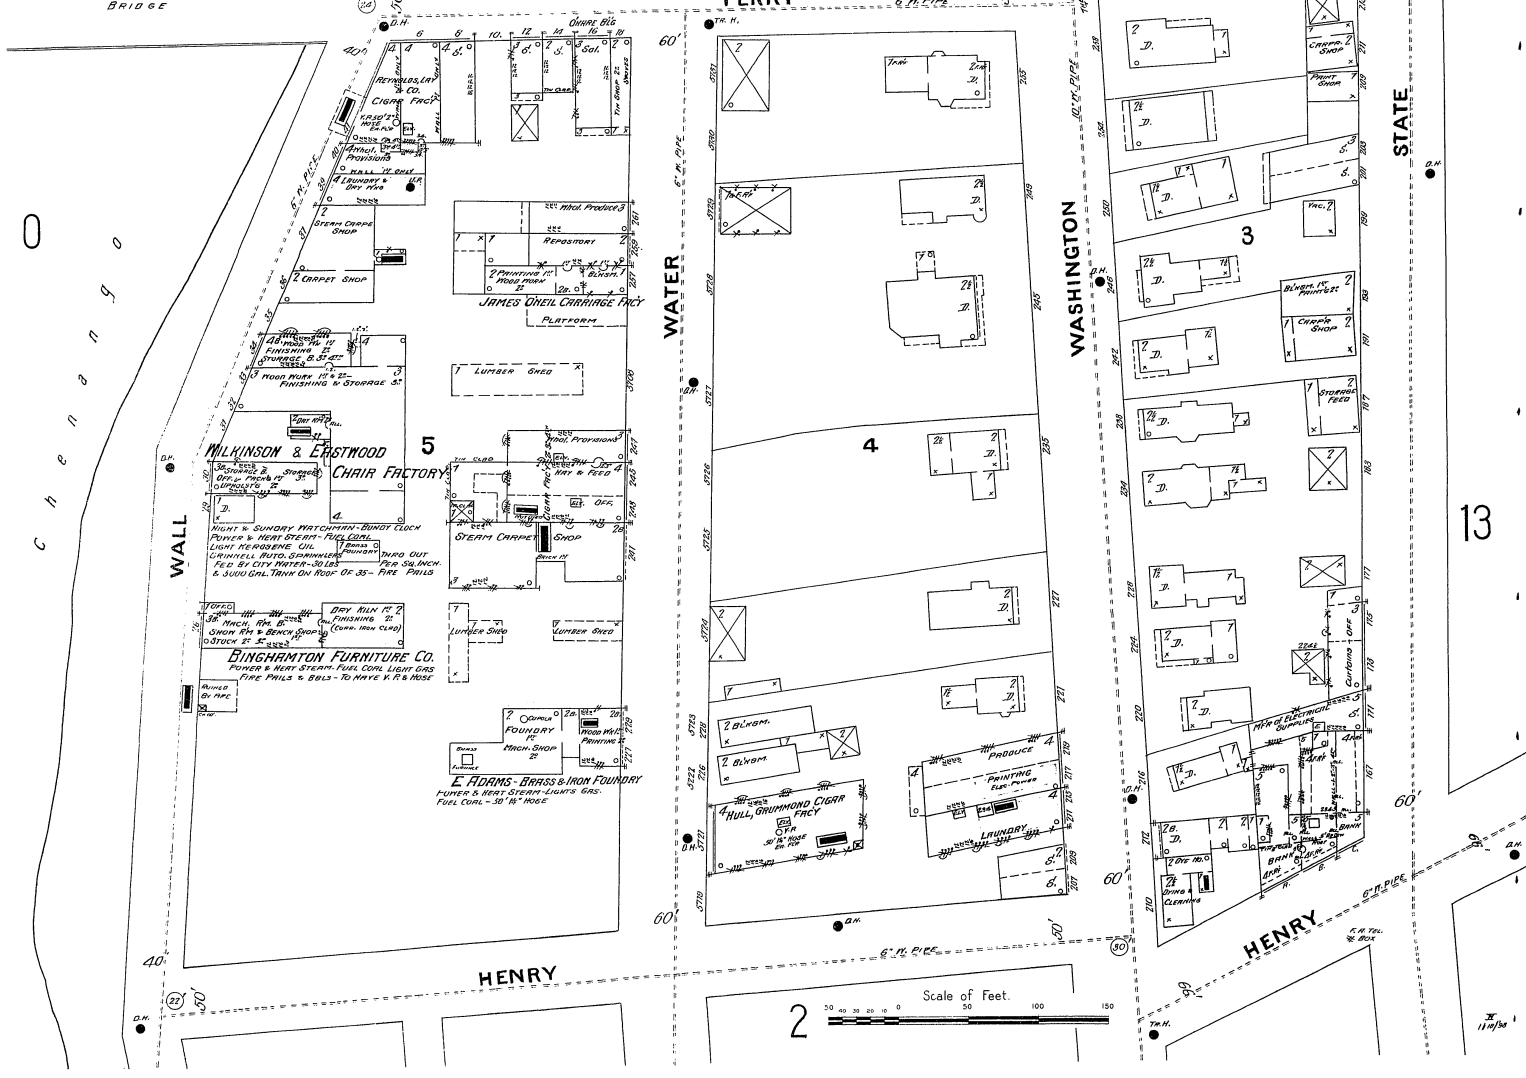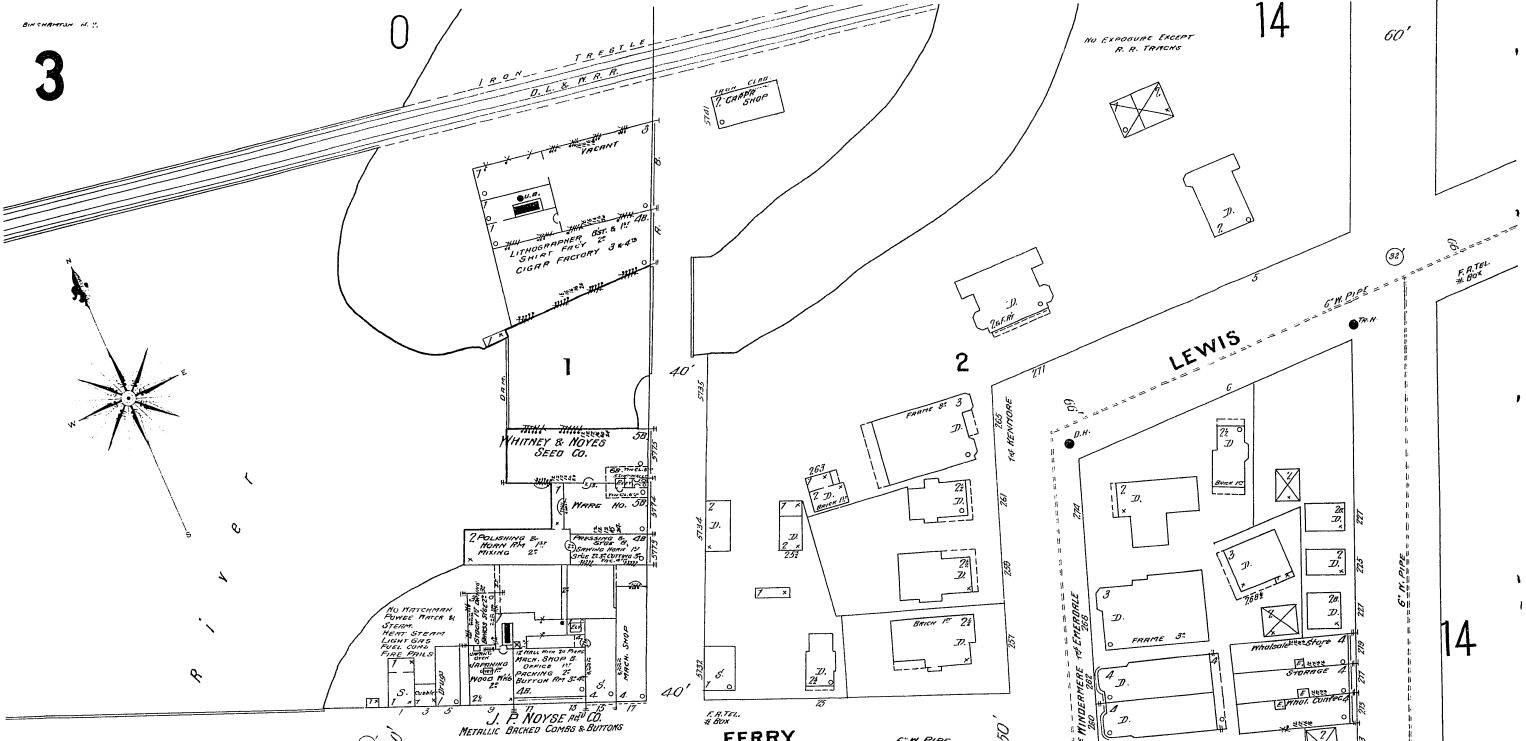

14

13

2


 





Scale of Feet.

11/1/30


O c h e n a n g o R i v e r

Surveyor H.V.

4

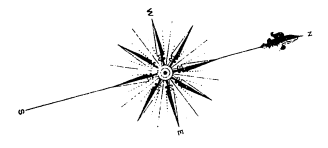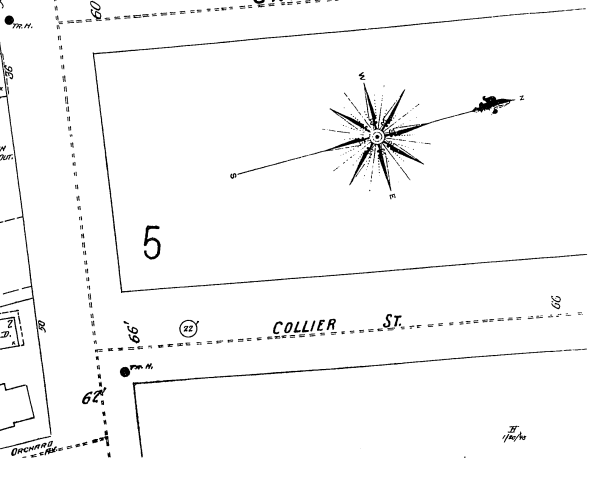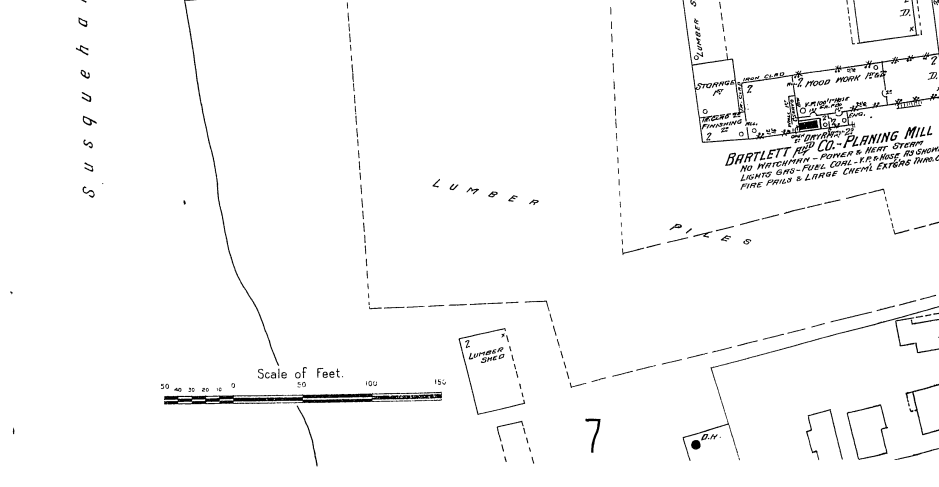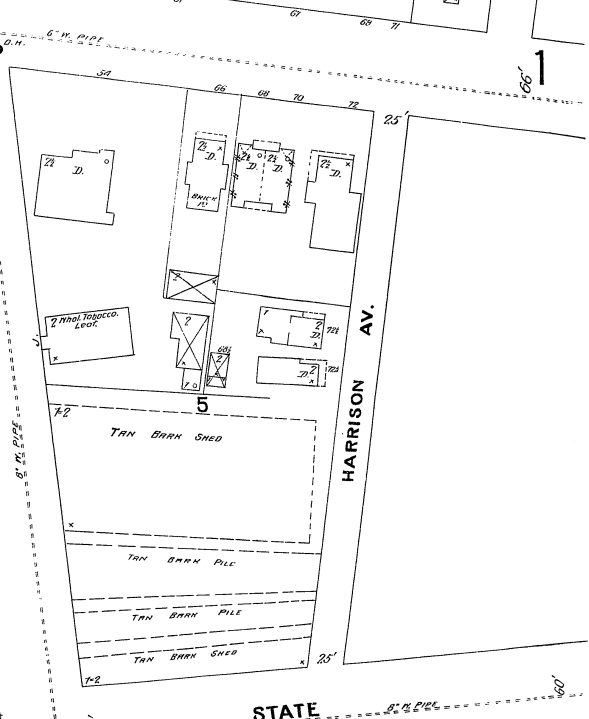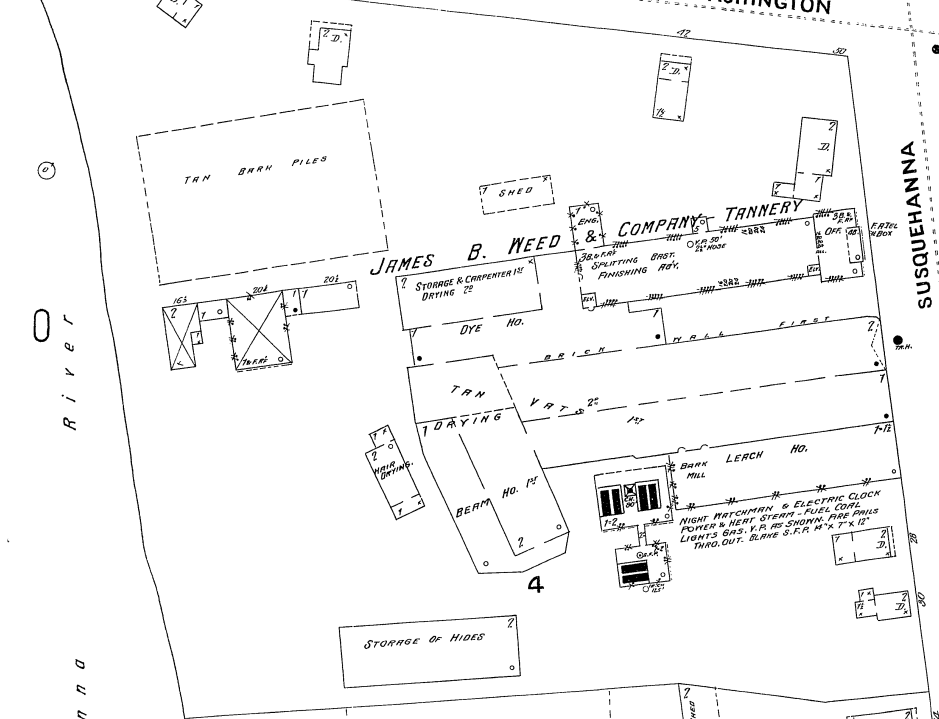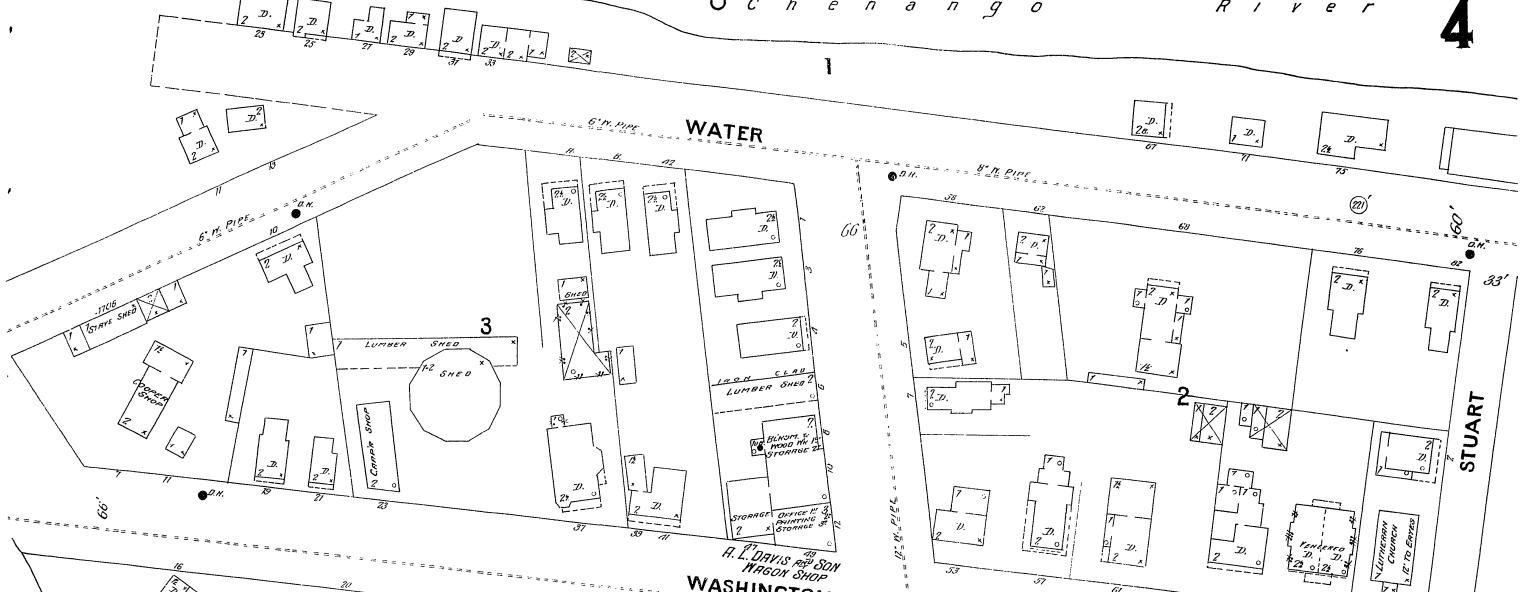

1/10/74

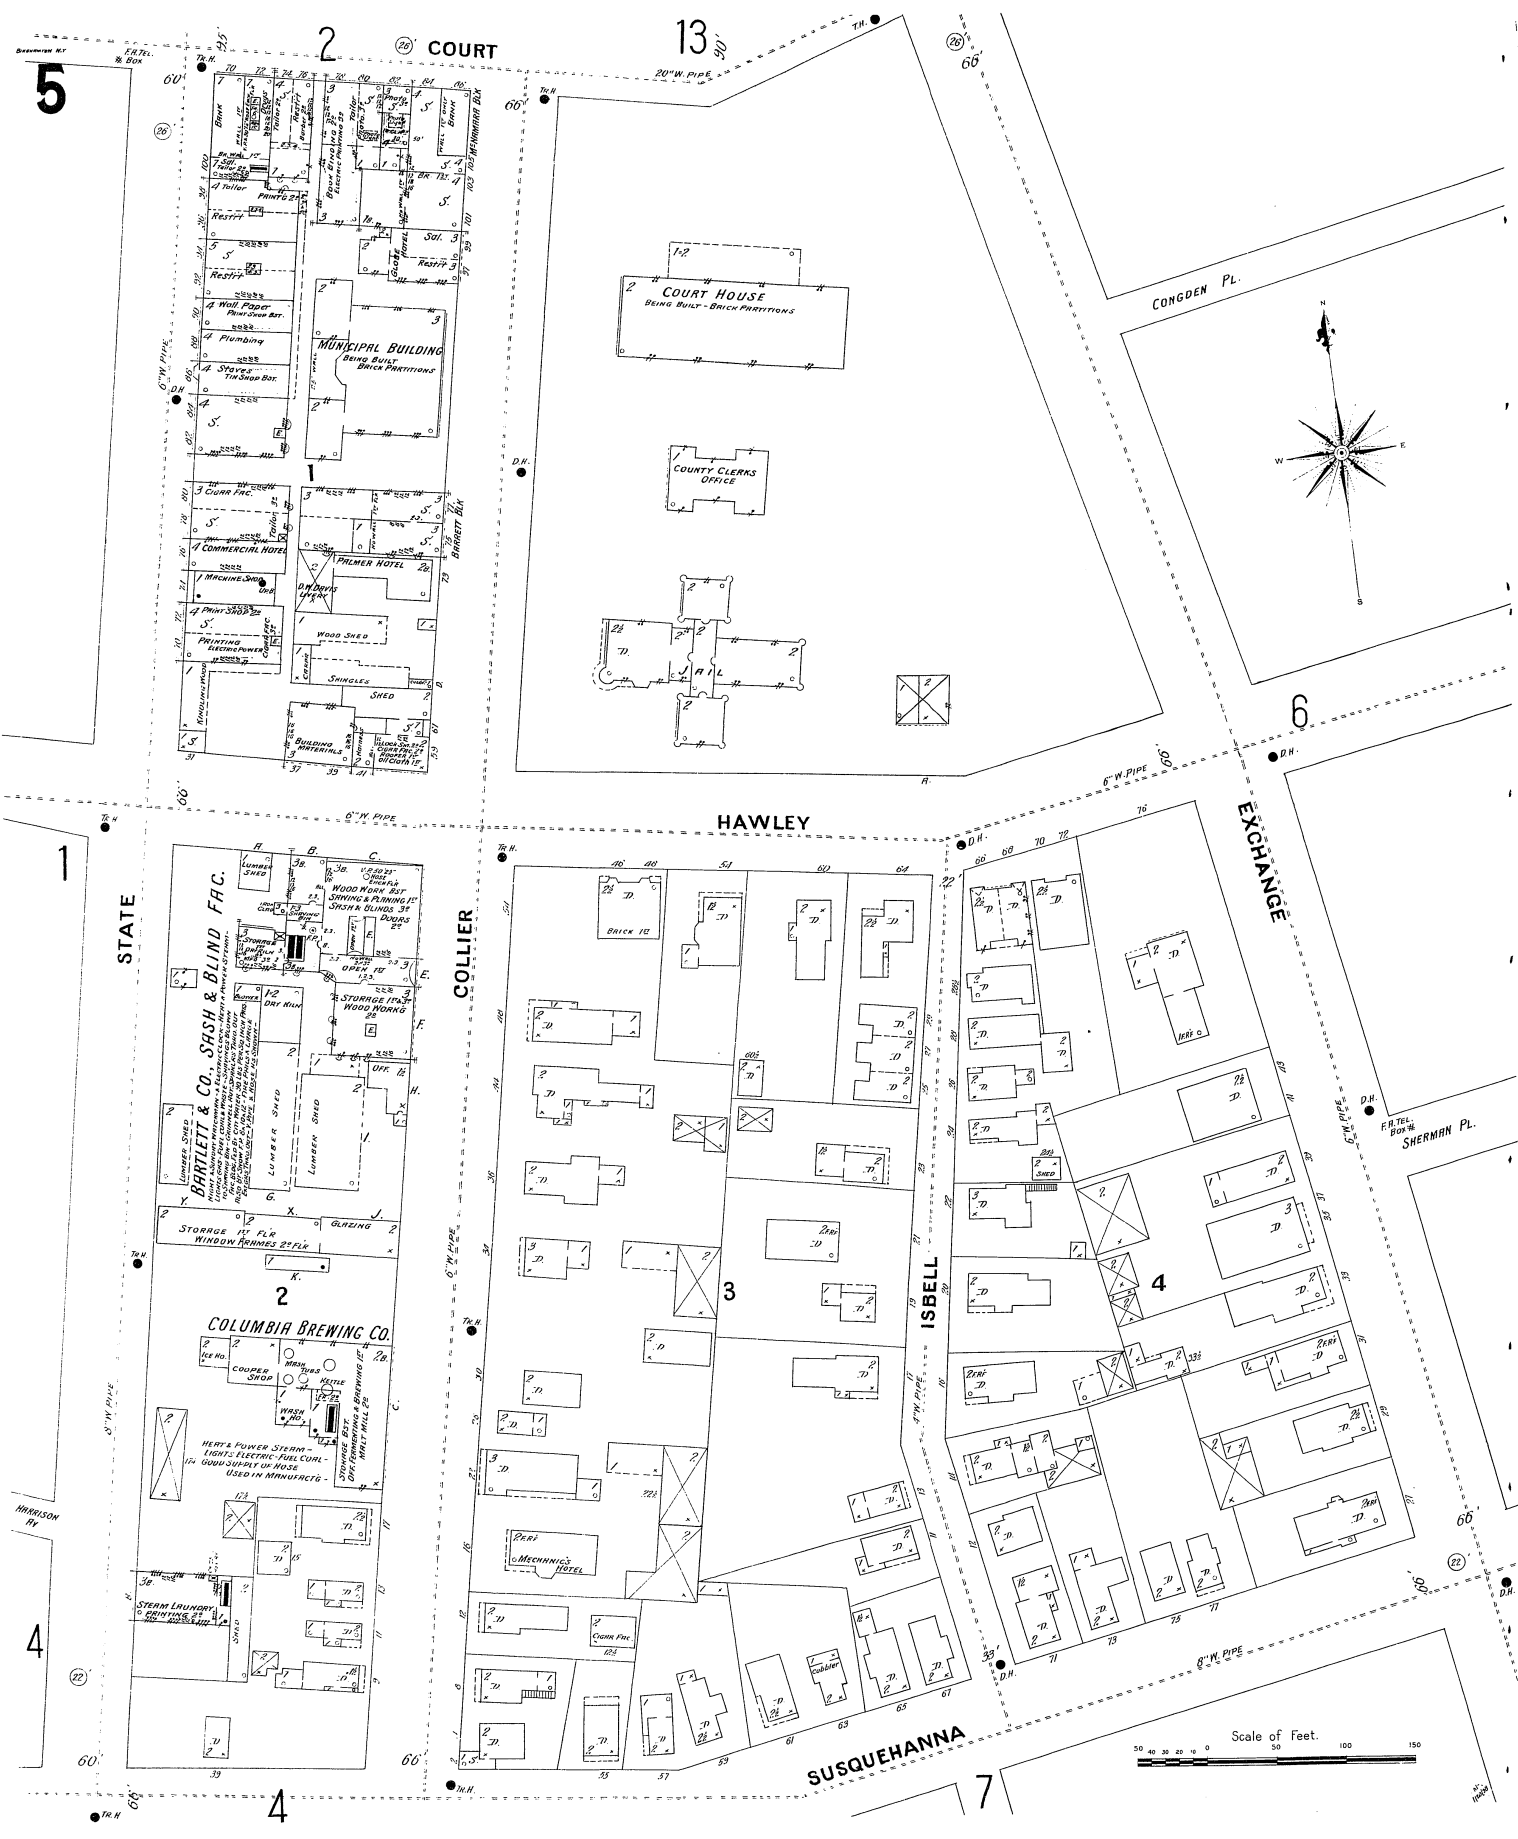

2 COURT

13

COURT HOUSE  
BEING BUILT - BRICK PARTITIONS

COUNTY CLERKS OFFICE

MUNICIPAL BUILDING  
BEING BUILT - BRICK PARTITIONS

HAWLEY

STATE

BARTLETT & CO., SASH & BLIND FAC.  
WOOD WORK SHED  
SPRING & REMOVAL SHED  
STORAGE 1ST FLR WINDOW FRAMES 2ND FLR  
OFF. 12  
COLUMBIA BREWING CO.  
MECH. POWER STERN LIGHTS - ELECTRIC - FULL COAL - STEAM SUPPLY ON ROOF - USED IN MANUFACTG.  
STEAM LAUNDRY

COLLIER

3

EXCHANGE

ISBELL


4

SUSQUEHANNA

Scale of Feet. 0 50 100 150

13 COURT


6

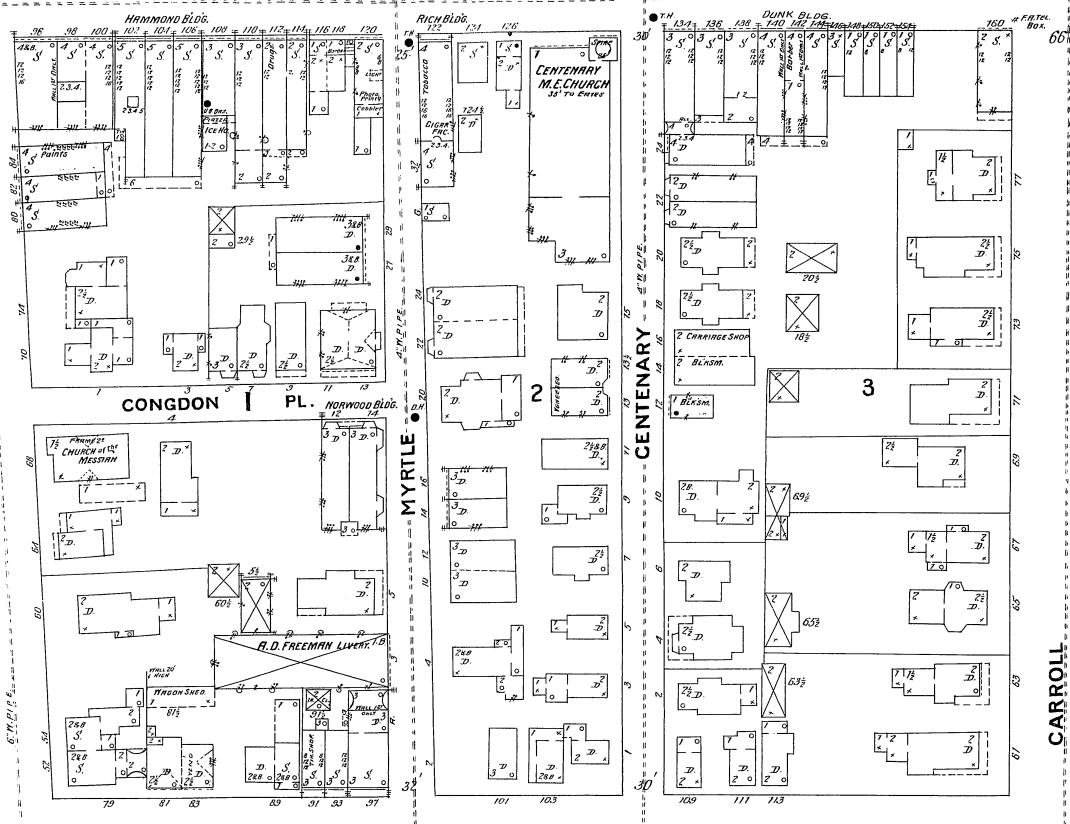

5


9

HAWLEY

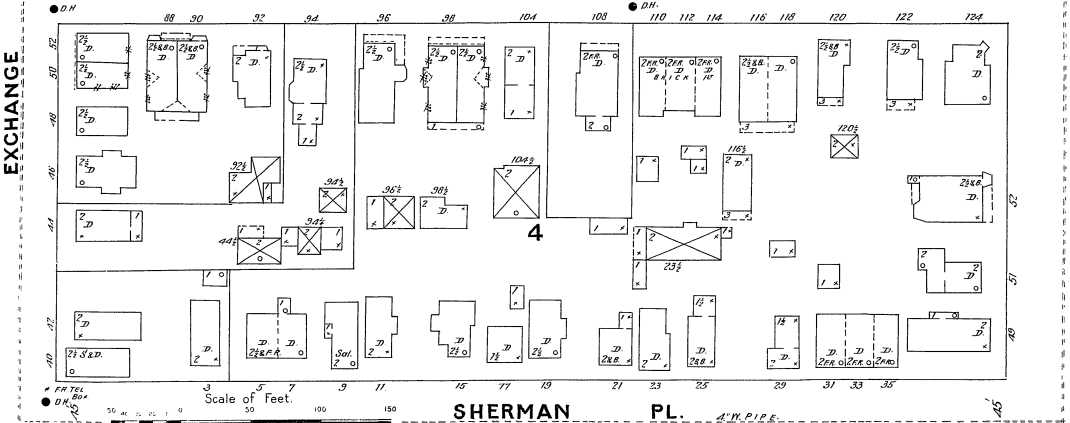


EXCHANGE


SHERMAN PL.

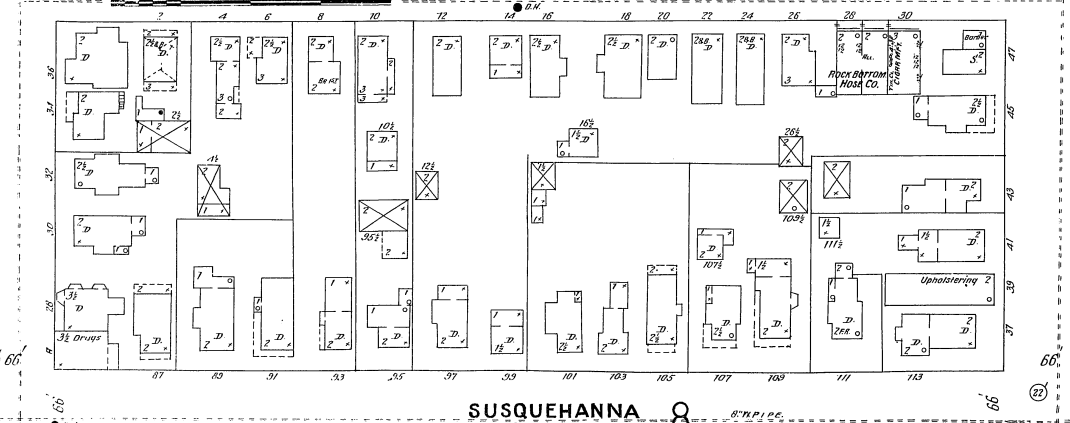

SUSQUEHANNA

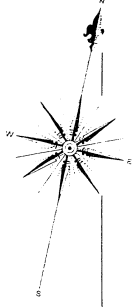

Scale of Feet. 0 50 100 150

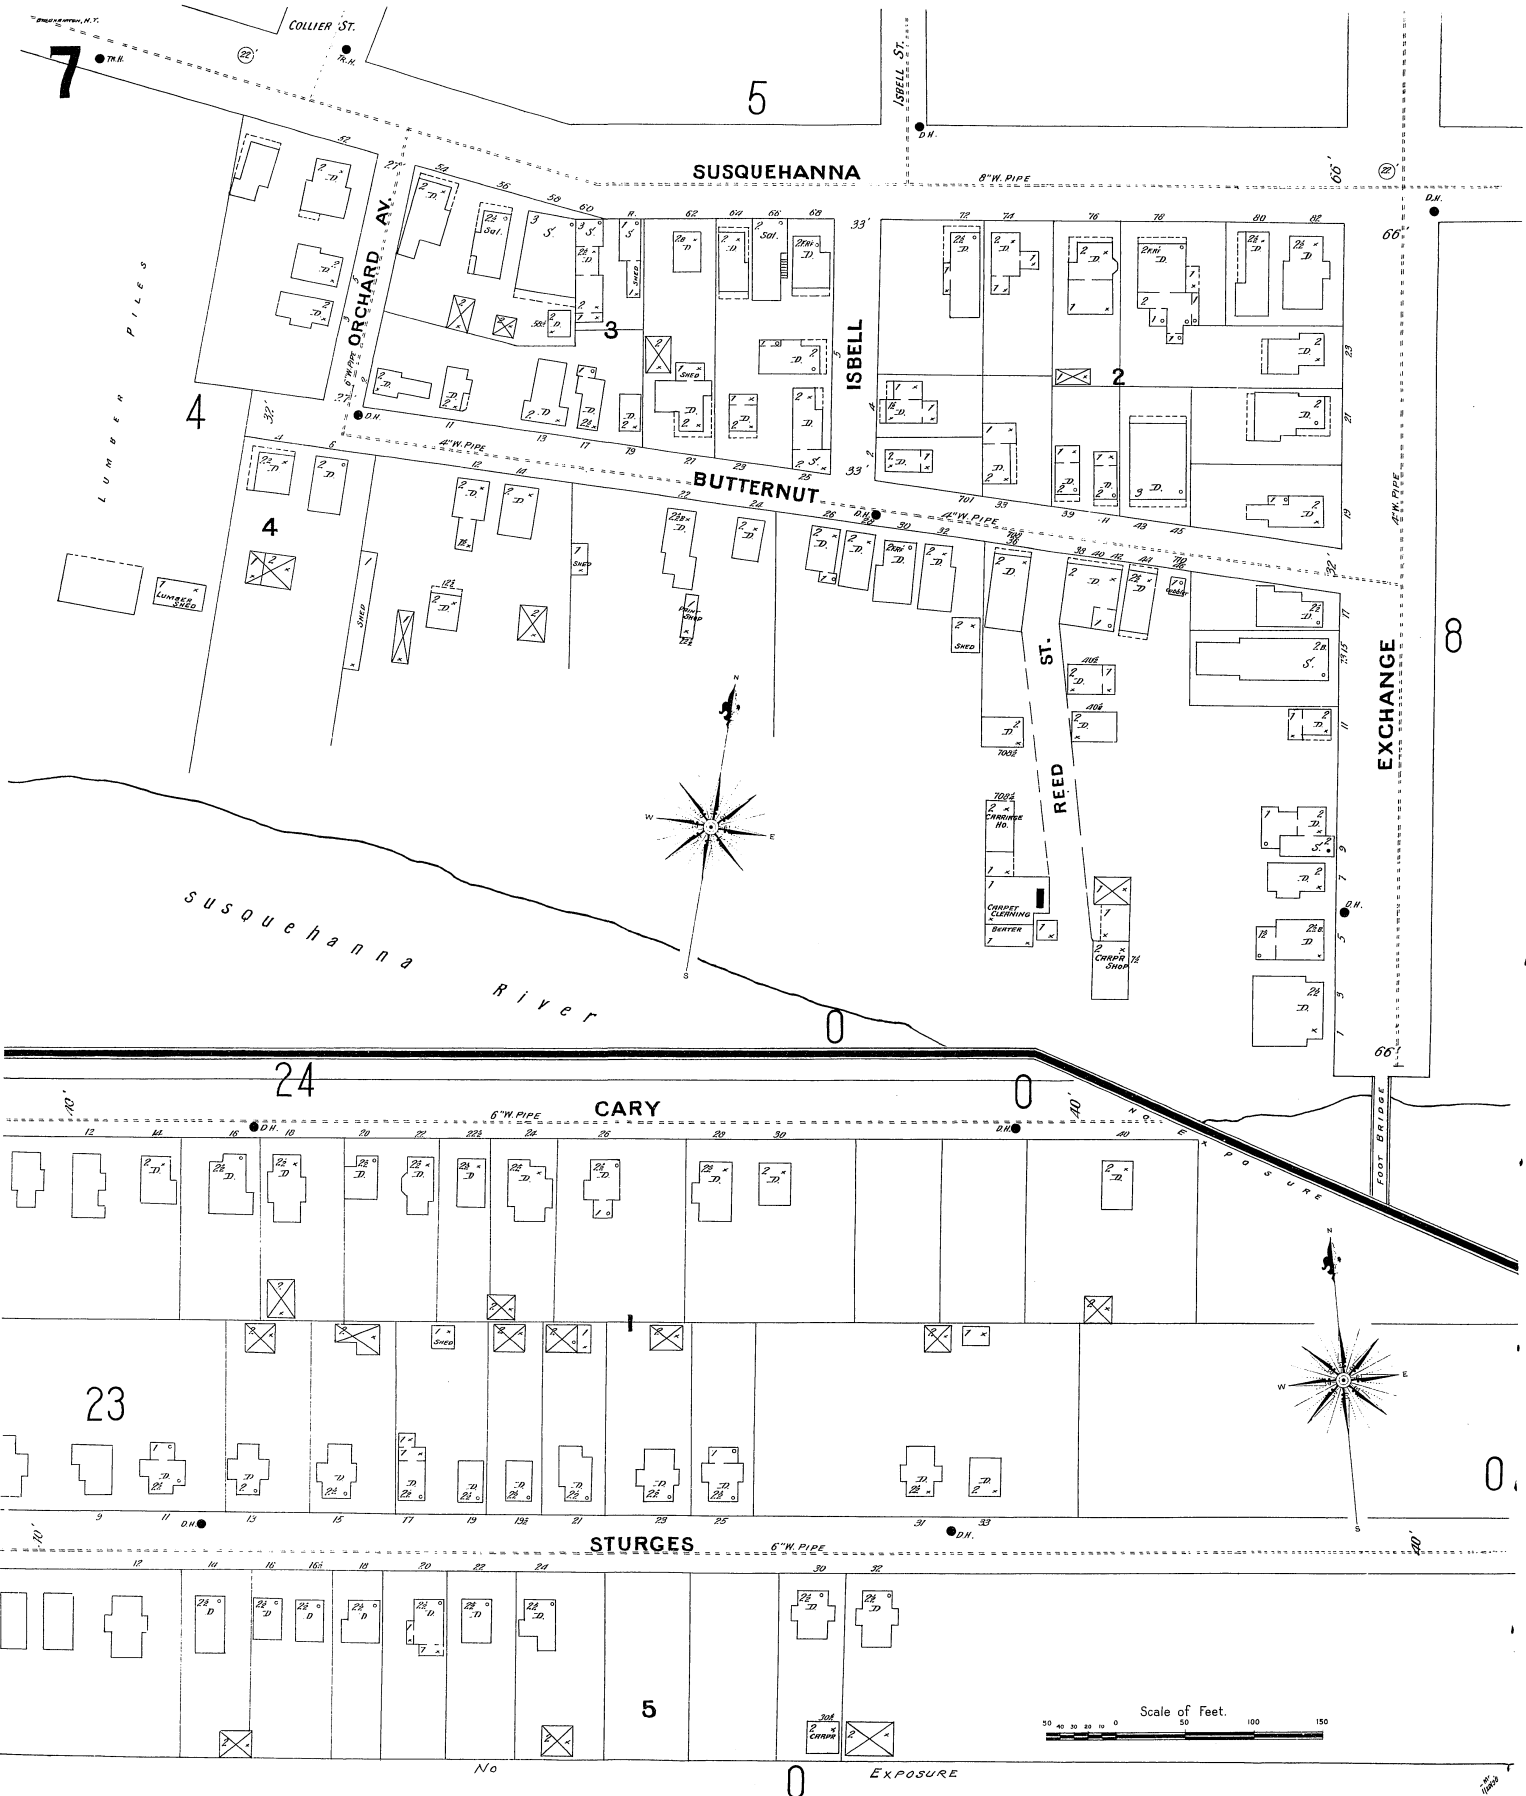

7

5


SUSQUEHANNA

4

3

2

4

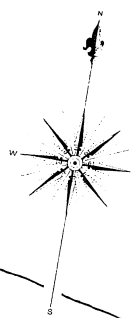


Susquehanna River

0

24


CARY

23

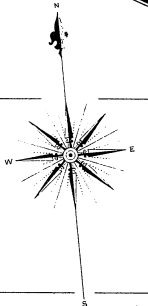

STURGES

 5



EXPOSURE

8

0

0


0



15 COURT

9


FRYER  
ROW

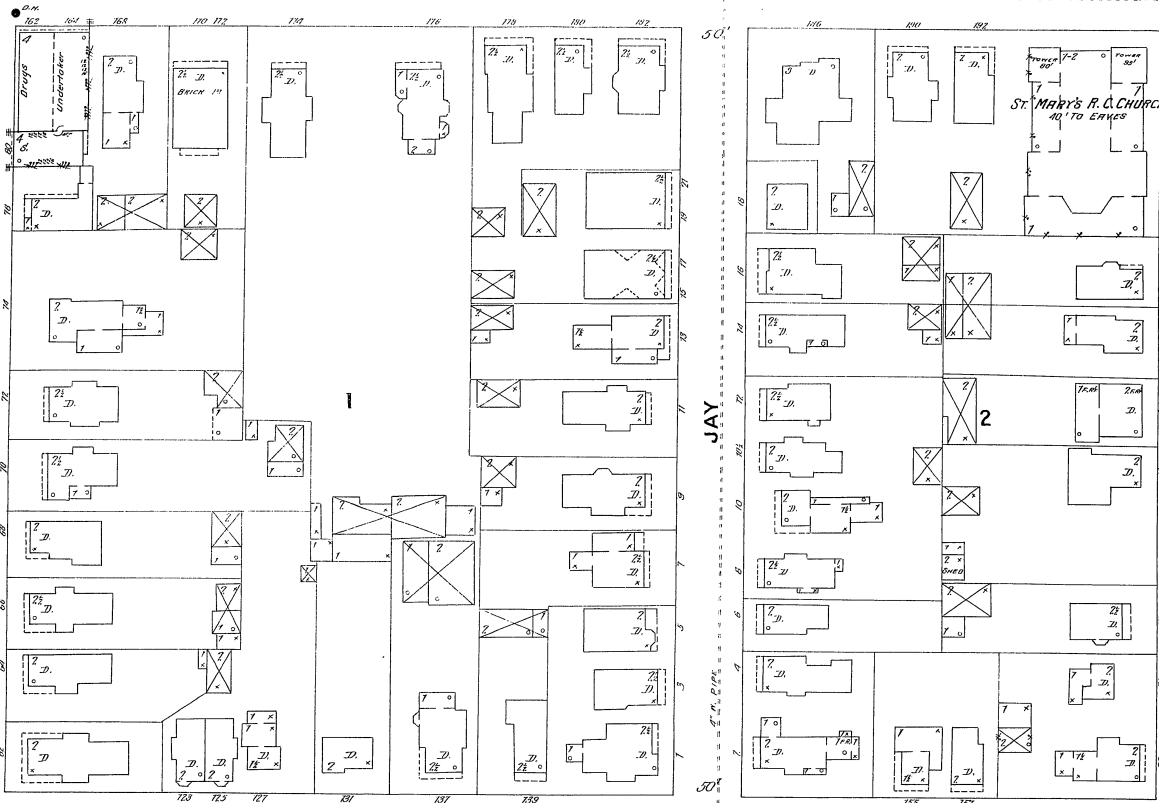


6

HAWLEY


CARROLL

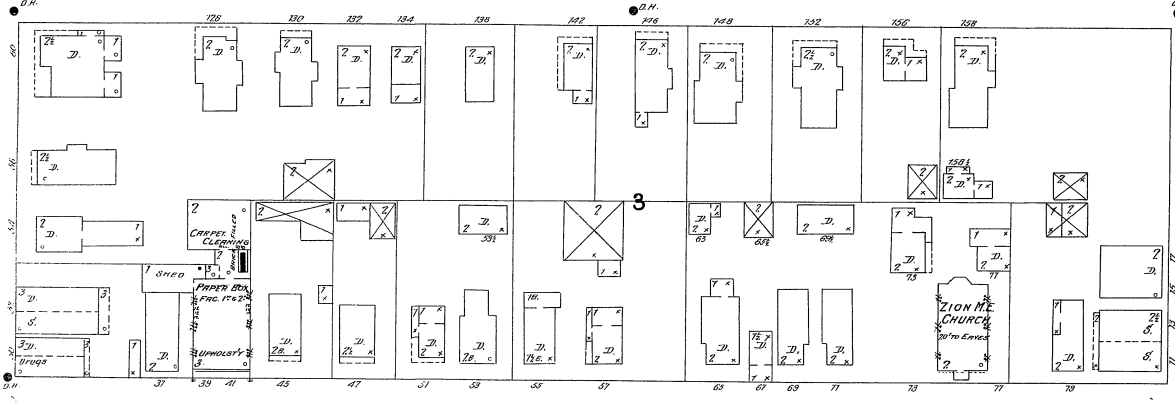

SHERMAN PL.

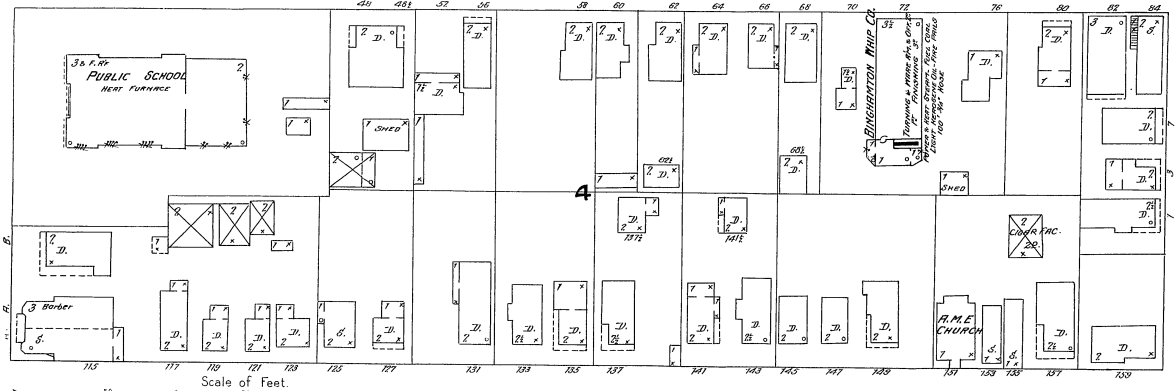

SUSQUEHANNA 11

 

22

22

1/19



Successor  
STUTVESANT  
ST.

11


10

FAYETTE ST.

9

66


60

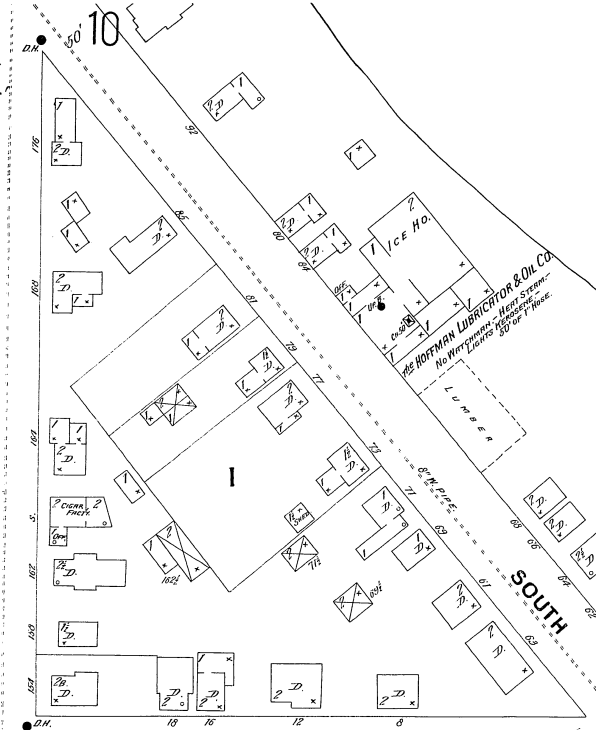

VARICK

SOUTH



SUSQUEHANNA

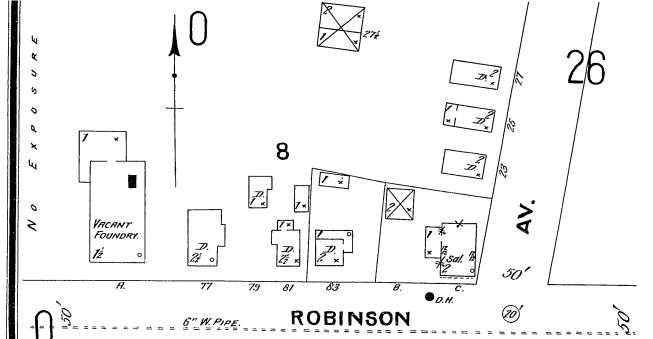

ROBINSON


WHITNEY

26

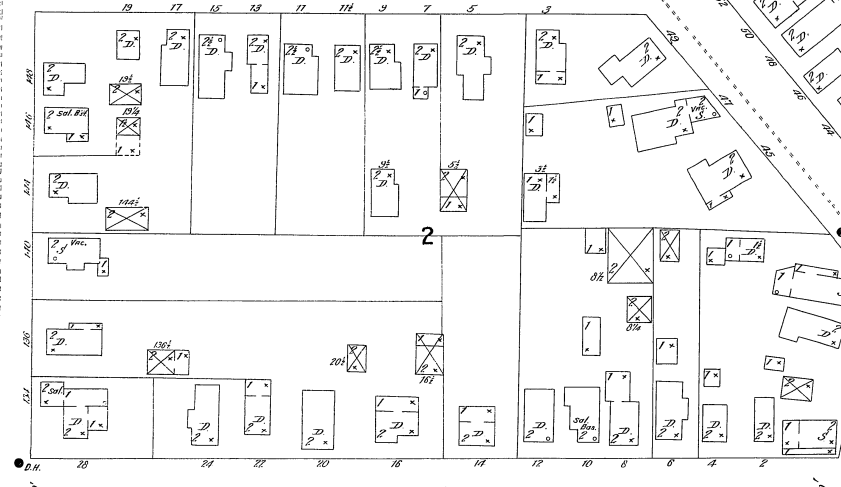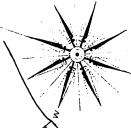


TUDOR

SOUTH

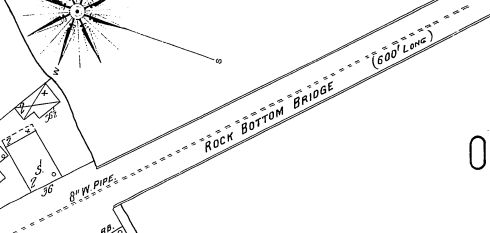

RIVER

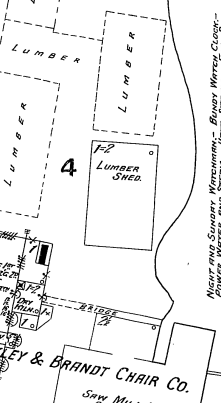

Scale of Feet.

POWER WATER - NEAR SHOES -  
CIVIL EXTENSION ON 17' P.K.  
- FIRE ALARMS - FIRE OUT -  
- 4' 6" SPACES - 4' 6" SPACES -  
- 4' 6" - ONE RUNNER -

0-71/8





18

12

27

10


03

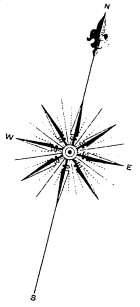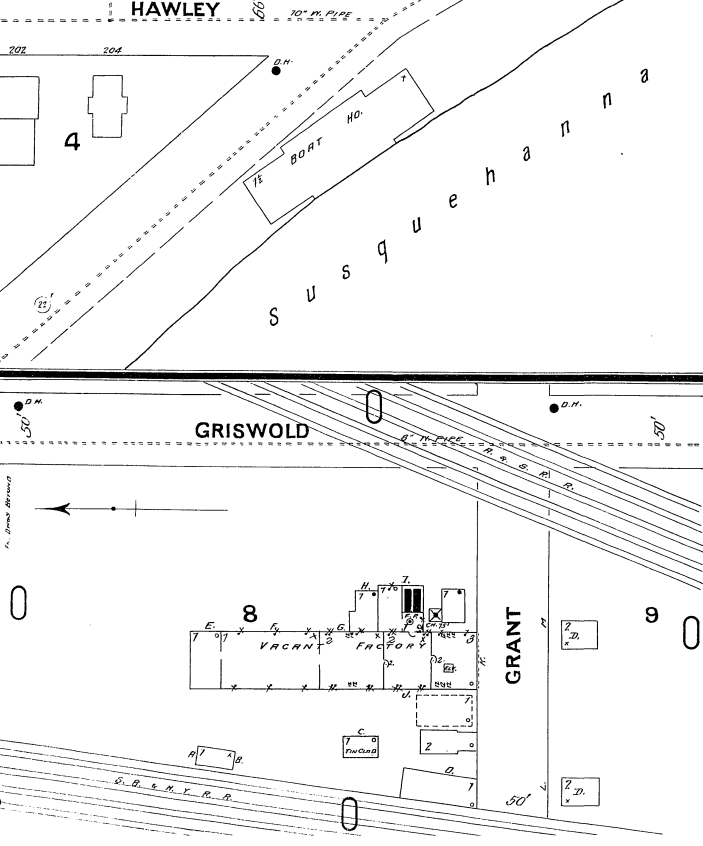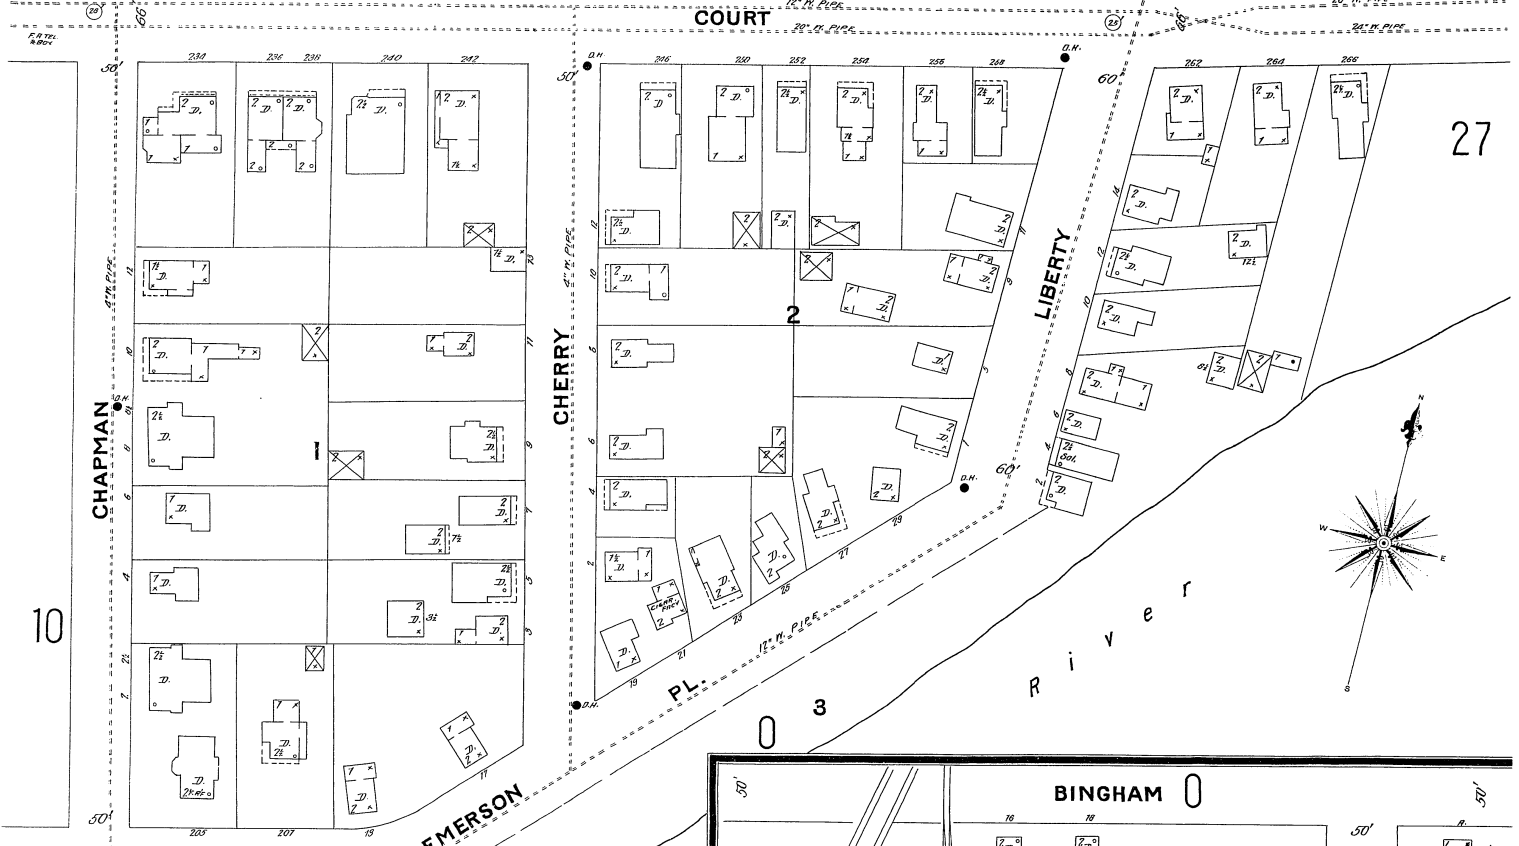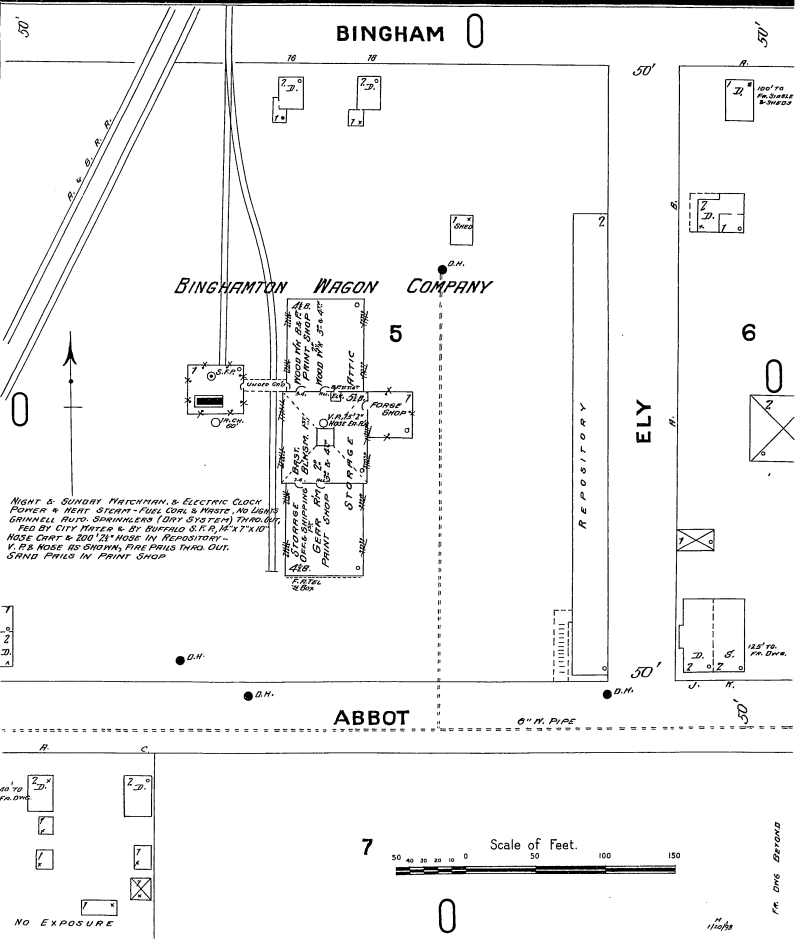

13

2

WASHINGTON ST.

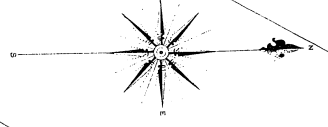

5

COMMERCIAL

AV.

STATE

3

STONE OPERA HO.

CHENANGO

PROSPECT

PROSPECT

HENRY

COURT

PROTESTANT CHURCH

4

4

MYRTLE ST.

SMITH, KINNE & CO. OVERALL MFG 278.32

M. SIGNOR LIVERY

2

CENTENARY ST.

6

Bakery

 
FIRST BAPTIST CHURCH

CARROLL

15

WARREN

16





COURT

COMMERCIAL

STATE

AV.

CHENANGO

PROSPECT

WARREN

HENRY

CARROLL

Scale of Feet.

 

1





2


5

4



3

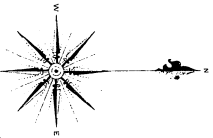

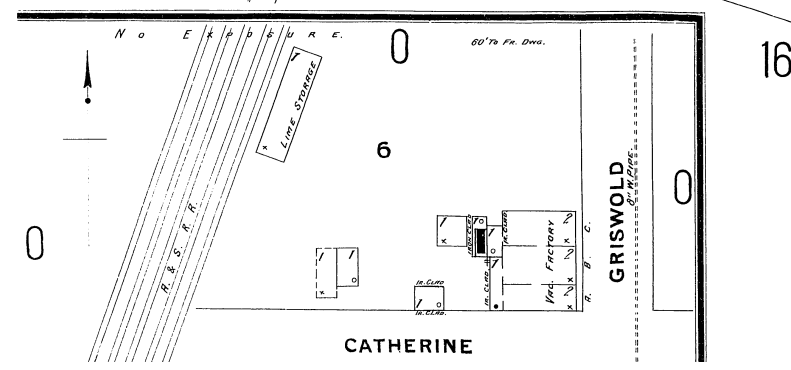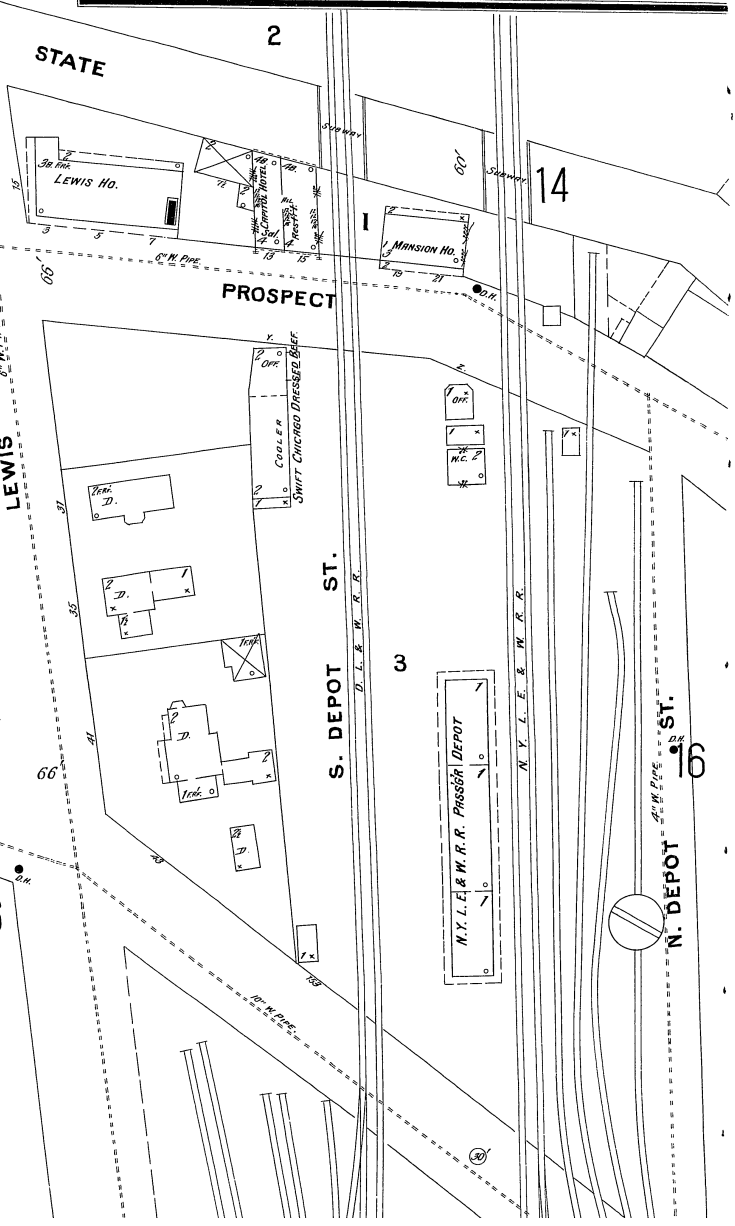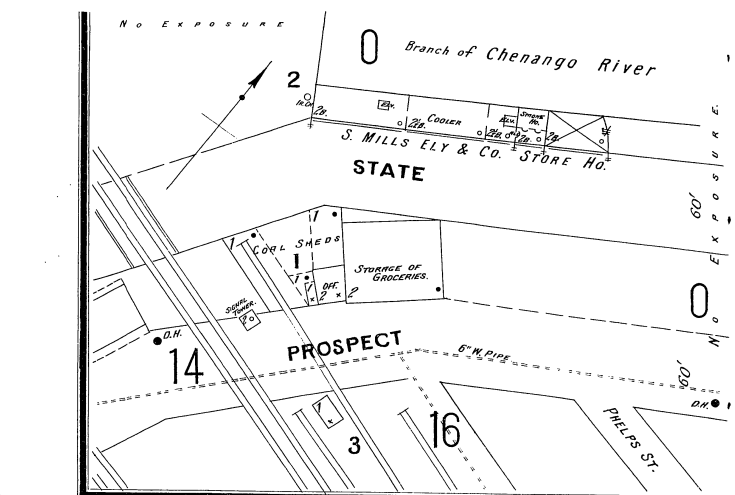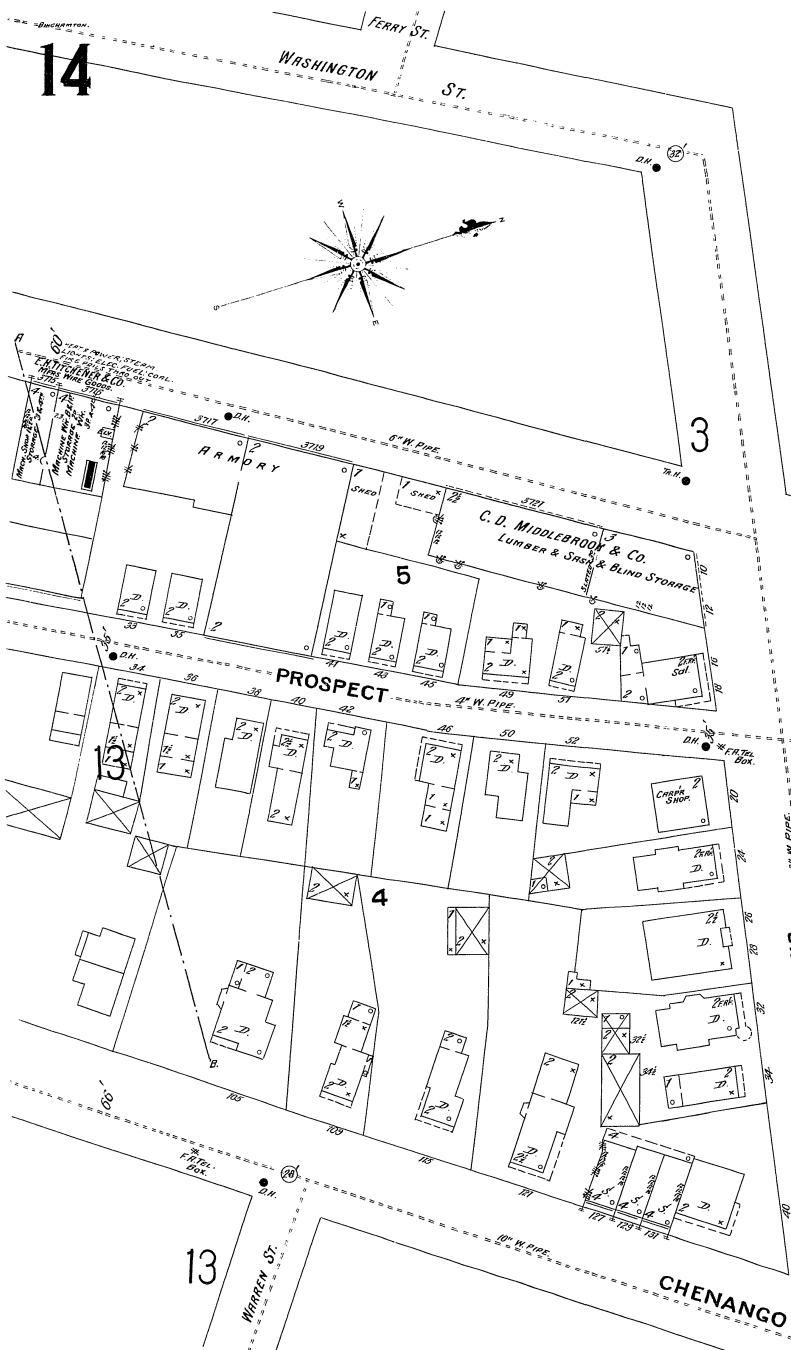

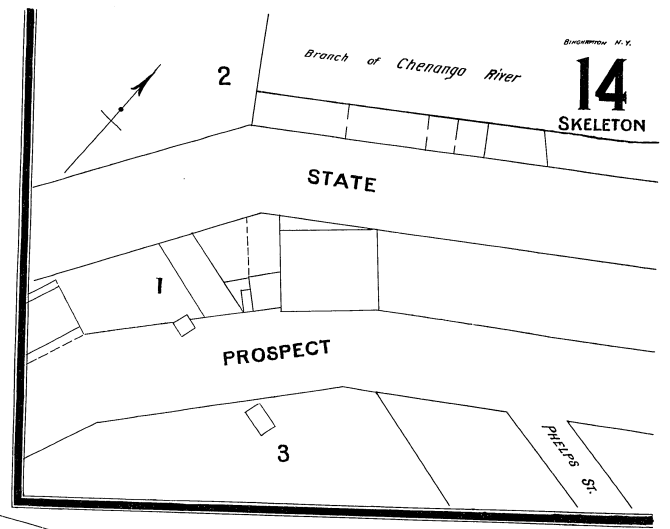


BRIDGEPORT, N. Y.  
**14**  
SKELETON




 
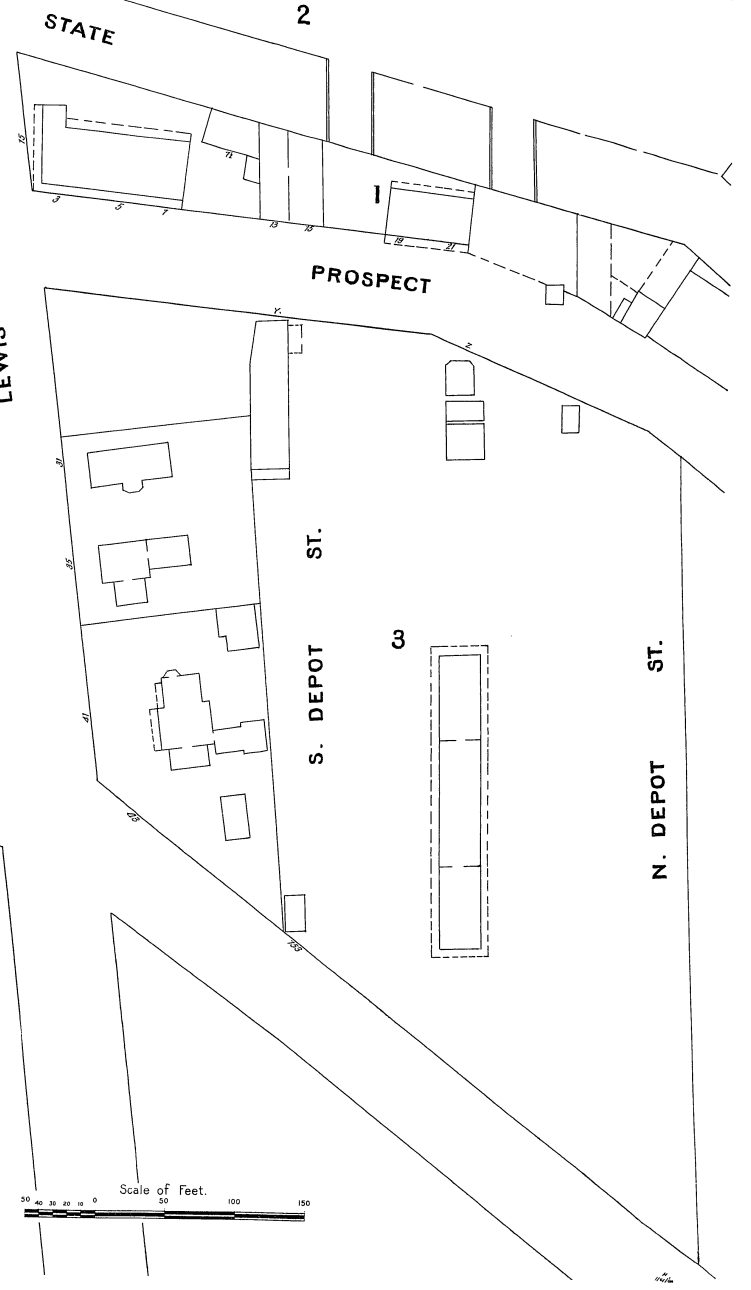






G. Q. MOON & CO.  
MFG. WATCHMEN AND ELECTRIC CLOCK - POWER AND HEAT STEAM -  
PAUL COIL - LIGHTS ELECTRIC - TIME PIPES TAPWORK -  
CHIMNELS - FLOOR SPINDLES THROUGH - ETC. BY CITY WATER AT  
30 LBS PRESS. PER SQ. IN. AND BY LARGE TURBINE STEAM PUMP SHOWN -  
6 BUFFING DUST COLLECTORS - ELEC. FLOOR POLISH -

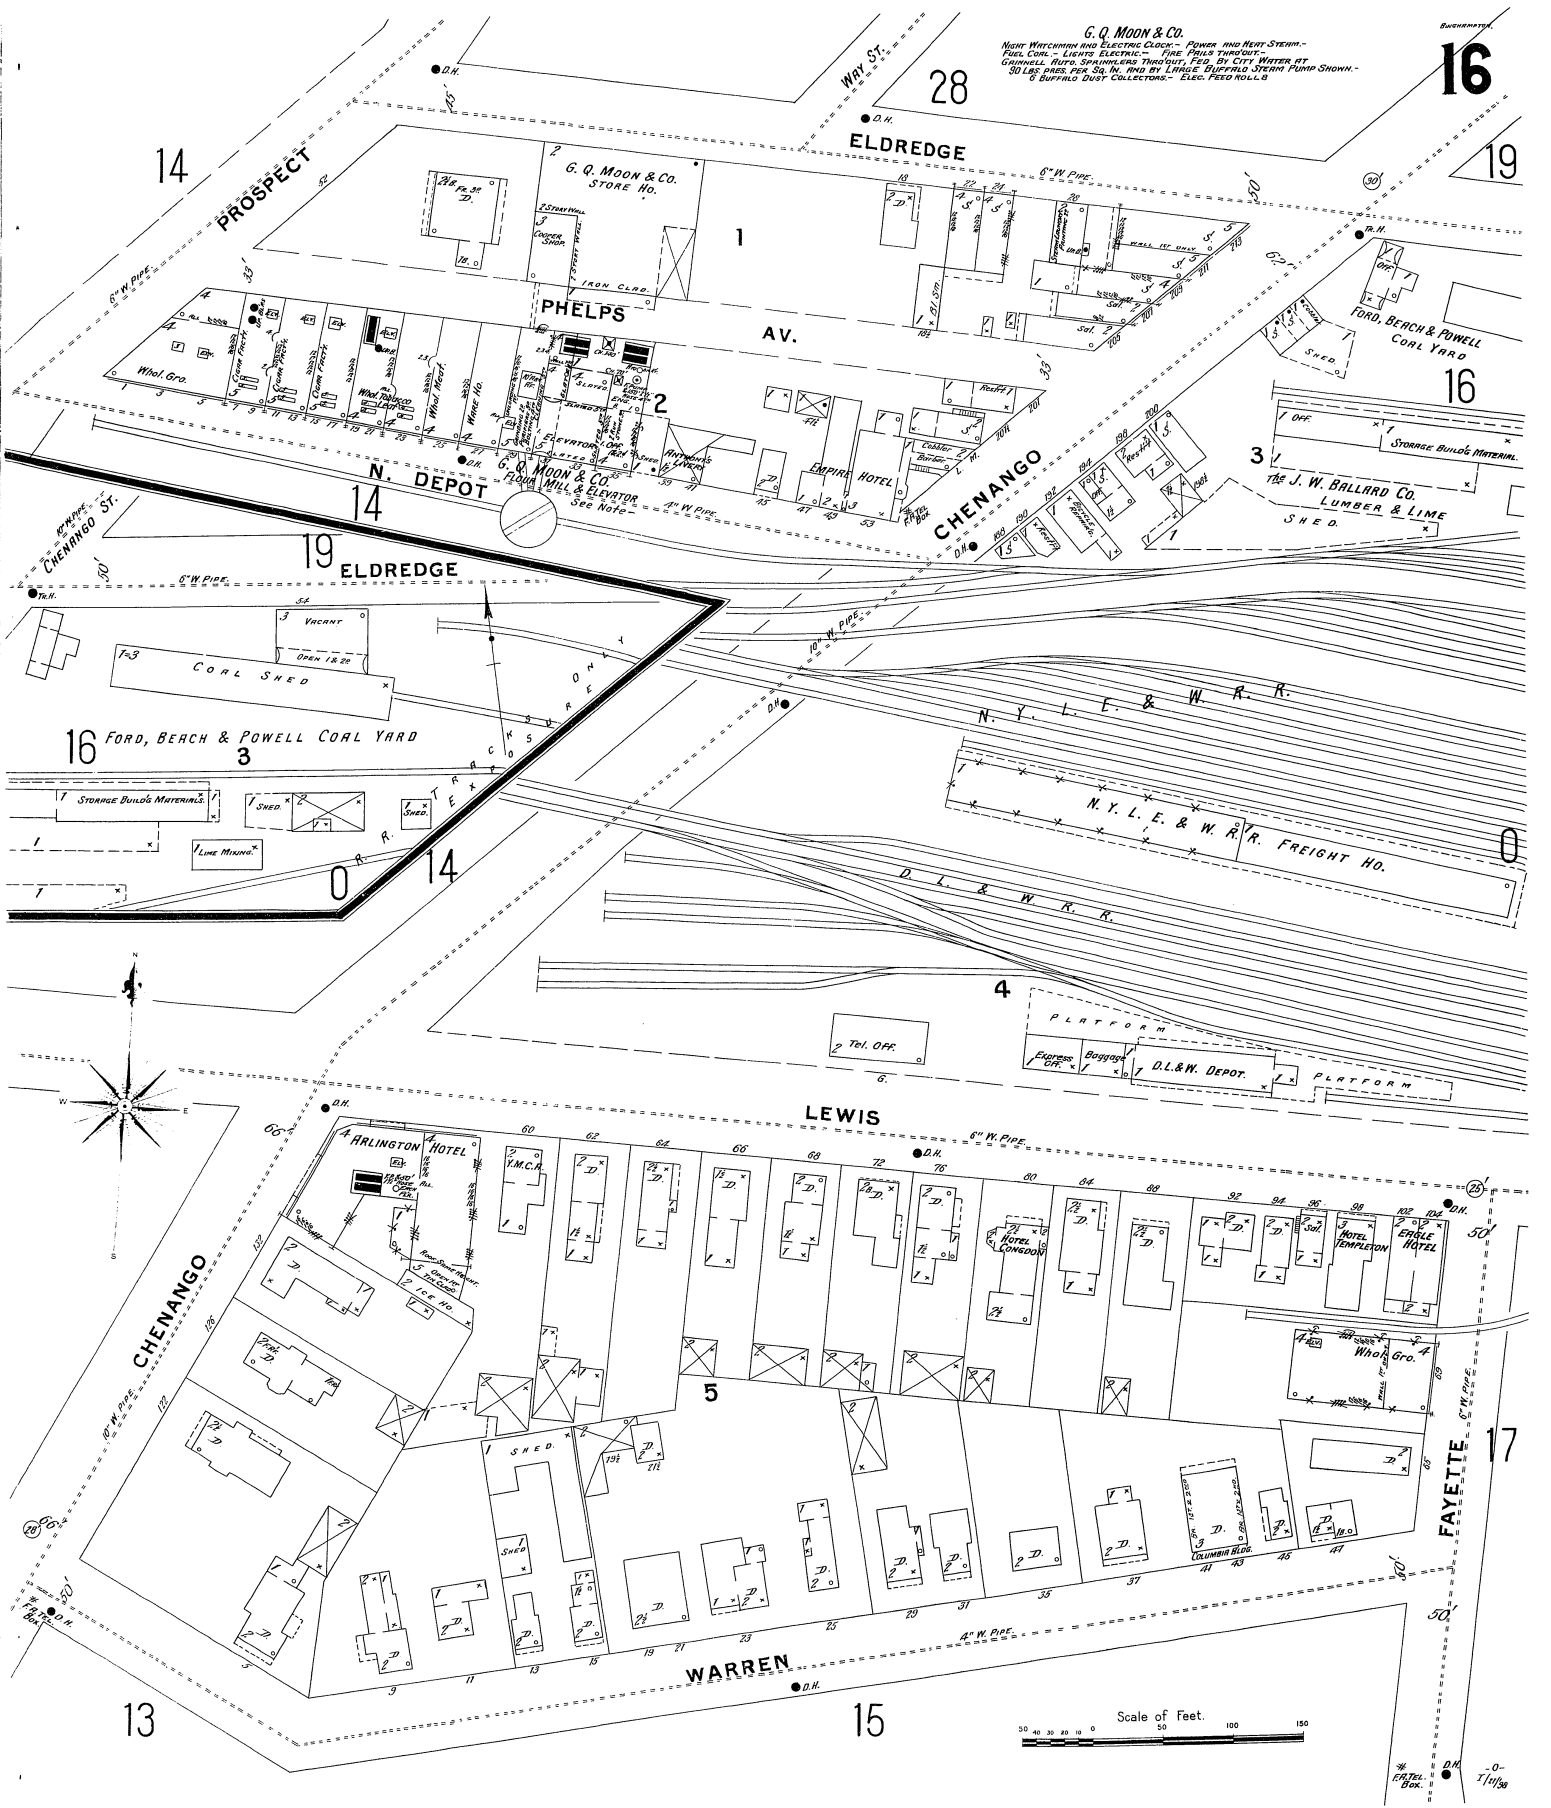

Scale of Feet. 0 50 100 150

 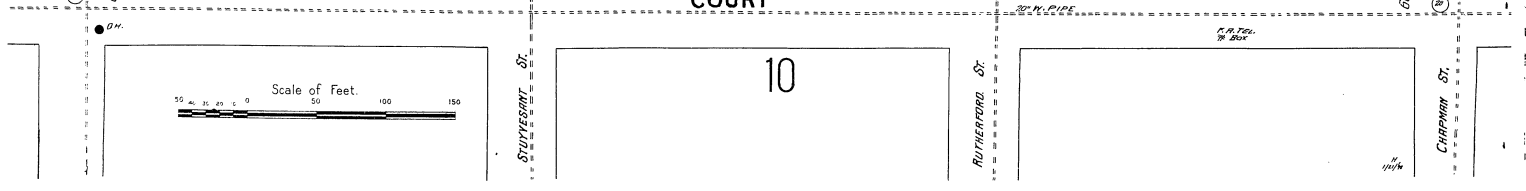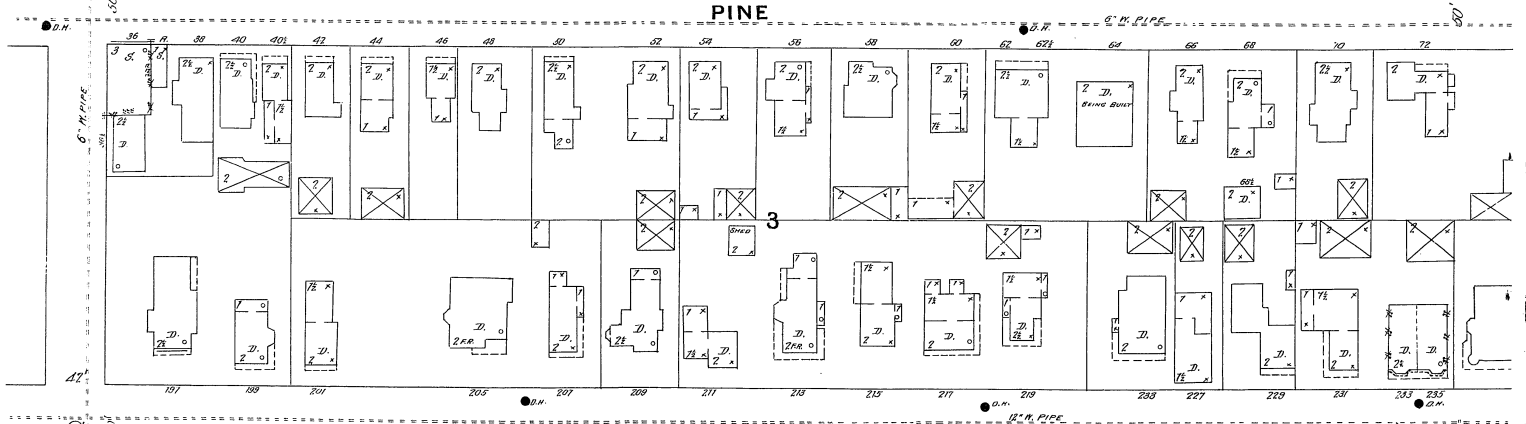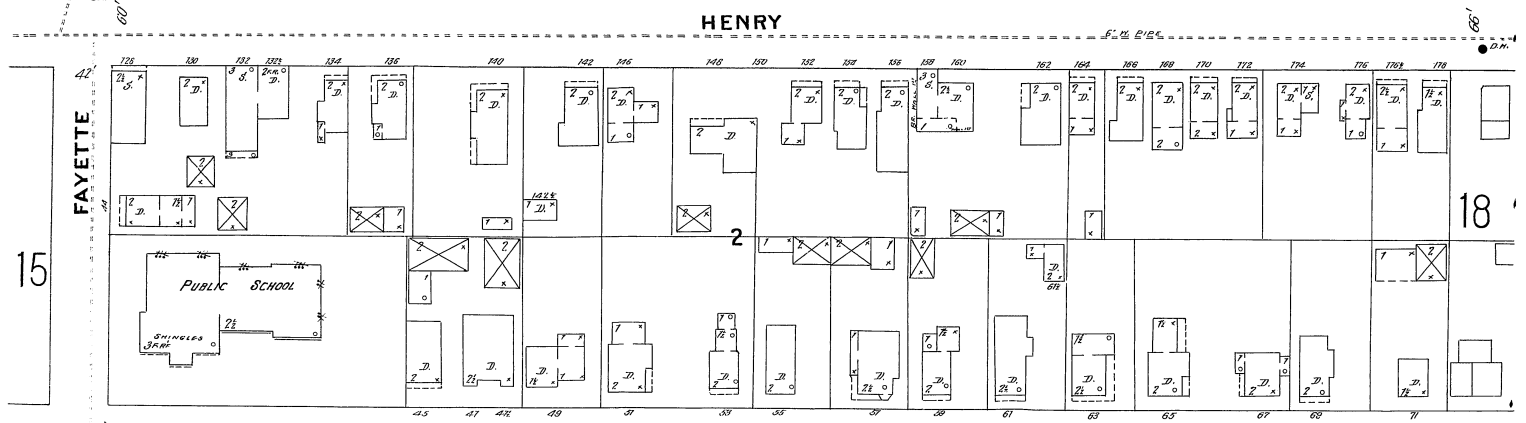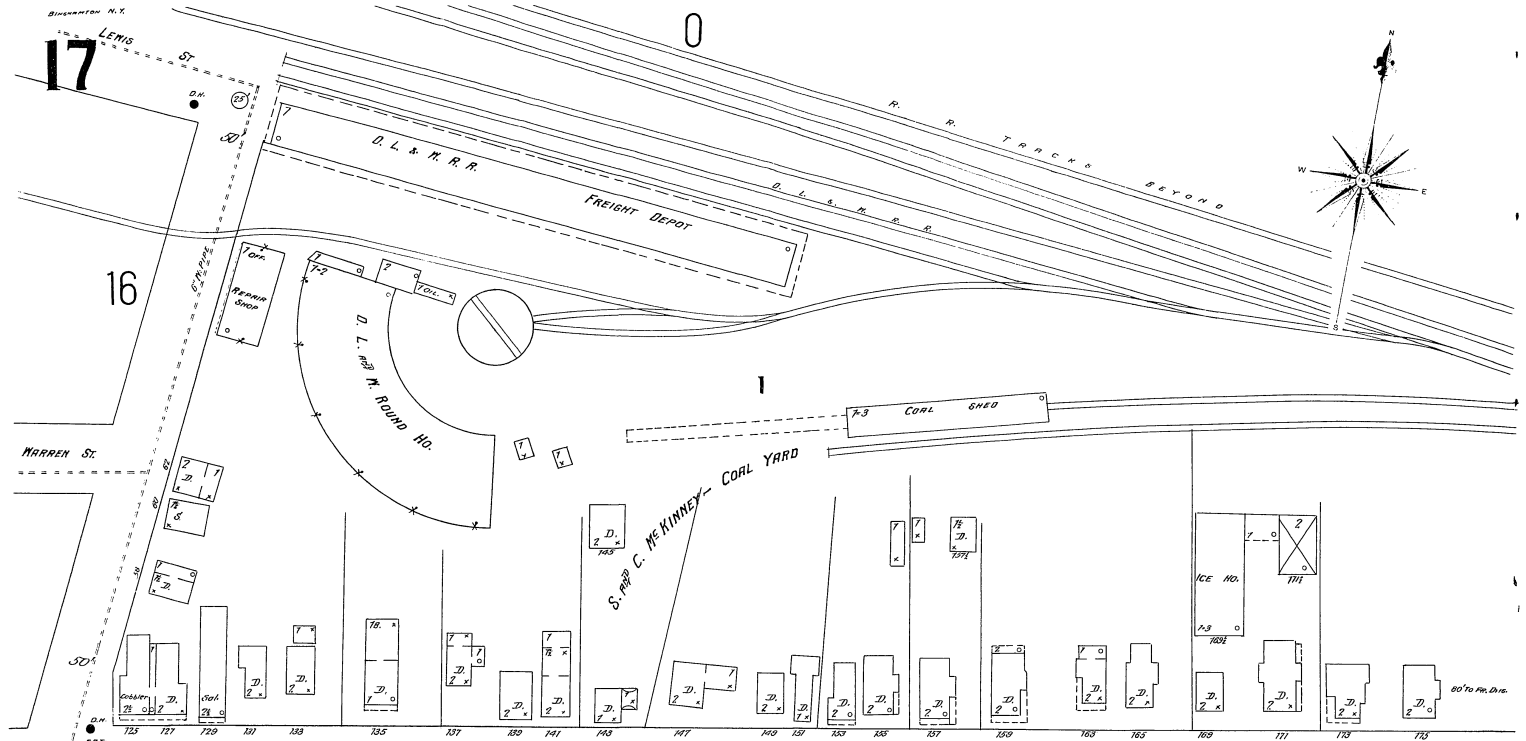

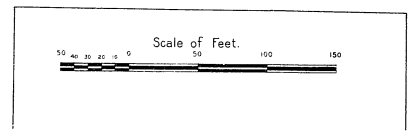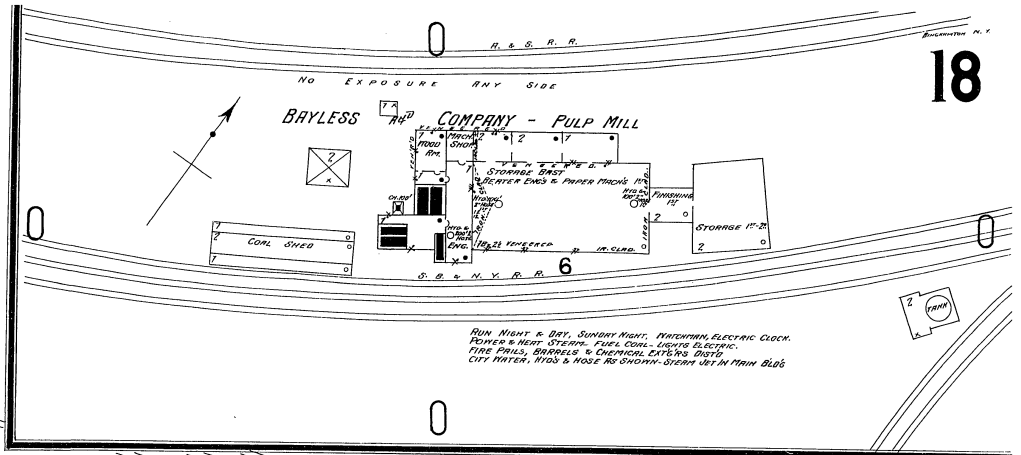

12

27

4

2

17

HENRY

PINE

COURT

LIBERTY

BAYLESS COMPANY - PULP MILL

R. R. TRACKS BEYOND

RUN NIGHT & DAY, SUNDAY NIGHT, WATERMAN, ELECTRIC CLOCK. POWER & HEAT STEERS. FUEL COAL. LIGHTS ELECTRIC. FIRE PAILS, BARRELS & CHEMICAL EXTINGUISHERS. CITY WATER, HYD. & HOSE AS SHOWN - STEER SET IN MAIN BLDG.



21

LYON

20

BRANDYWINE AV.

MUNSELL

8

ROBINSON

19

DOUBLEDAY

C E M E T E R Y

LIBERTY

5

ELDREDGE

CARLUCCI STONE CO.




THE D. & H. REPAIR SHOPS PRINTING

6

D. & H. DEPOT

ROUND HO.


Scale of Feet

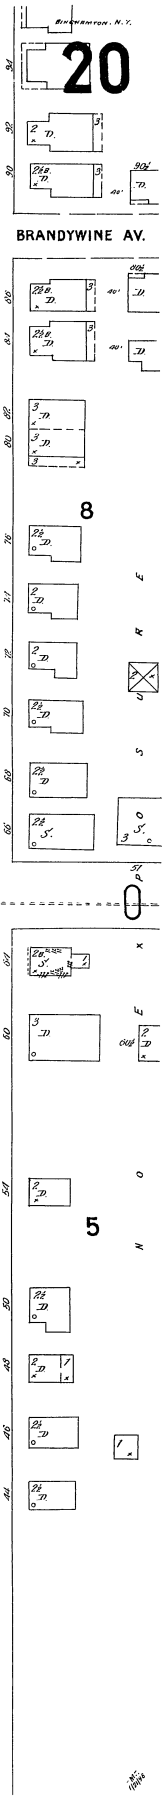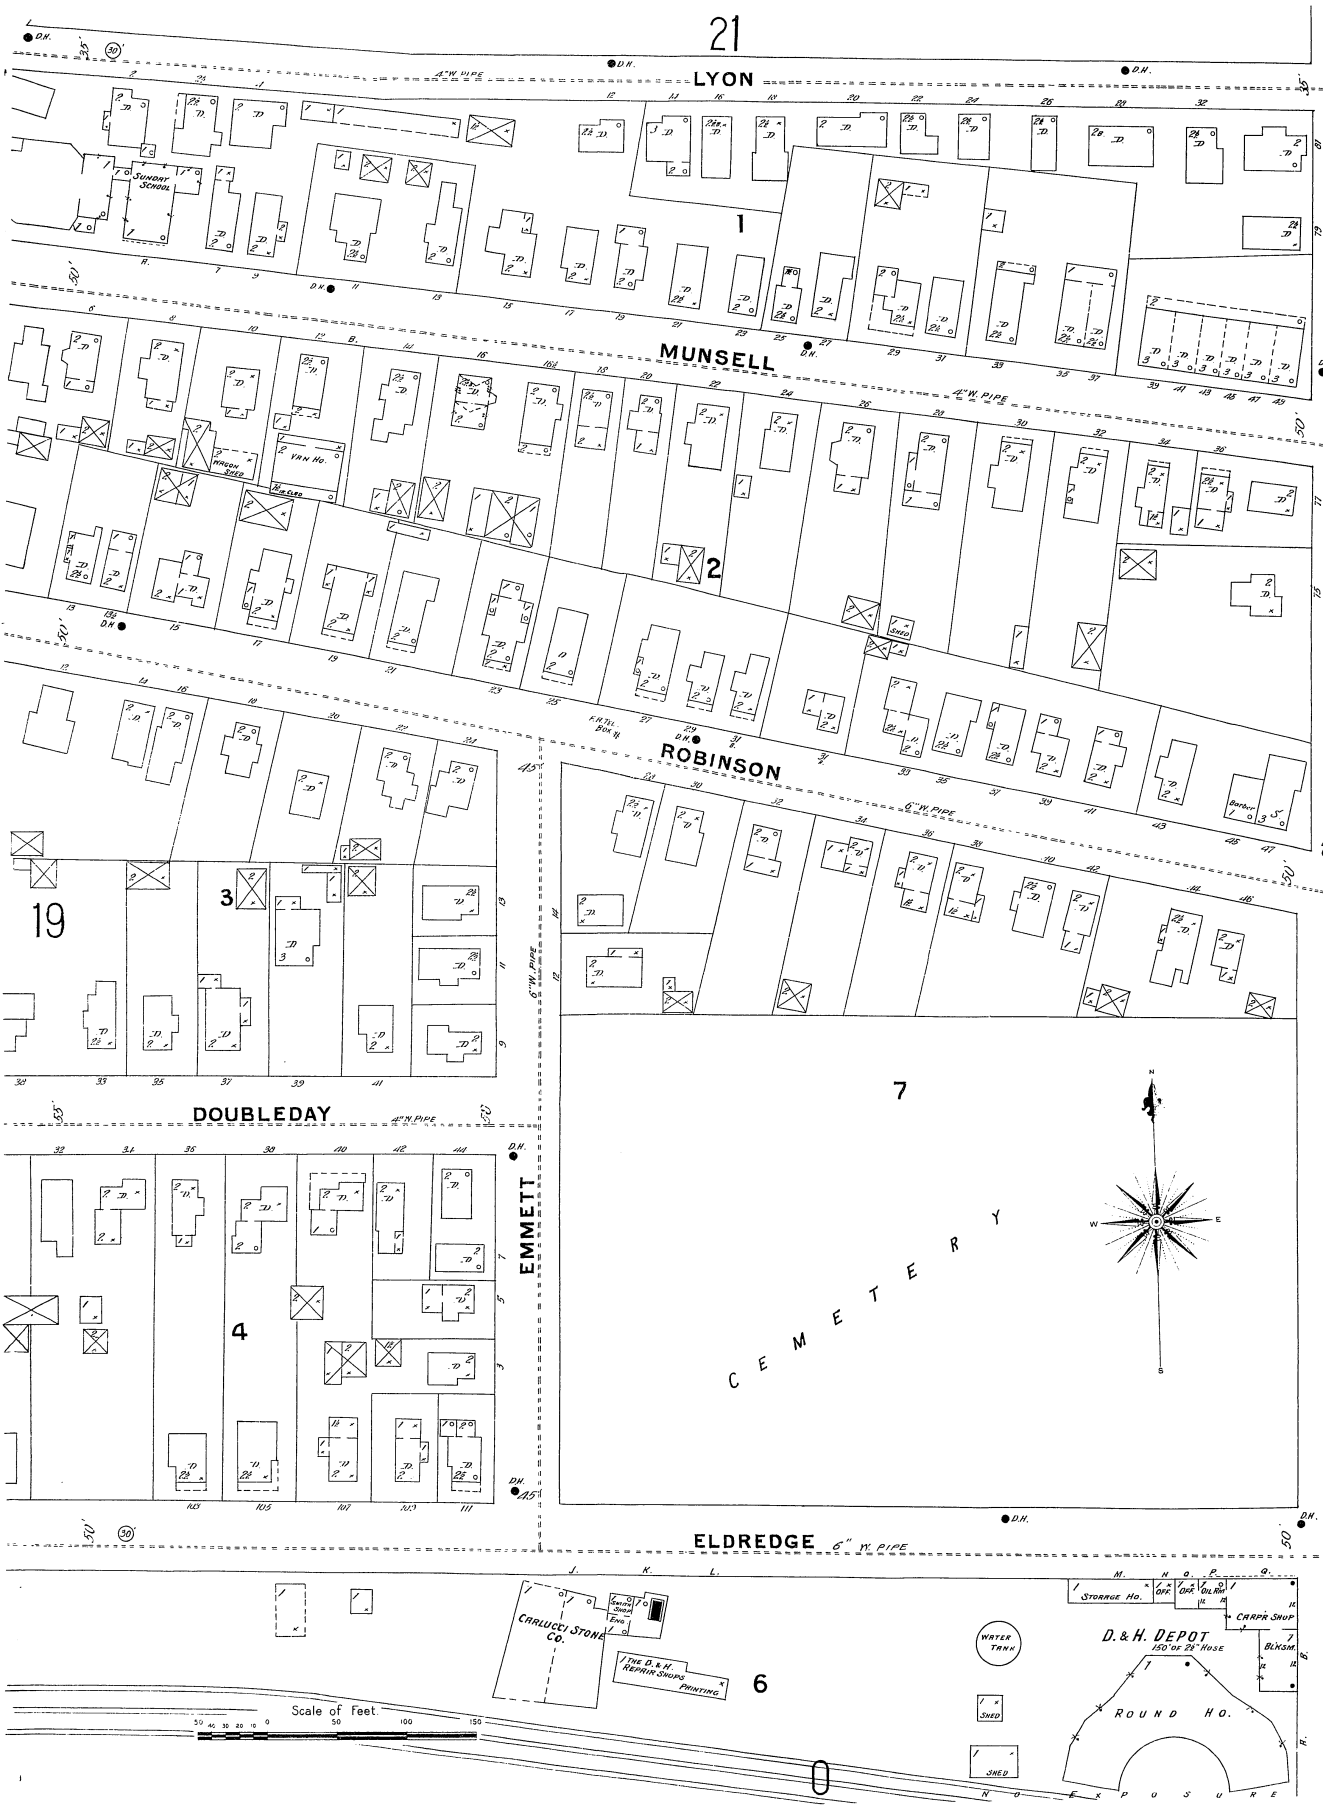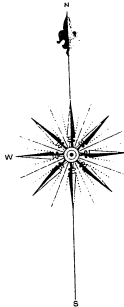

1000'



N O E X P O S U R E 0

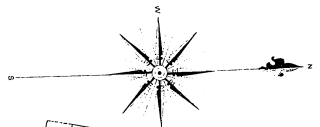

21

19

3

STATE

CHENANGO

22

ROBERT

PEARNE

VIRGIL

FREDERICK

 
20

LYON

LIBERTY


8

Scale of Feet.



BRANDWINE ST.




1/111

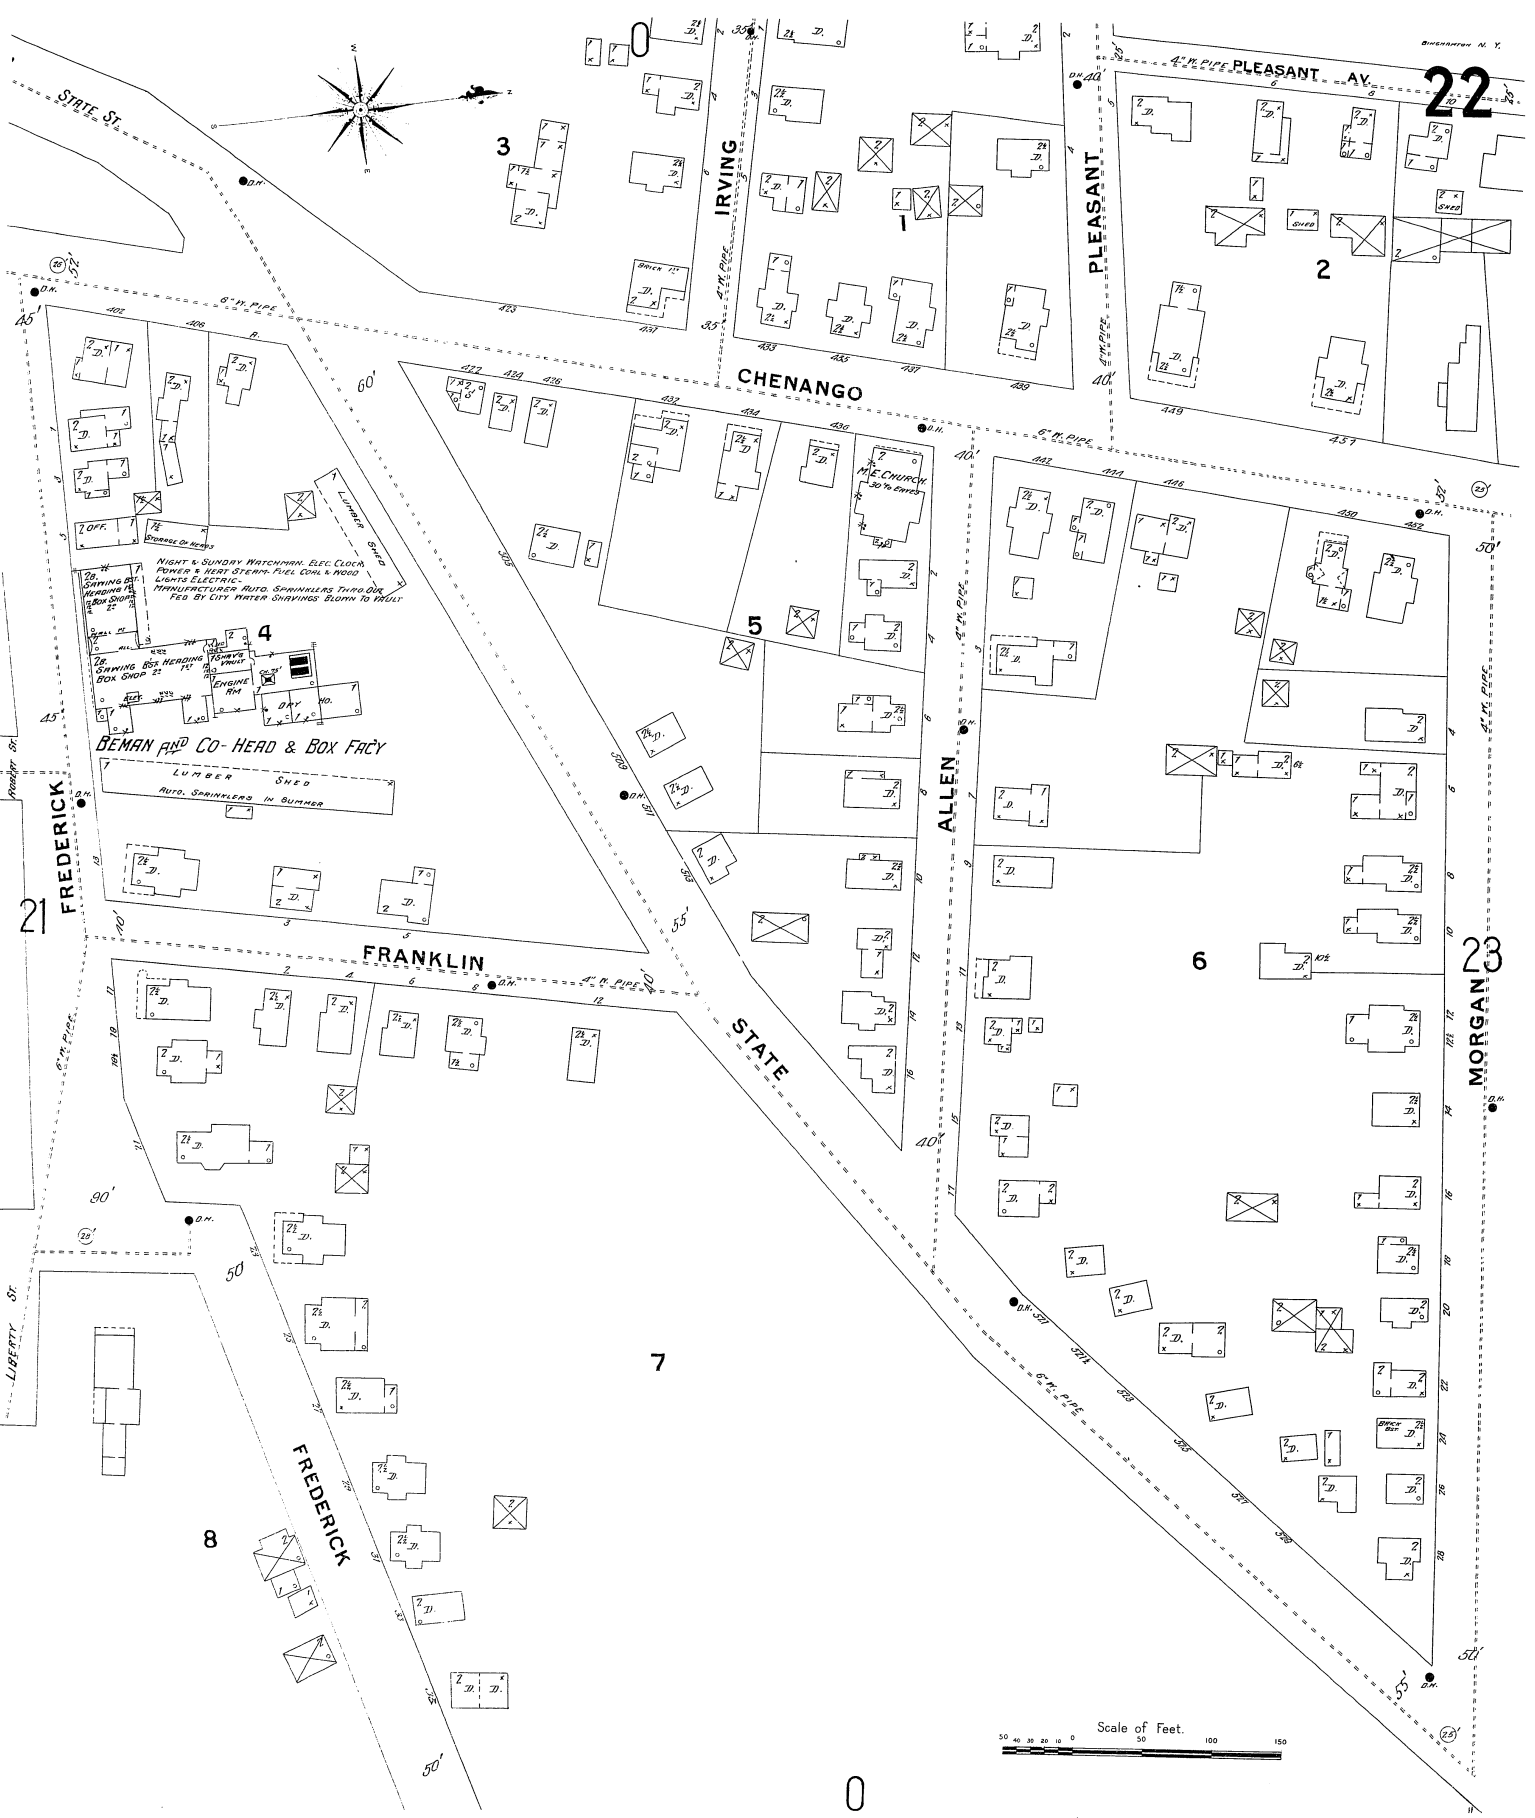


22

23

 0

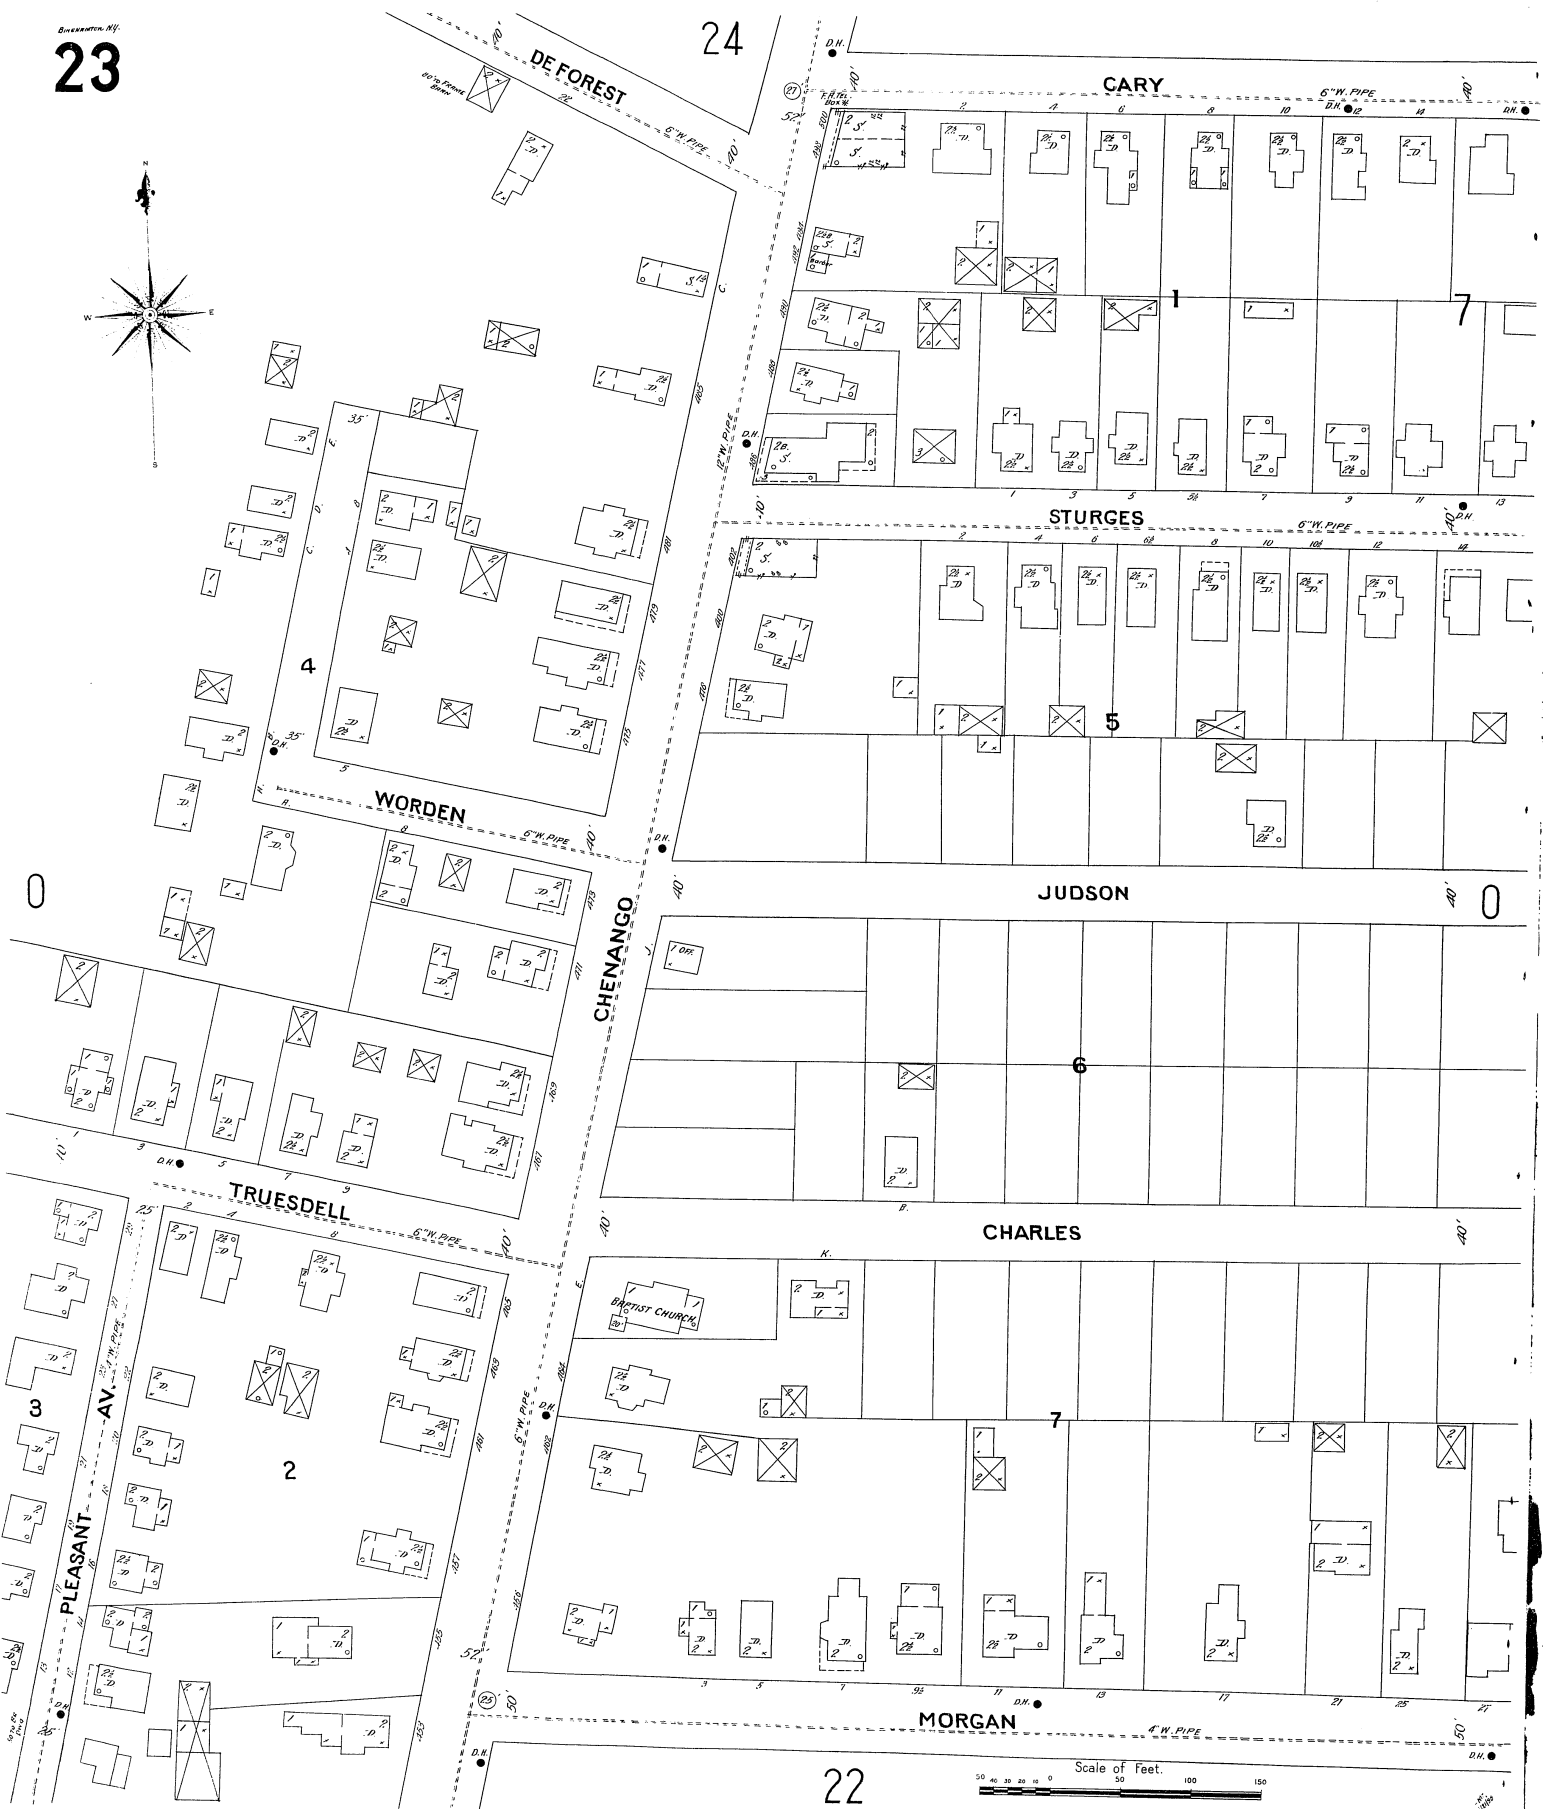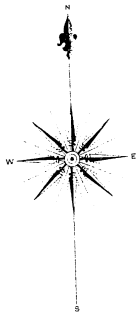





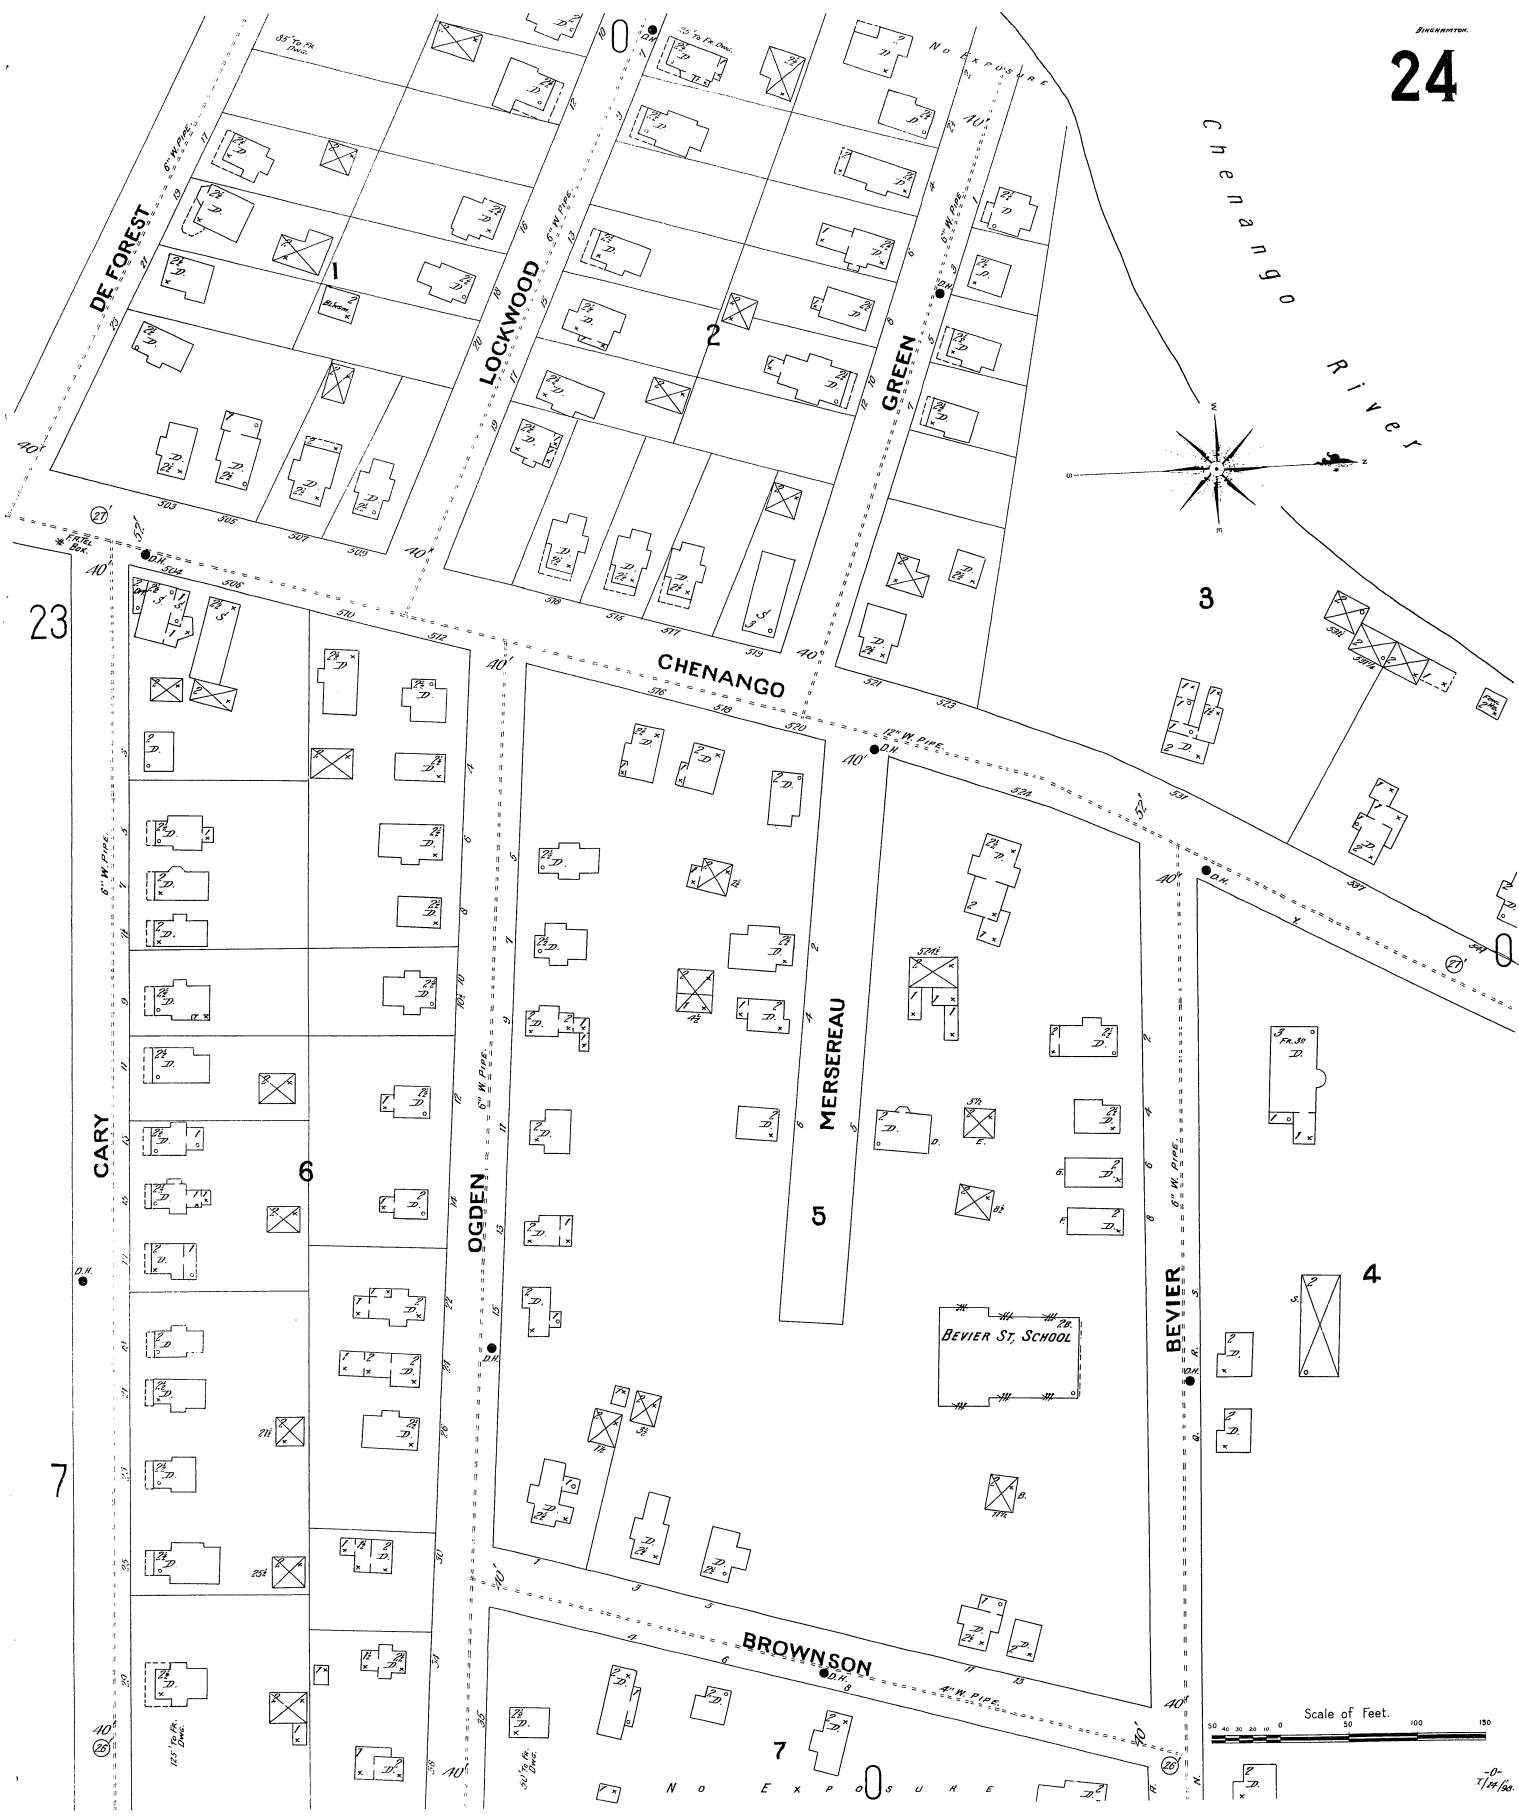





Scale of Feet. 0 50 100 150

NO EXPOSURE







1/16" = 1'

25

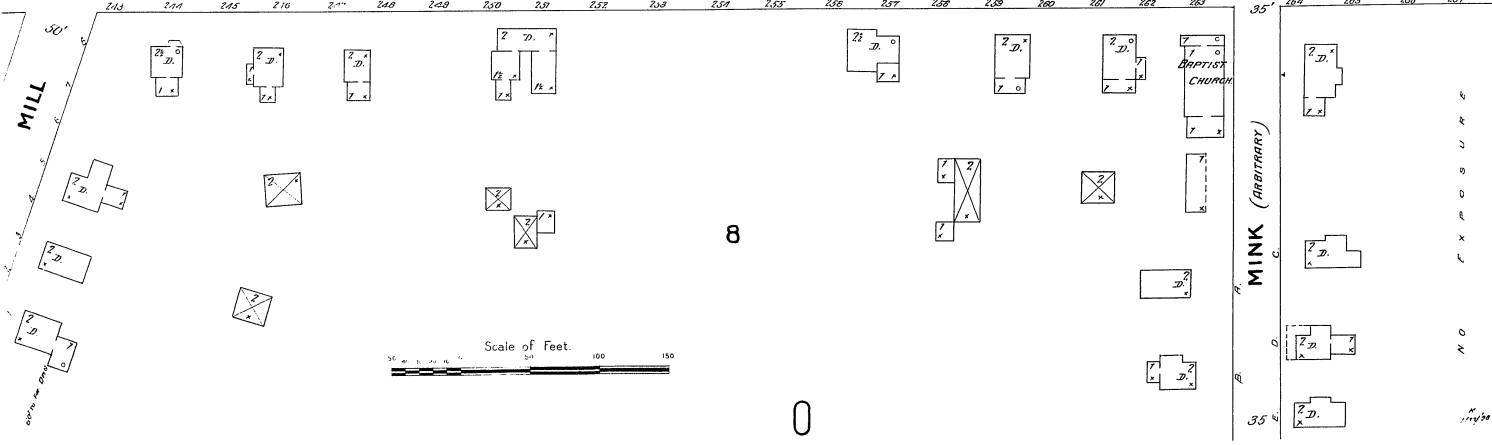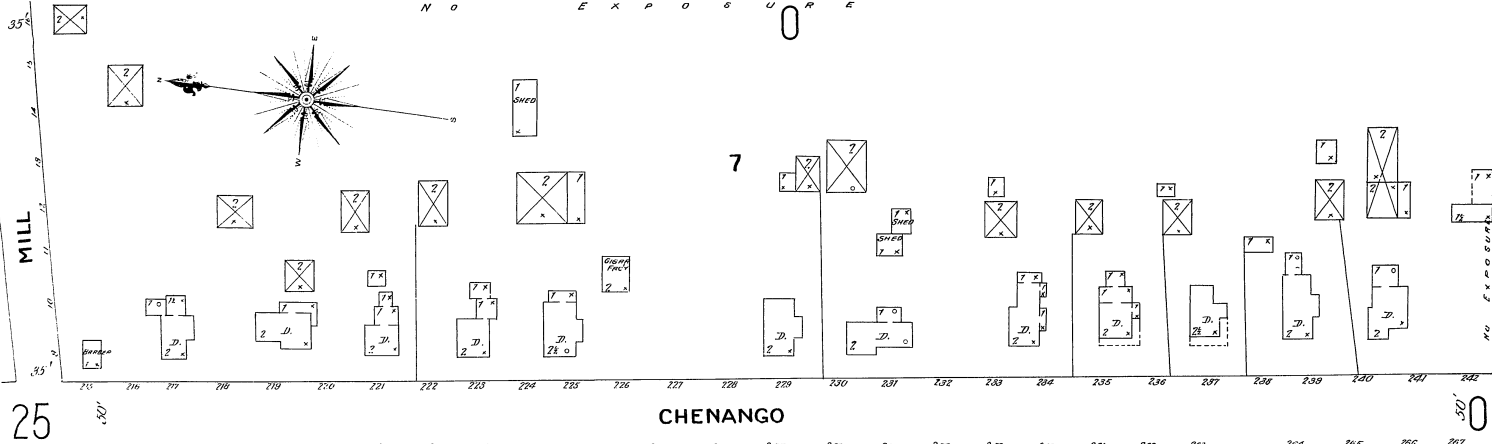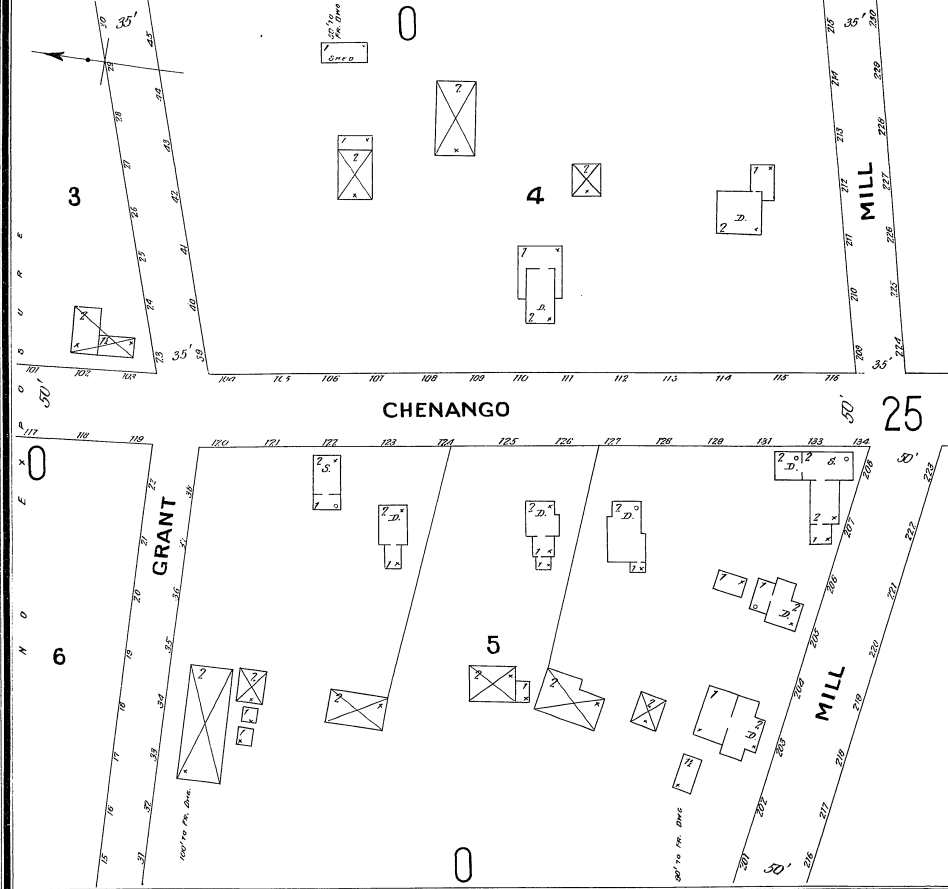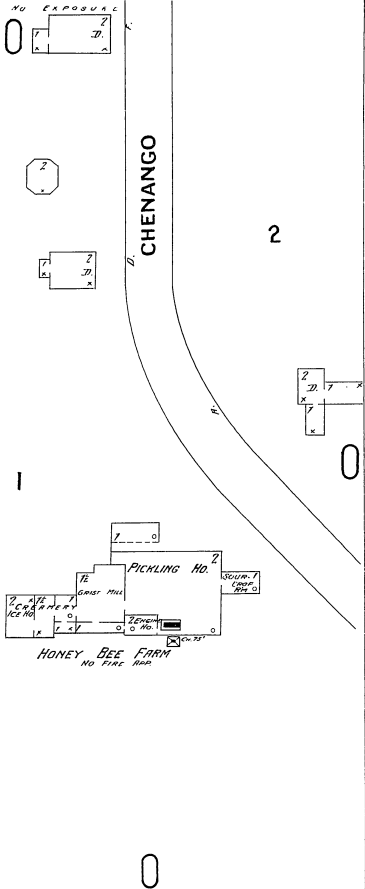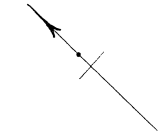

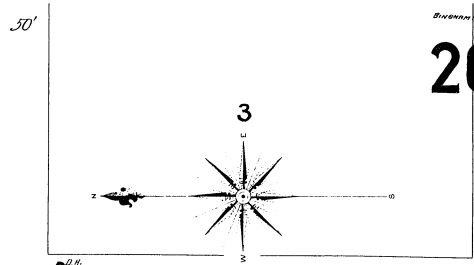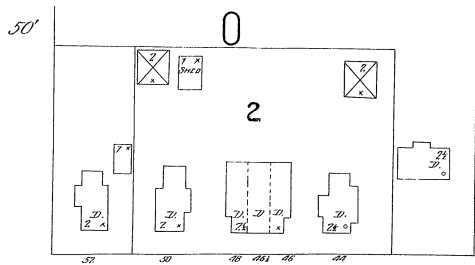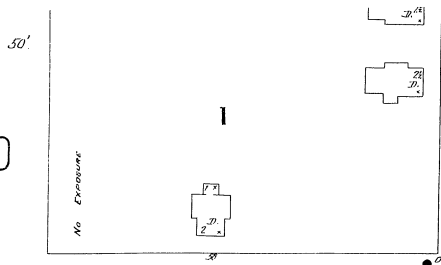

GRISWOLD

 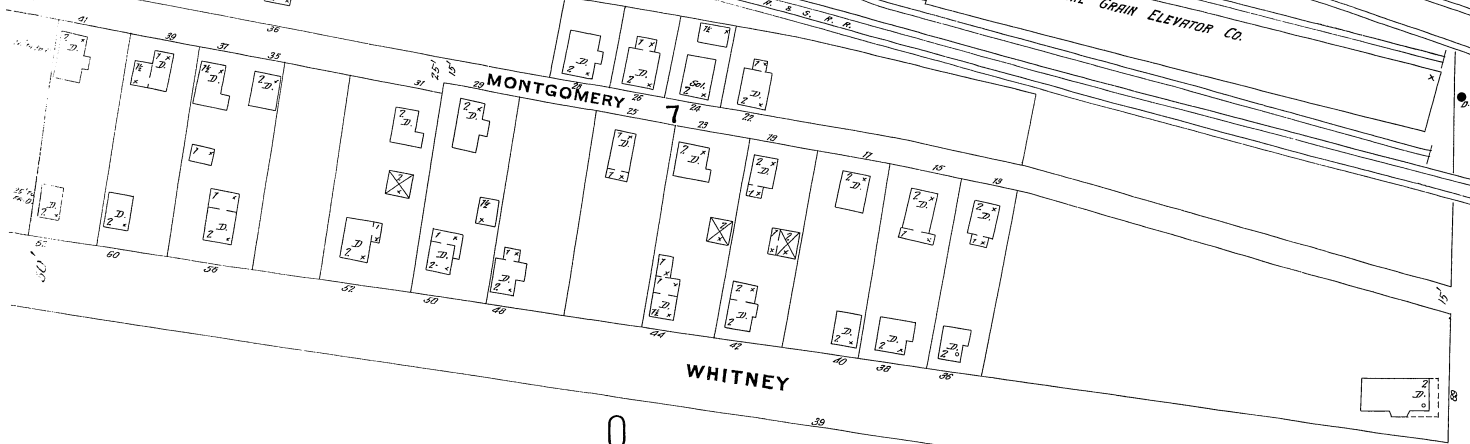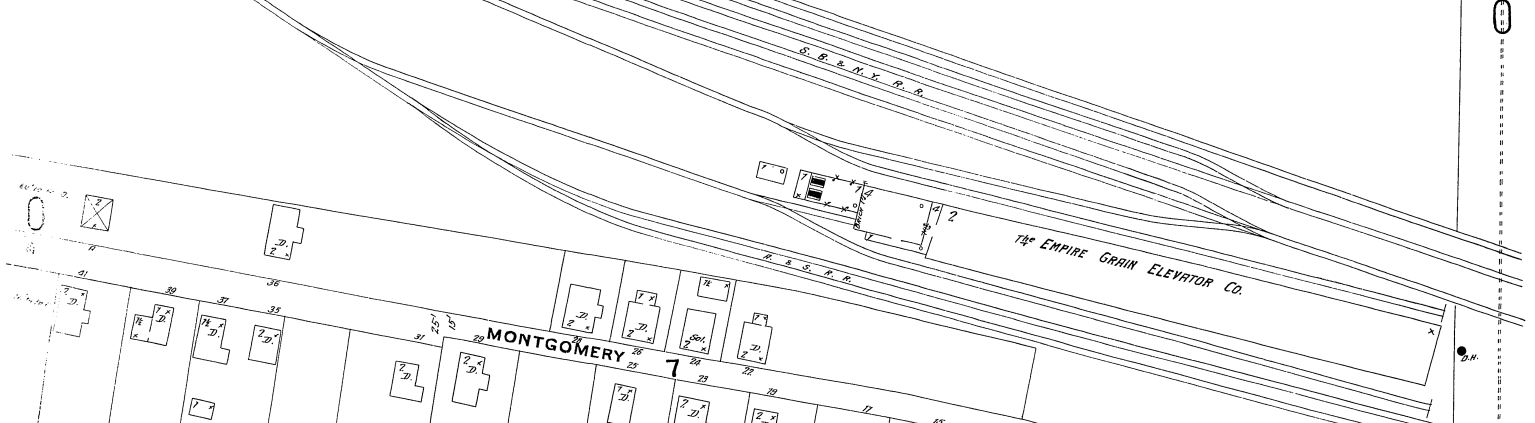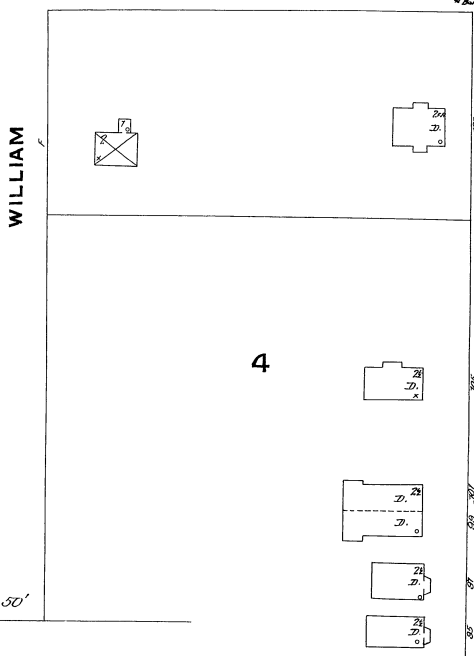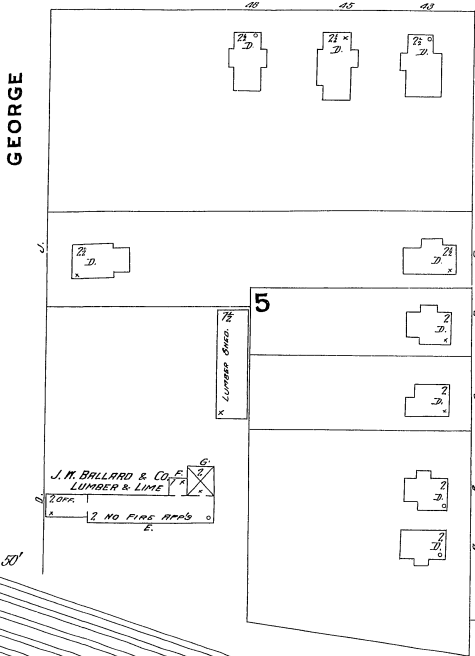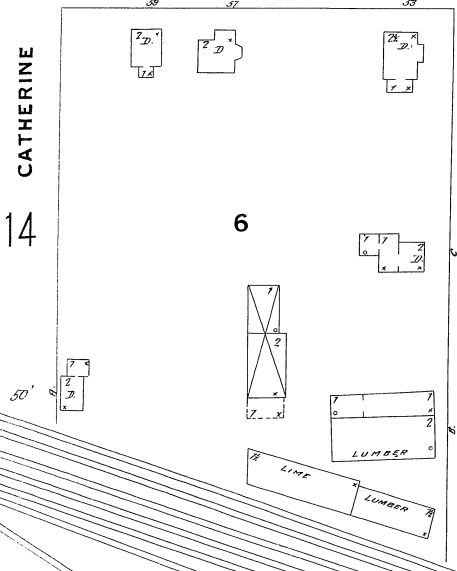

ROBINSON

N O E X P O S U R E

NIGHT & SUNDRY WATCHMAN - NO CLOCK -  
FUEL COIL - 200' TO HOUSE  
CHEMICAL EXTINGUISHERS THROUGH OUT -

BINGHAMTON OIL REFINERY  
COOPER SHOP  
STORE NO. 14

BINGHAMTON WATER WKS  
PUMPING STATION

BINGHAMTON ELECTRIC CO.  
GEN. OFFICE & OFF. STAMPS RM.  
GENERATOR RM.  
CORL SHED

BINGHAMTON GAS & ELECTRIC CO.  
HEATING WATER GAS  
HEAT WATCHMAN - LIGHTS GAS -  
HOSE & POWER STEAM FROM  
BINGHAMTON ELECTRIC CO.

CRANDALL, STONE & CO.  
CARRIAGE HARDWARE & TRIMMING MFG

BINGHAMTON MATCH CO.



BINGHAMTON WATER WKS  
PUMPING STATION

Susquehanna River


COURT

COURT

N O E X P O S U R E

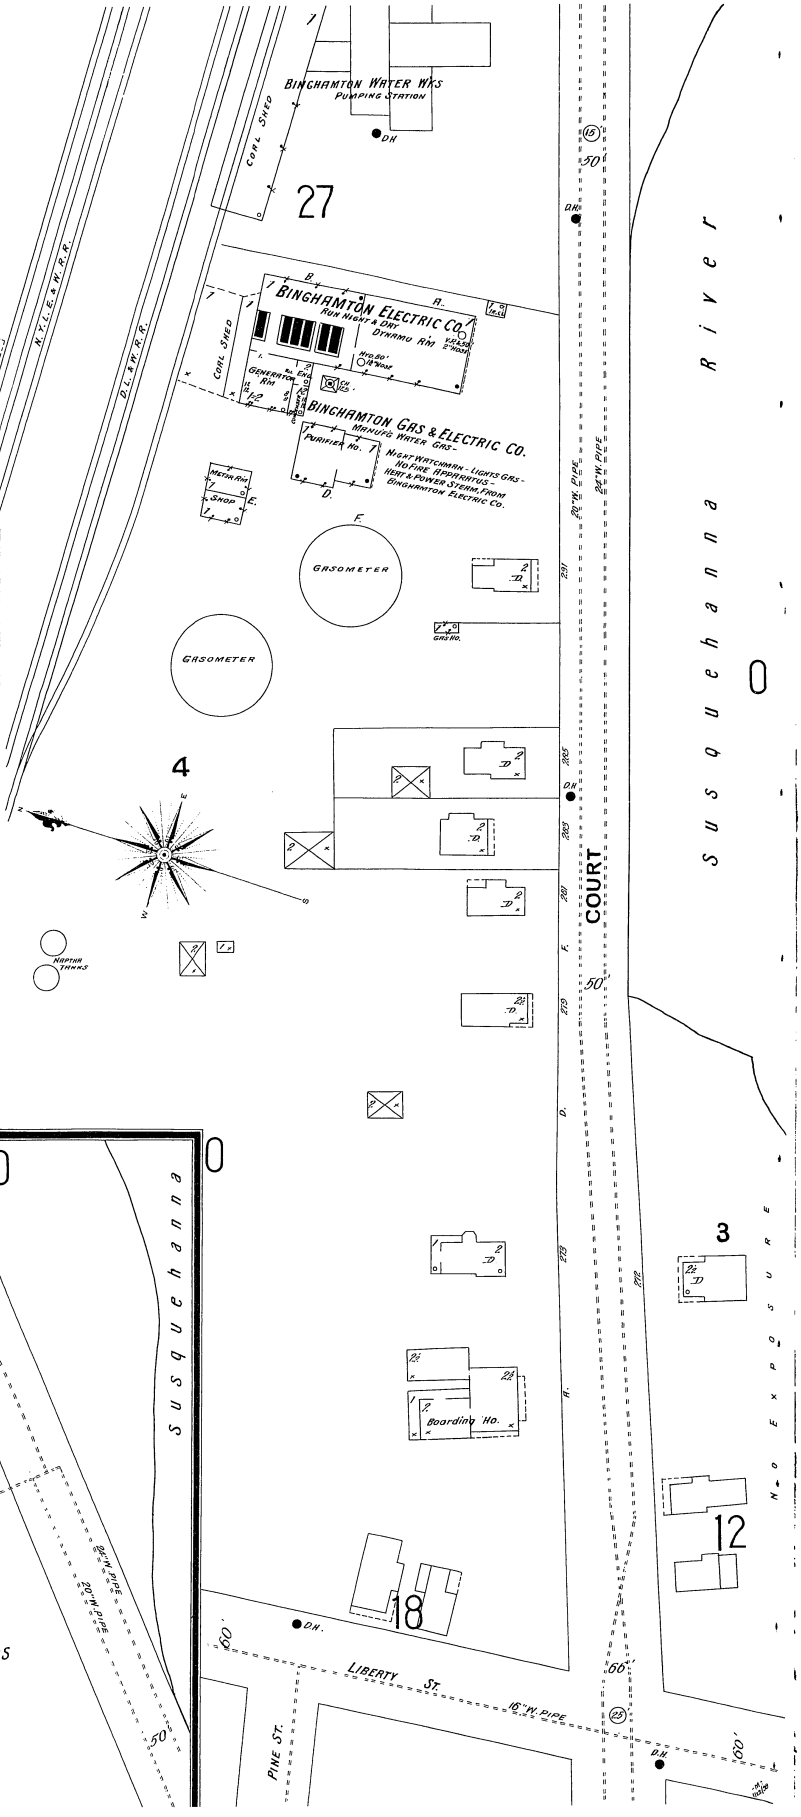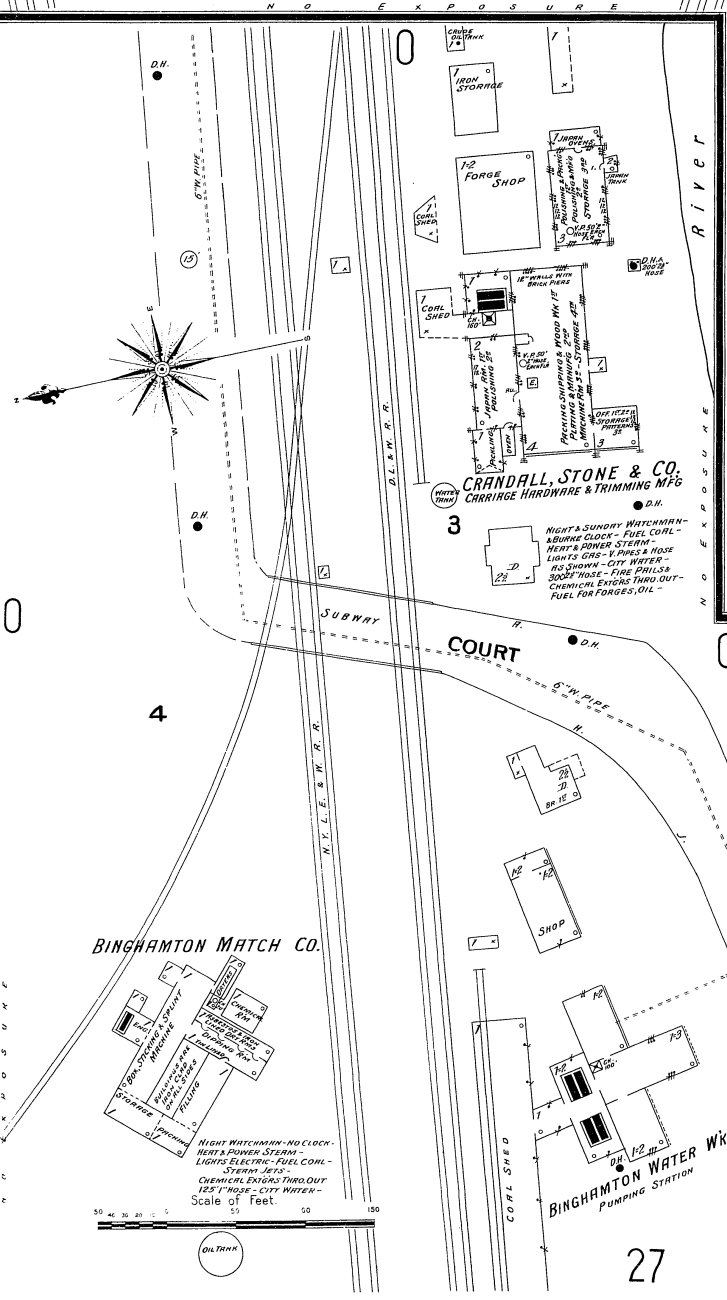

Scale of Feet. 50 40 30 20 10

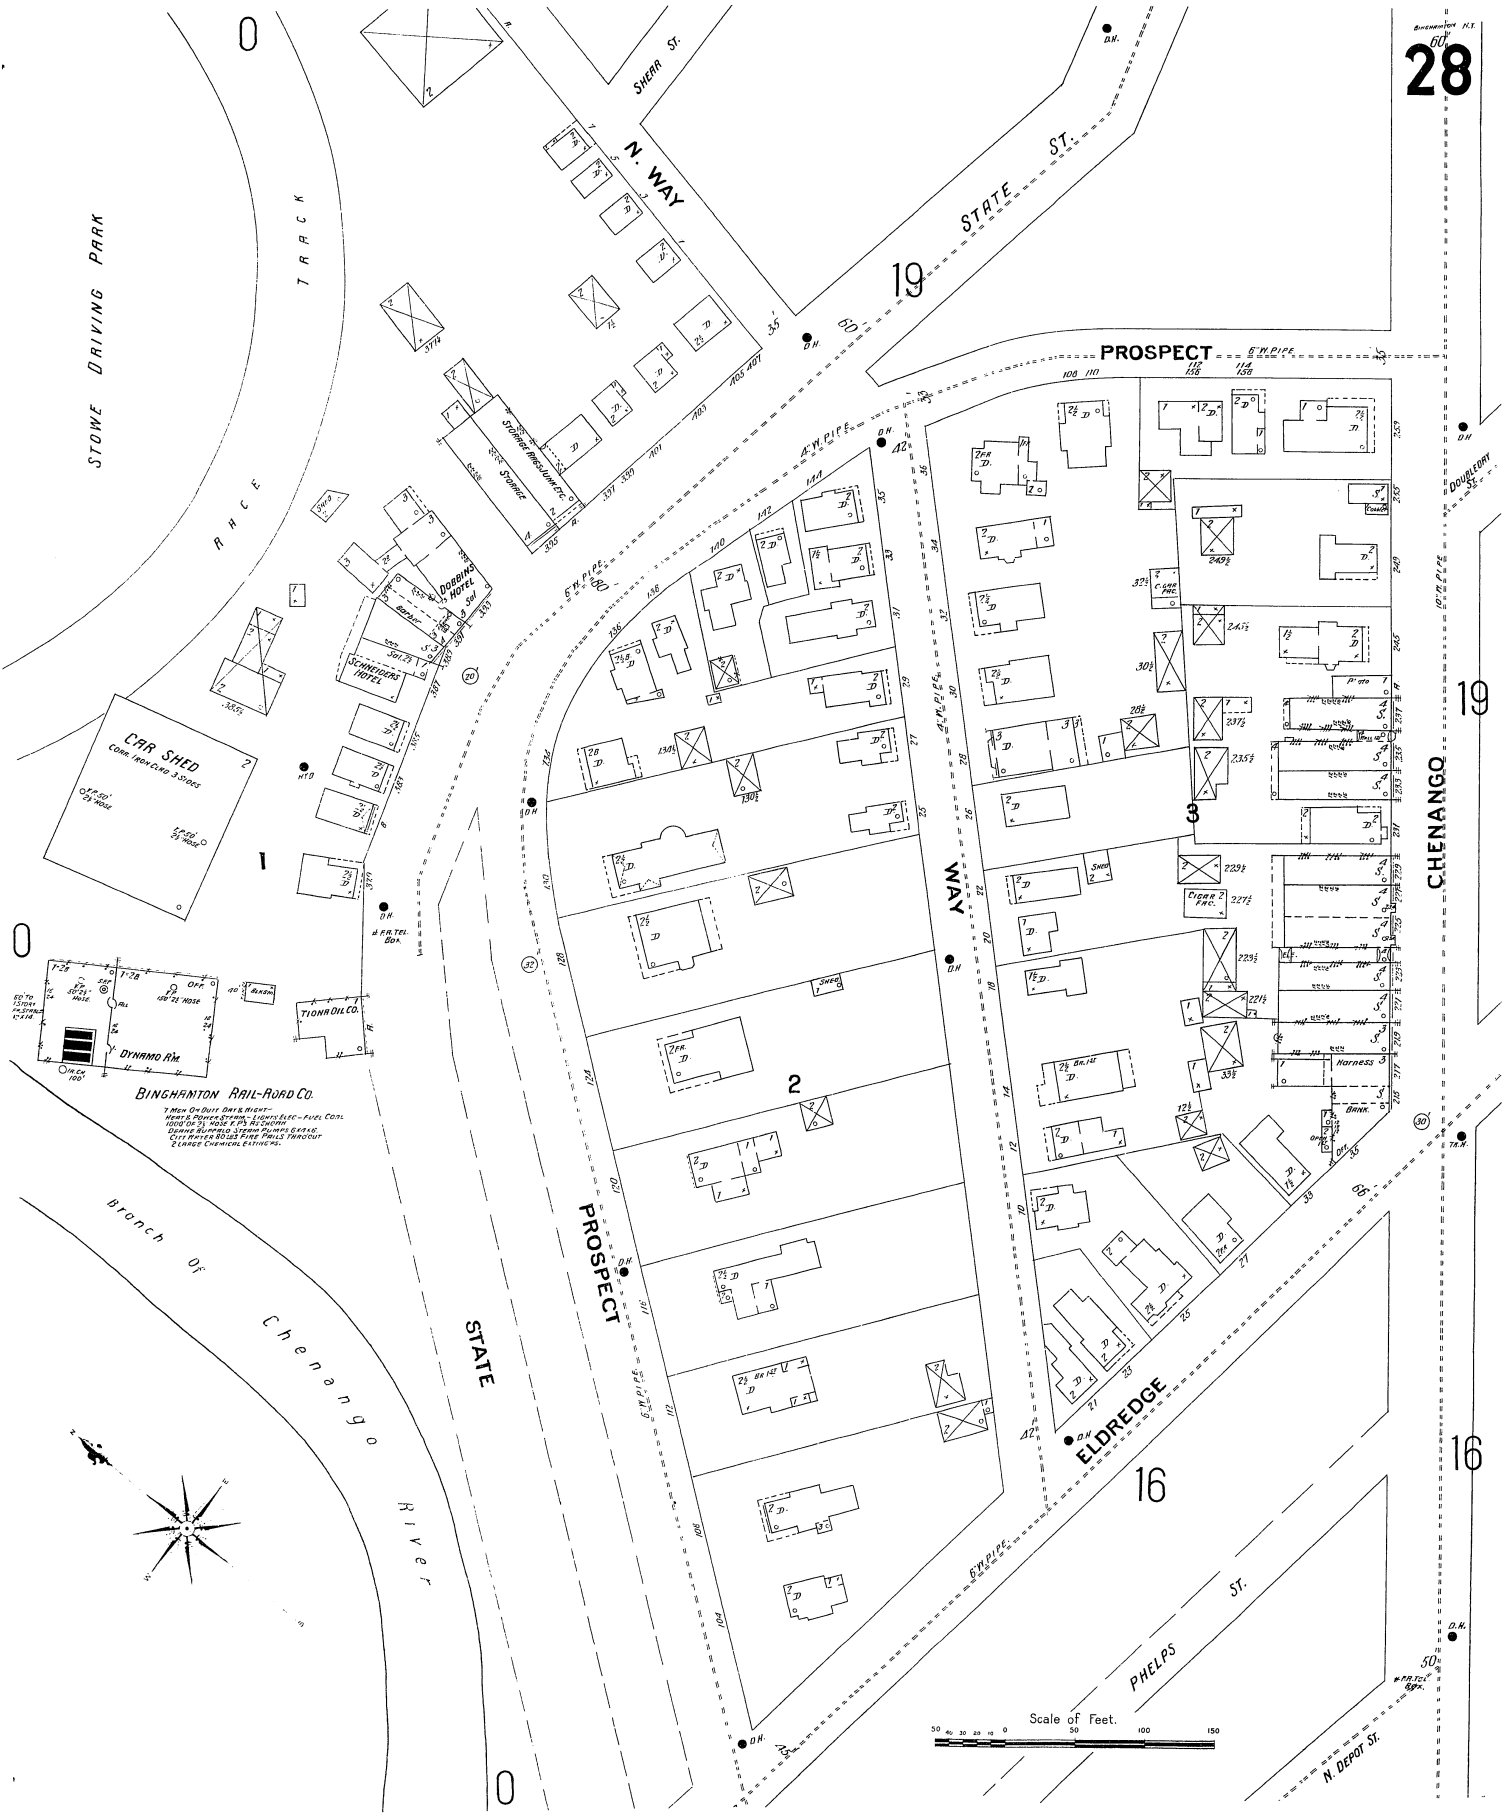


19

16

Scale of Feet.

0 50 100 150

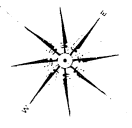

BINGHAMTON RAIL-ROAD CO.

1 Main Office Building  
 2 Main Office Building  
 3 Main Office Building  
 100 Main Office Building

CPR SHED  
 Coal Iron and Steel

DYNARD OIL CO.

CHENANGO TRUCK

CHENANGO HOTEL

CHENANGO HOTEL

CHENANGO HOTEL

CHENANGO HOTEL

CHENANGO HOTEL

CHENANGO HOTEL

CHENANGO HOTEL

29

31

MURRAY

48

NO EXPOSURE

1

2

3

AYRES

OAK


OAK

RIVERSIDE DRIVE

30

4

6

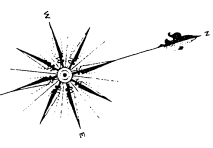

Susquehanna River


Scale of Feet






FRONT

5





0-1/4"

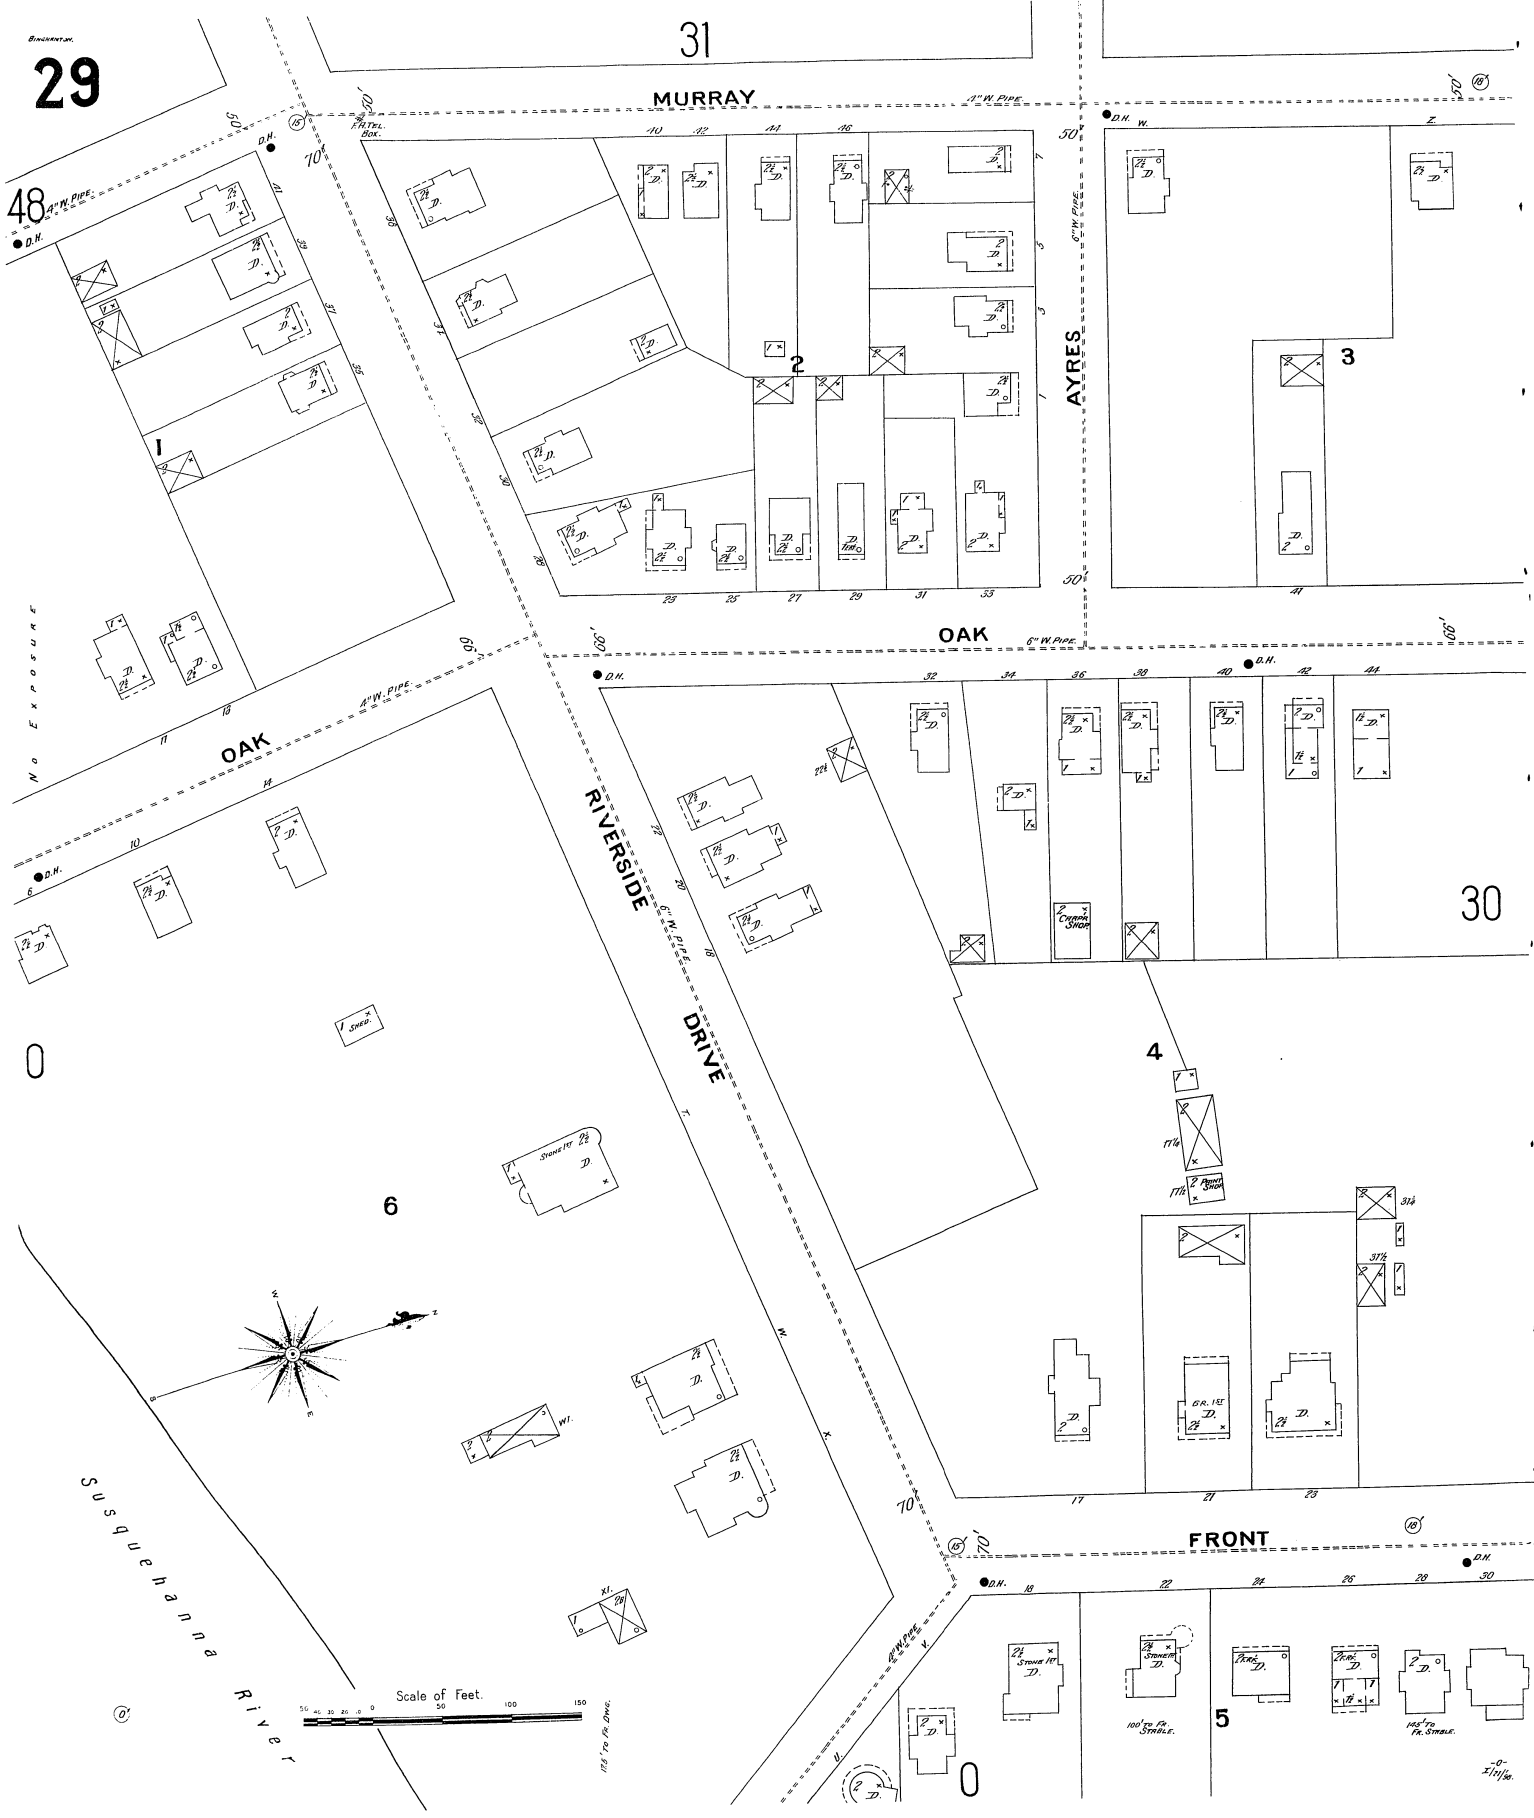





32 MURRAY 30

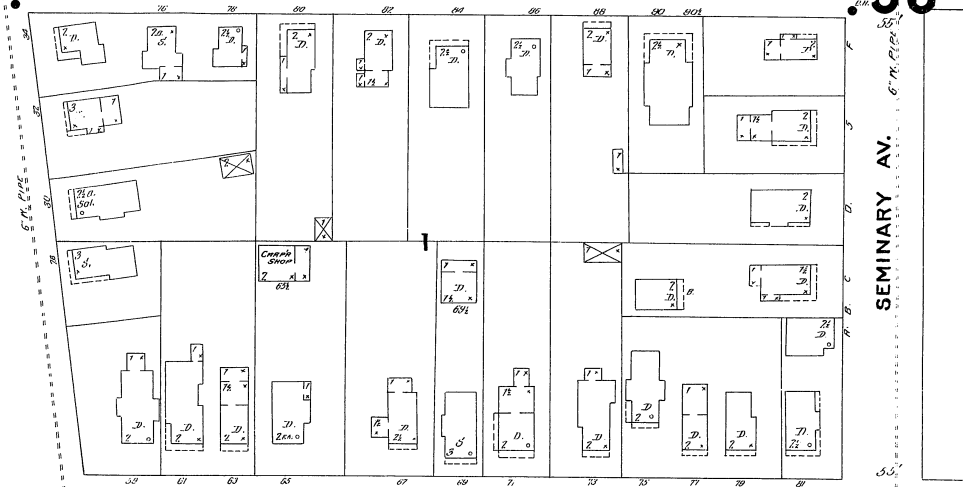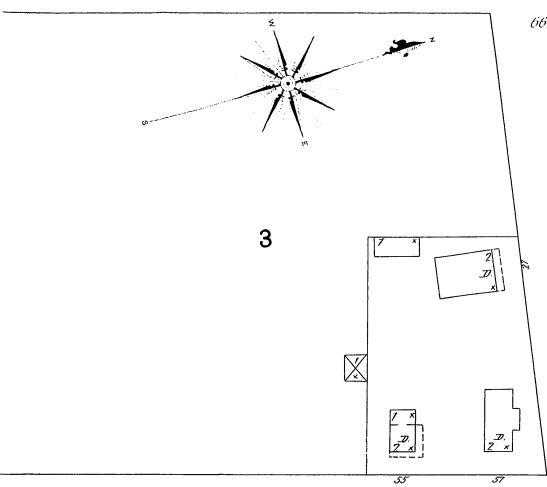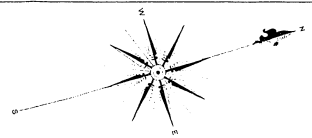

OAK

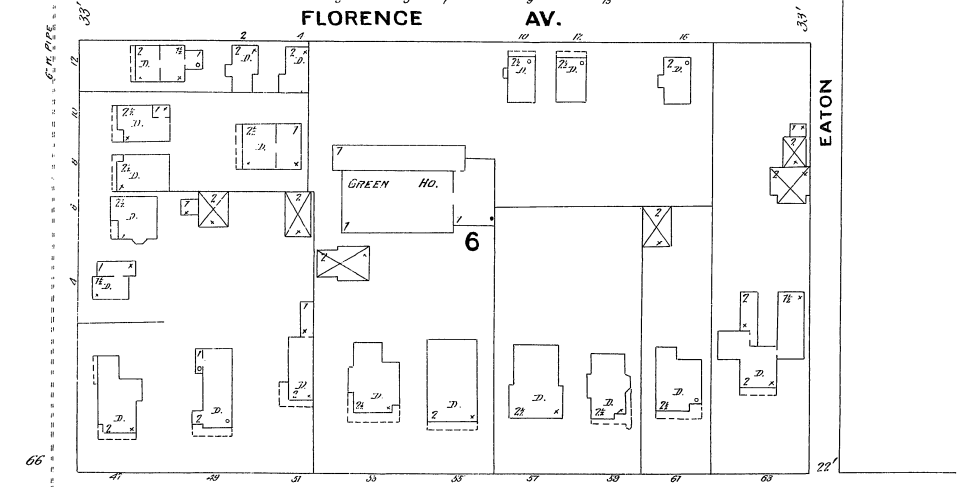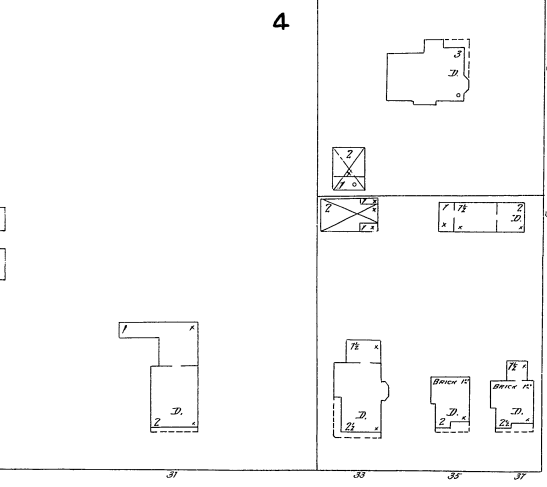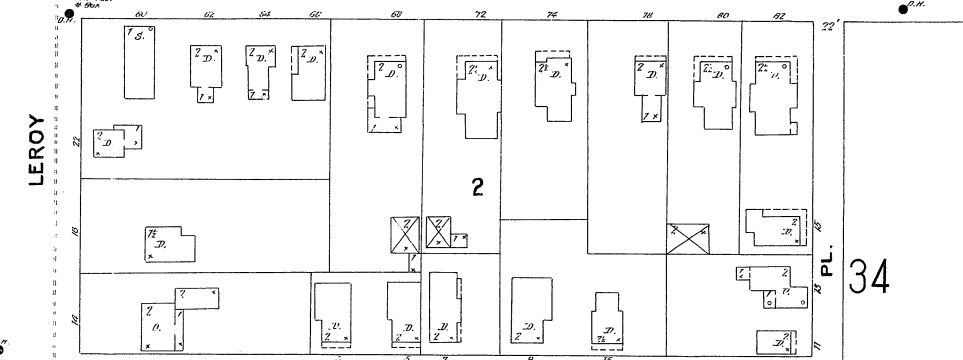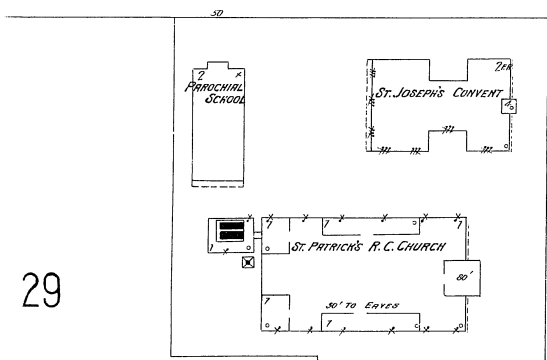

FRONT

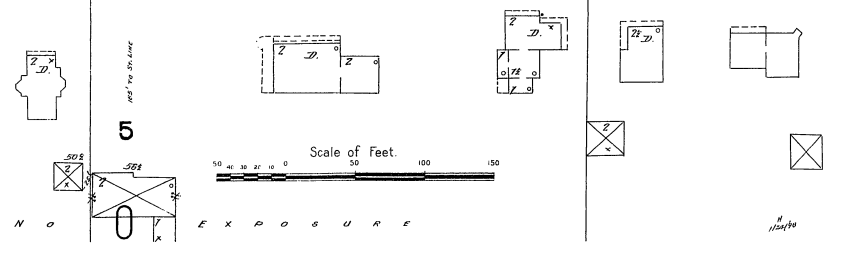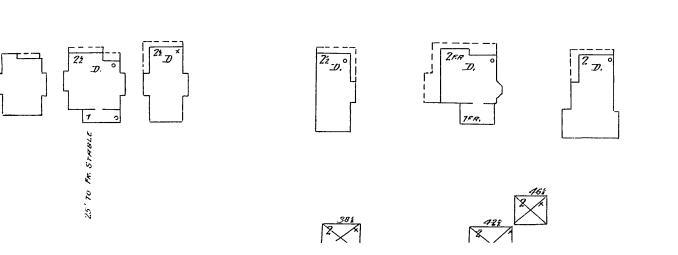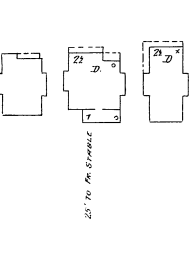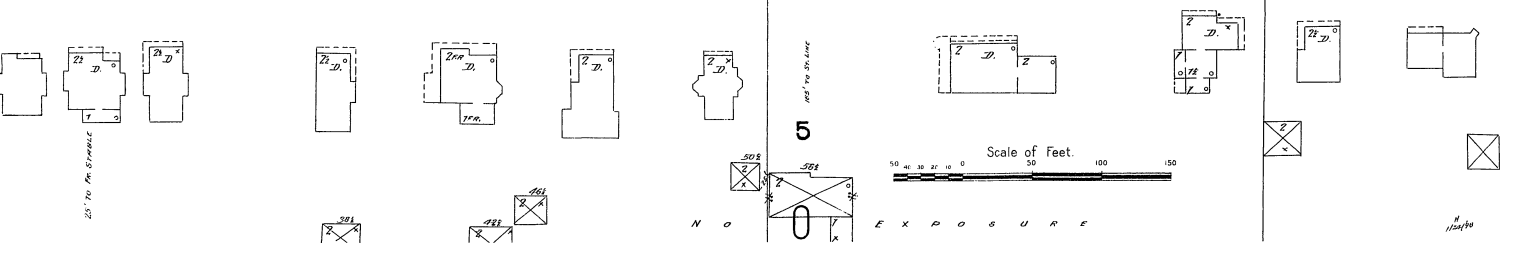

31

0

3

49

JOHNSON

BENNETT

LATHROP AV.

CHESTNUT

ST. JOHNS AV.

WALNUT

CHAPIN

32

 


48

7

8

MURRAY

29

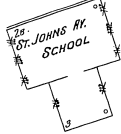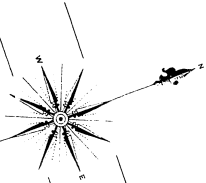

32


48

ARTHUR ST.

SEMINARY

33

49

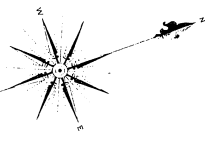

ST. JOHNS AV.

KING AV.

WALNUT

CHAPIN

MURRAY

CHESTNUT

4

10

 
31

LEROY

2


8

30



ST. JOHN  
BY  
**33**

**48**

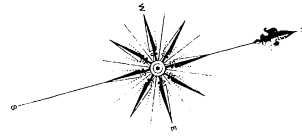

**ARTHUR**

TABERNACLE M. E. CHURCH  
35' x 60' ERECT

PARLOR CITY  
GLOVE & MITTEN CO.

**WALNUT**

**32**

SEMINARY AV.


 
**37**

MAIN

**CHAPIN**

**MURRAY**

**34**

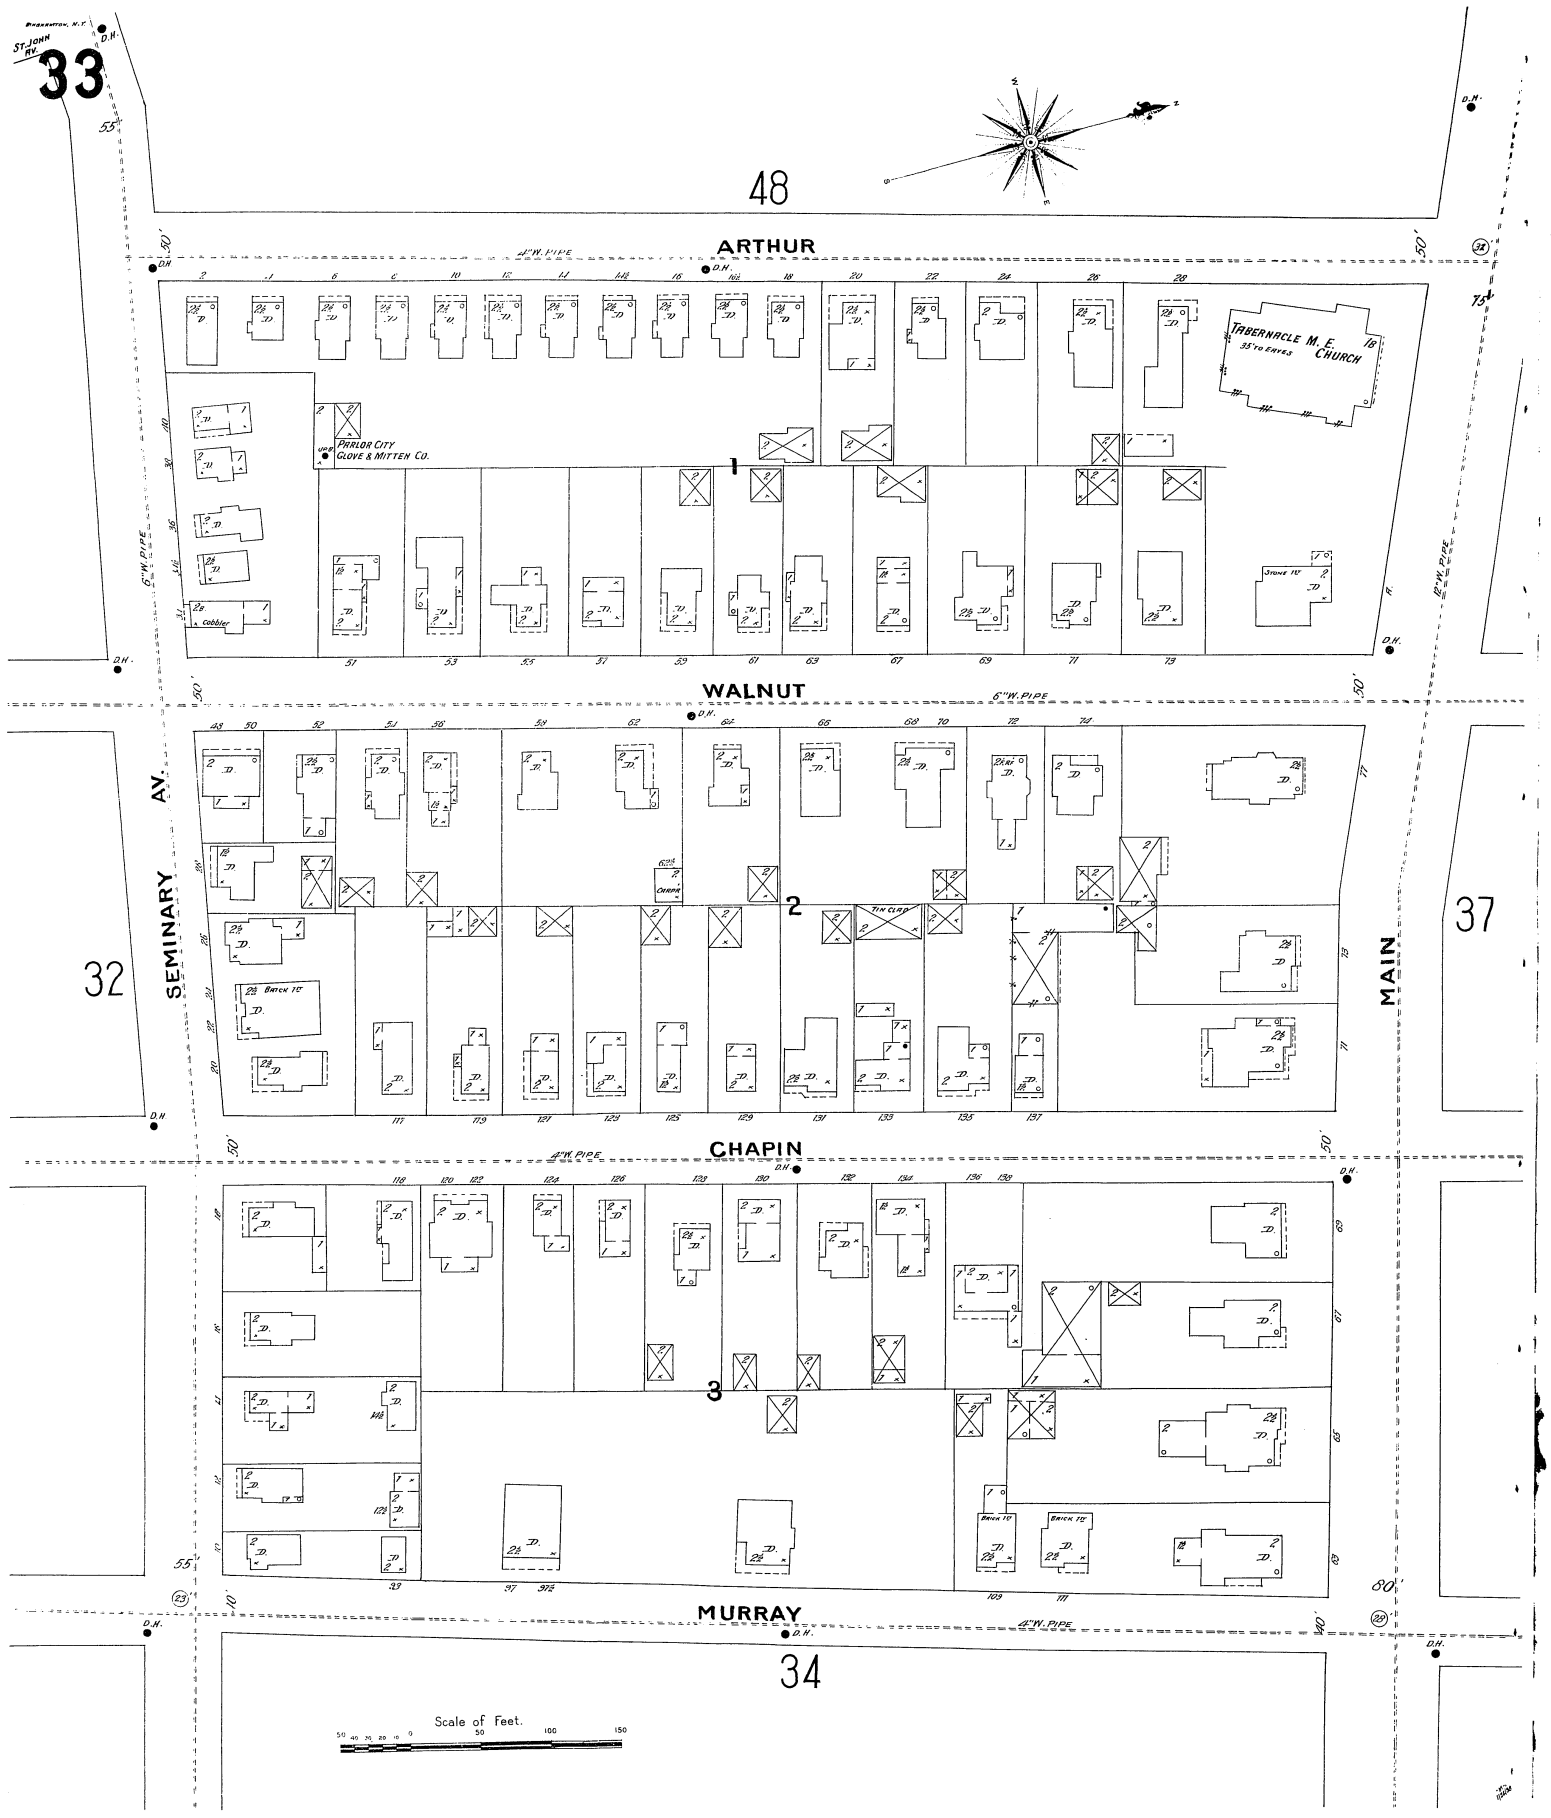

SEMINARY AV

CHapel

CONCERT HALL

LOCKWOODS LIVERY

OAK

30

35

MAIN

HIGH SCHOOL  
THE BRADLOW INDUSTRIAL SCHOOL of Arts


 
 
FRONT

EVANGEL CHURCH

5

RICHARD BLK



BRIDGE

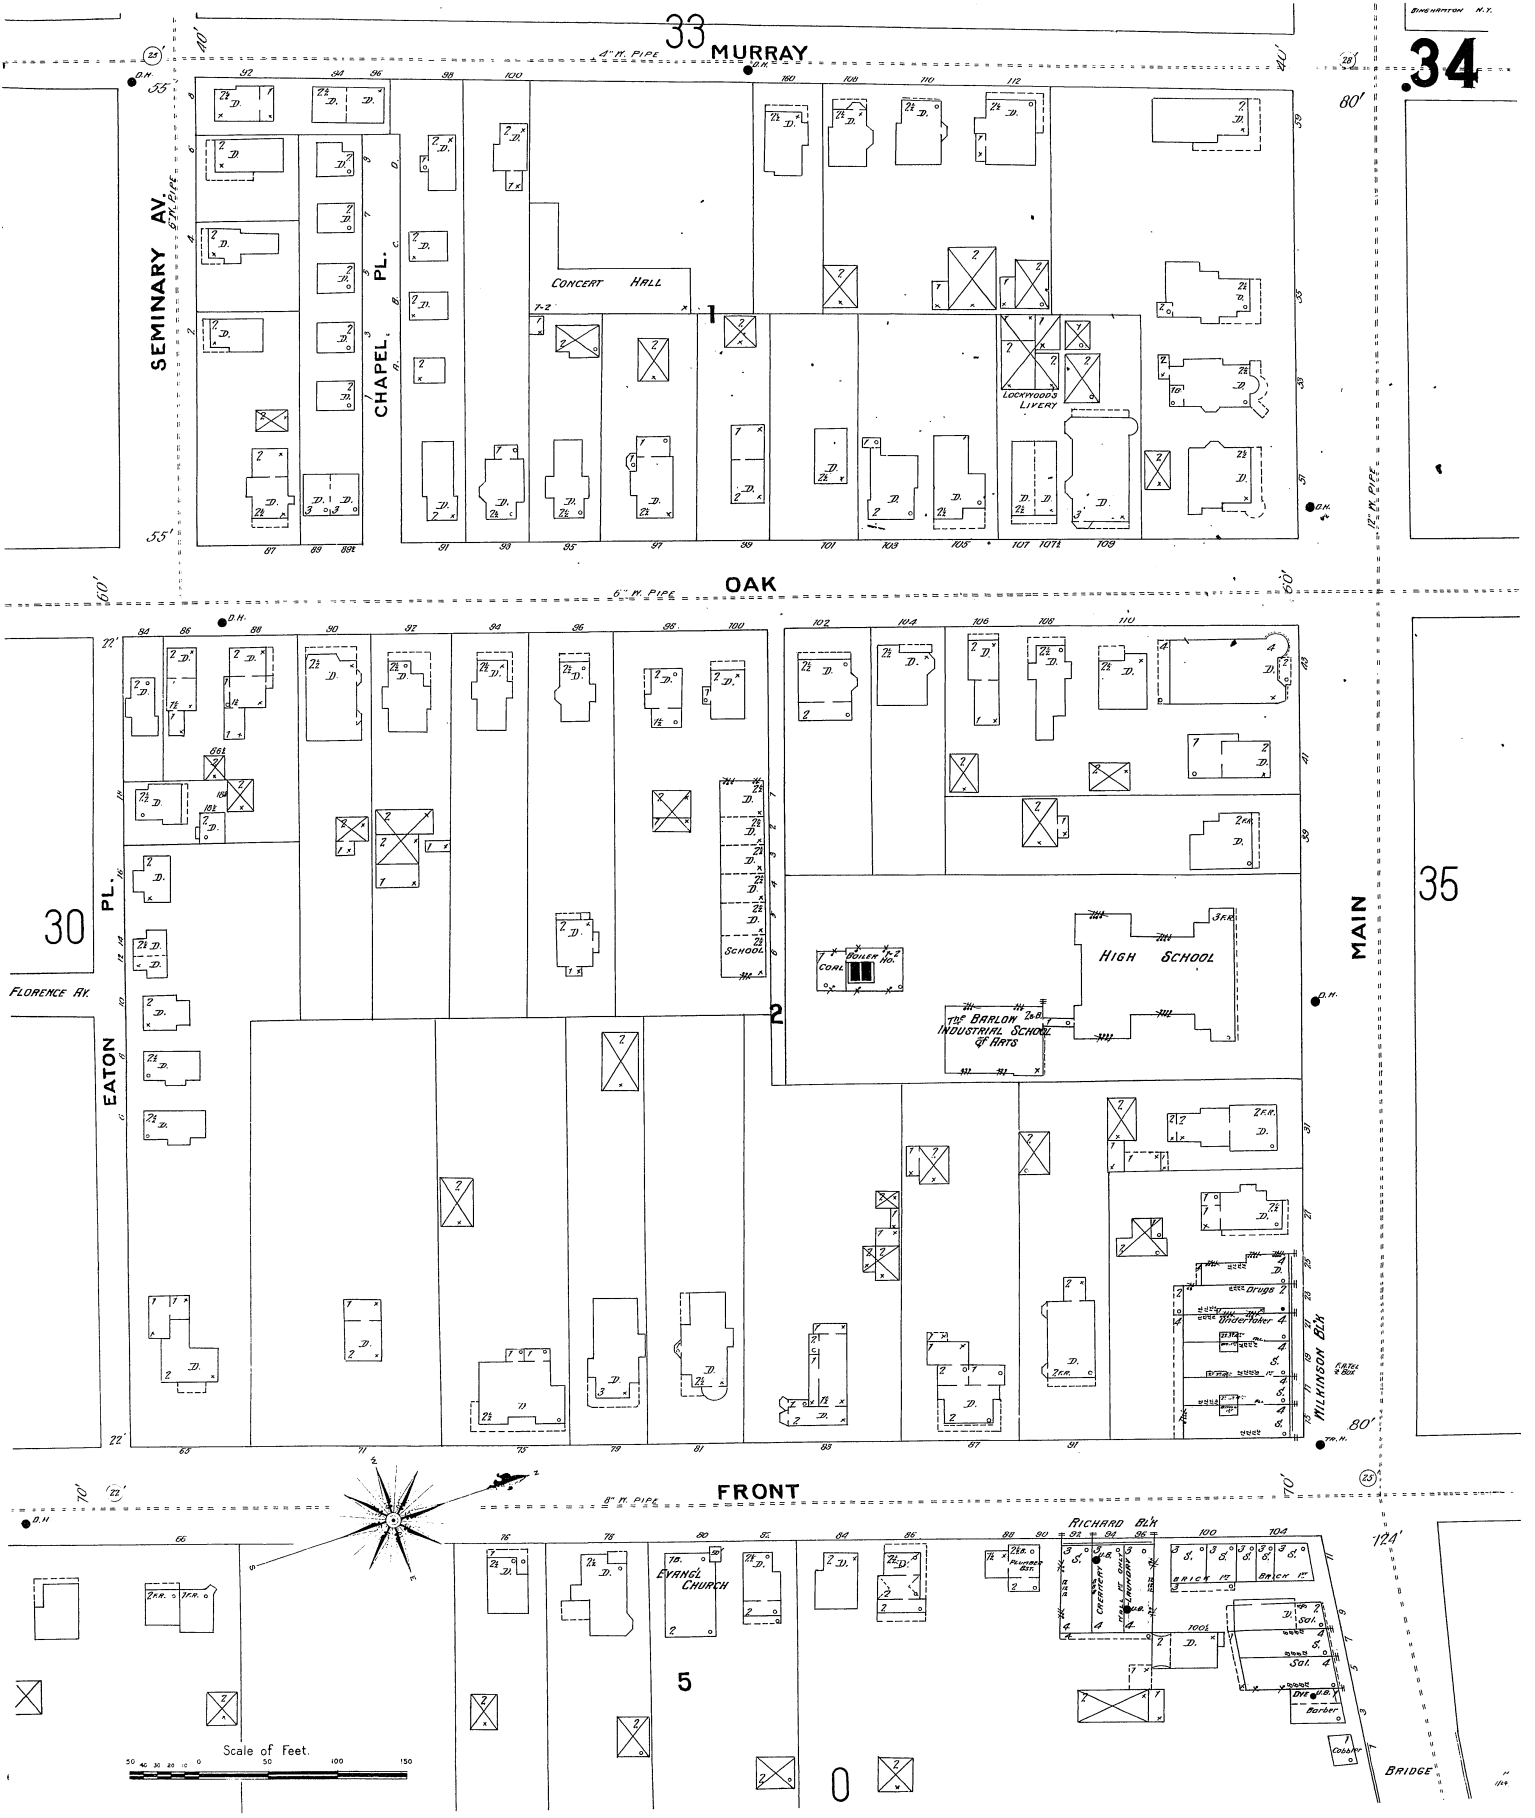



35

37



MURRAY

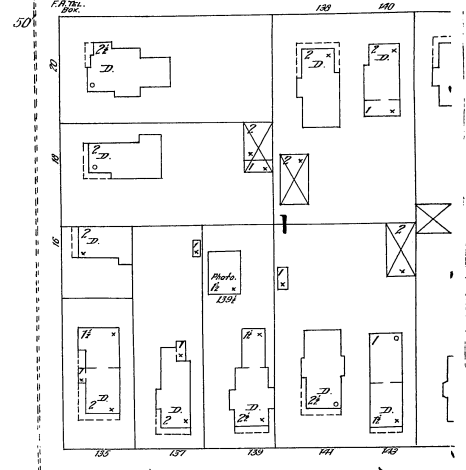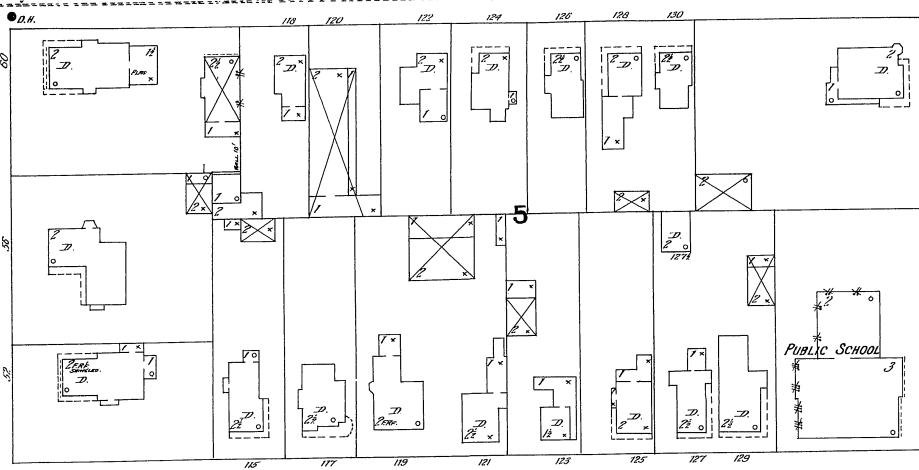

OAK

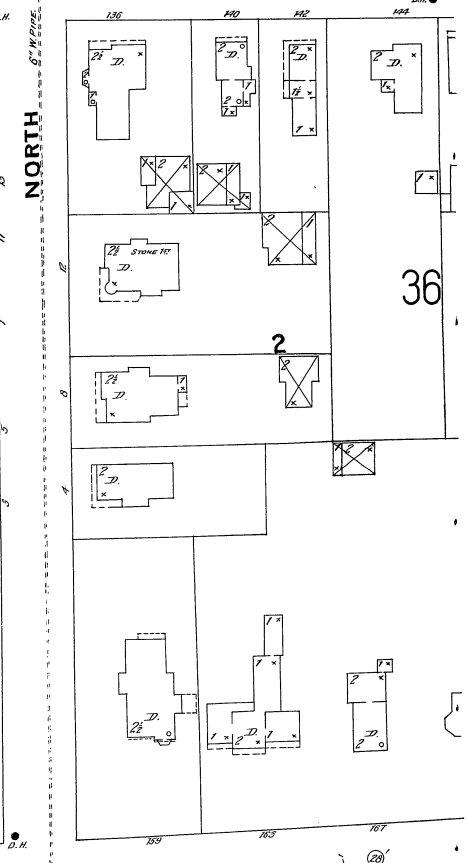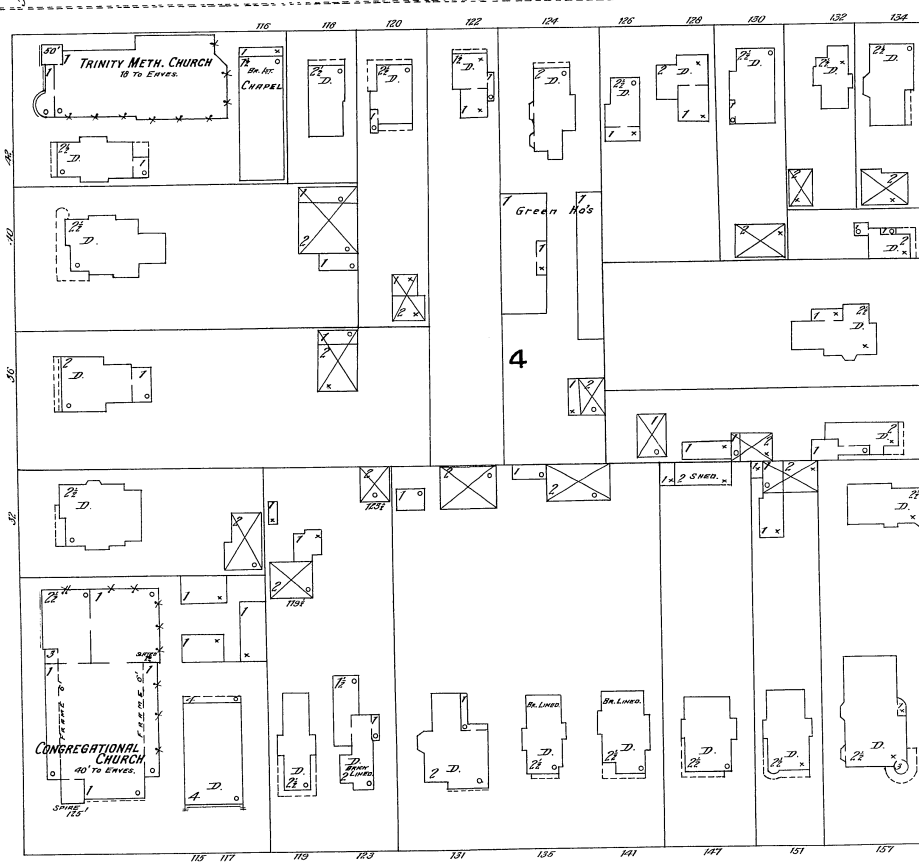

FRONT

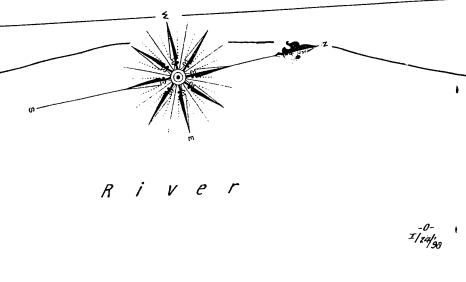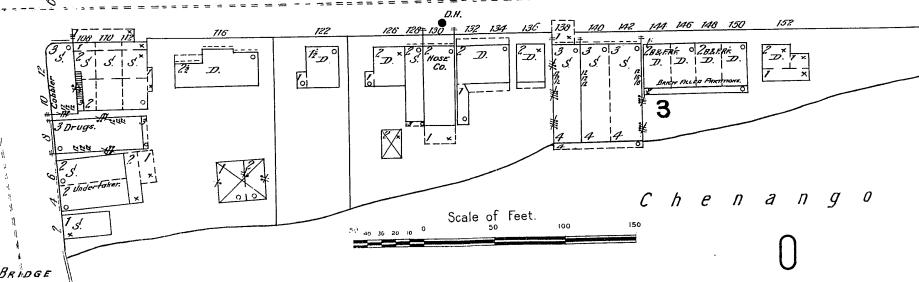

34

MAIN

36

Chenango River

Scale of Feet.



0

3/19/90



38

36



MURRAY

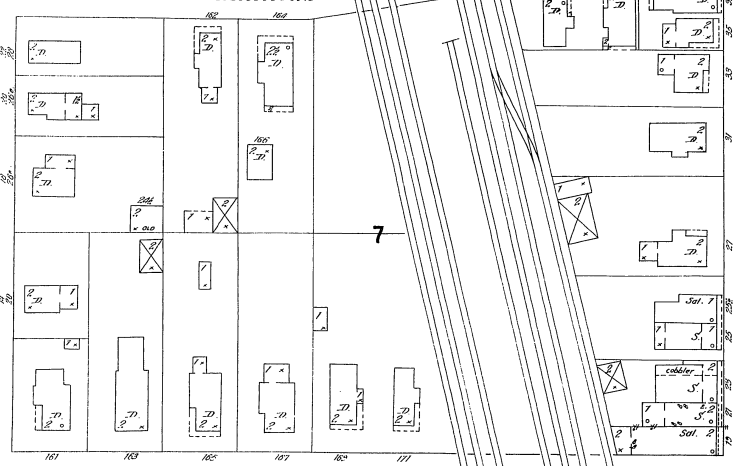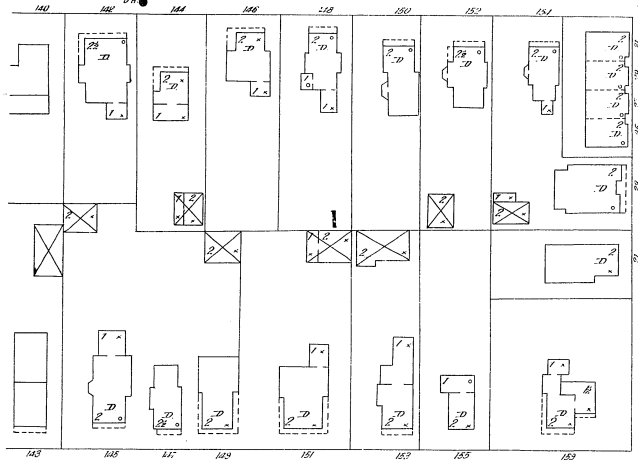



MAIDEN LANE

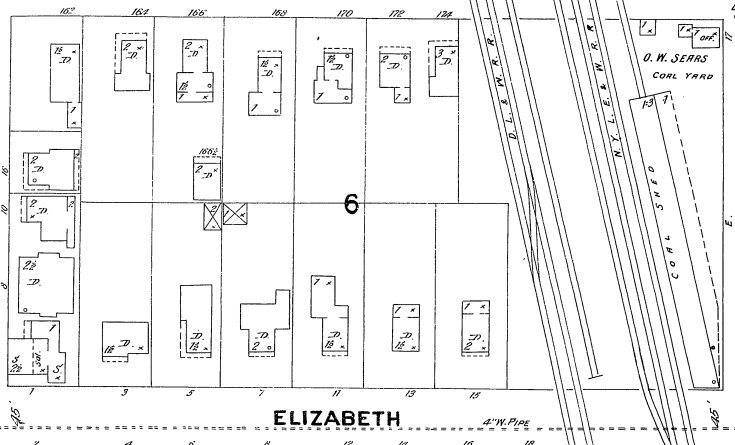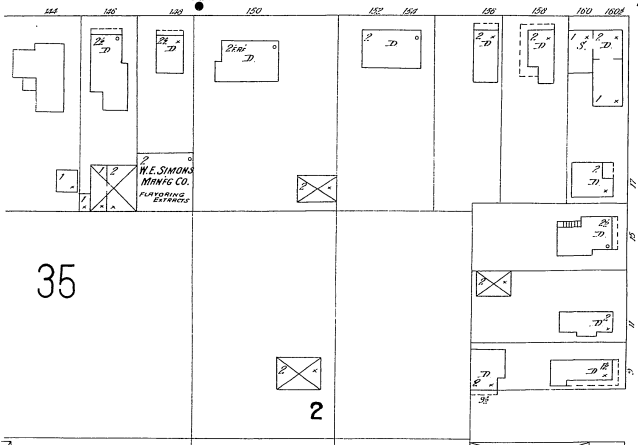

ELIZABETH

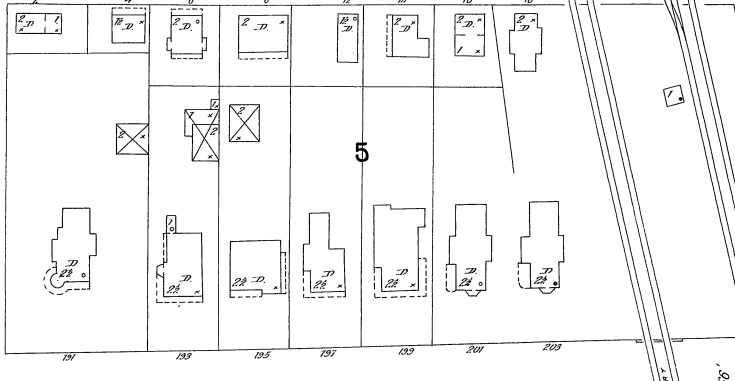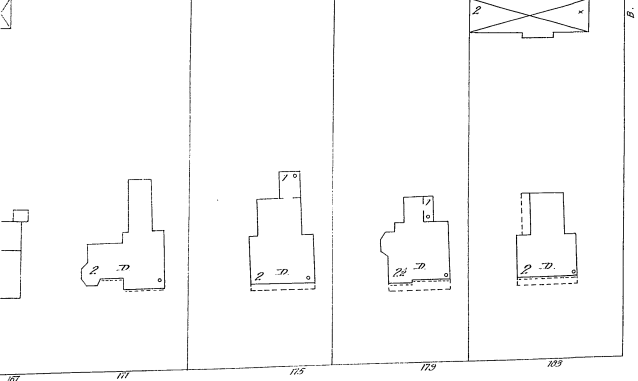


FRONT

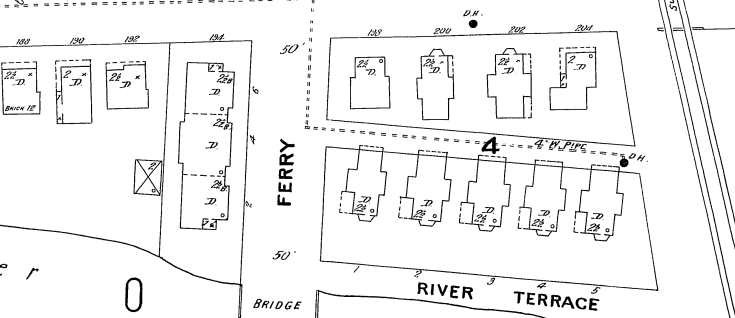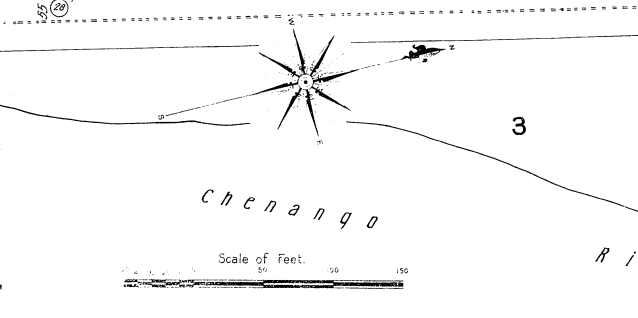

Chenango

River

 Scale of Feet.



FERRY

BRIDGE

RIVER TERRACE

CLINTON

40

42

0

7

6

5

3

35


2

0

37


46

MATHER

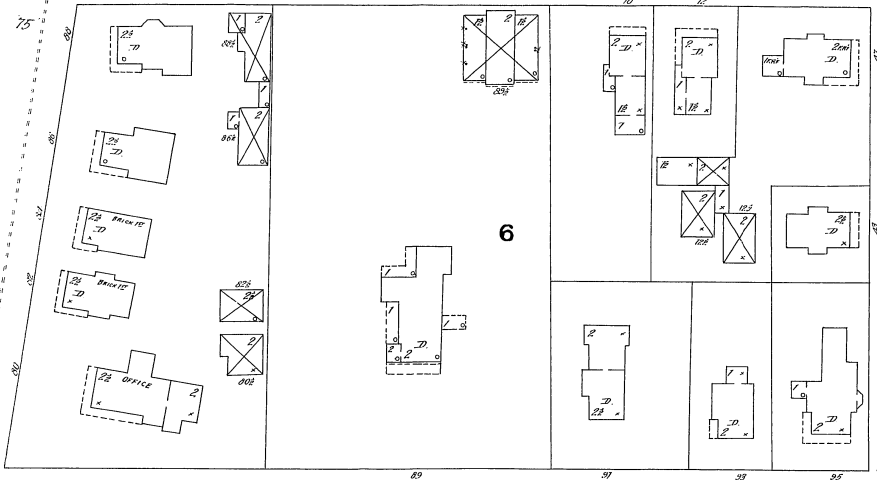


6

WALNUT

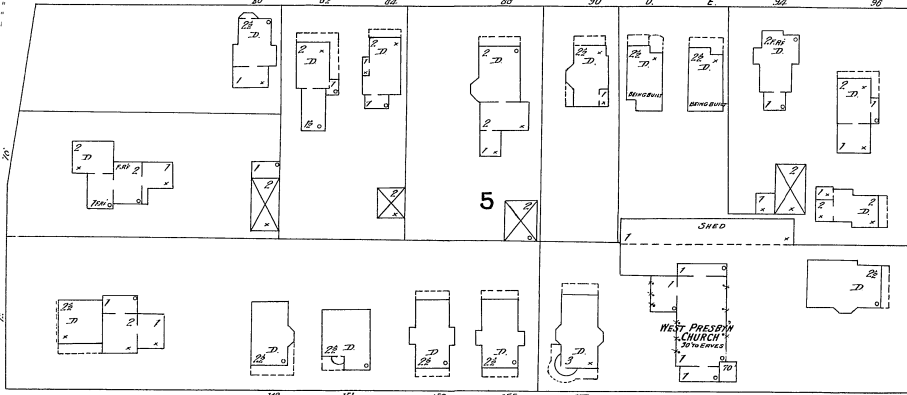

5

CHAPIN

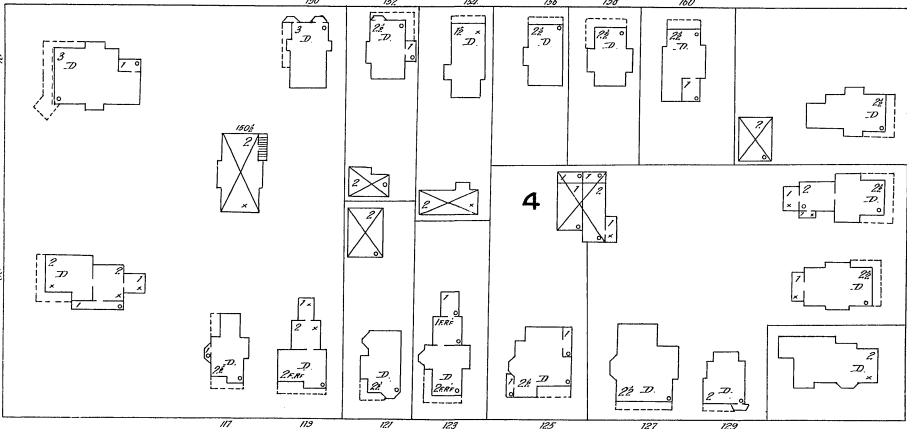


4


MURRAY




3

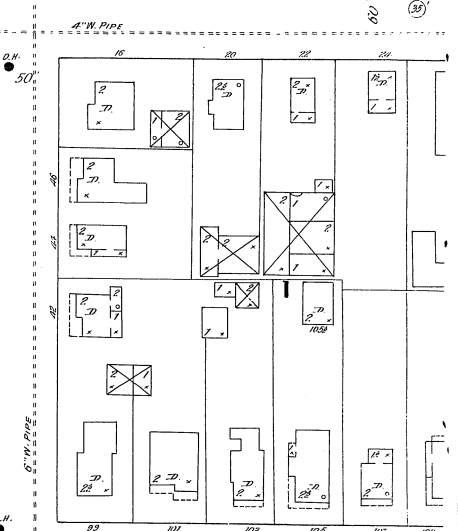


2

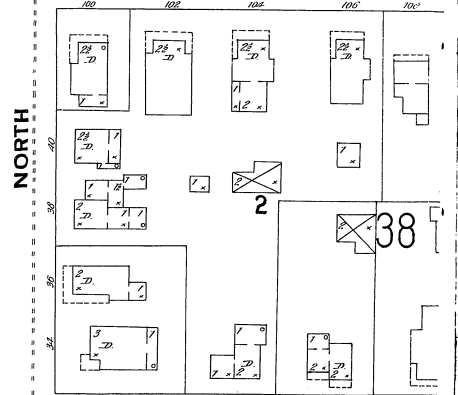

38

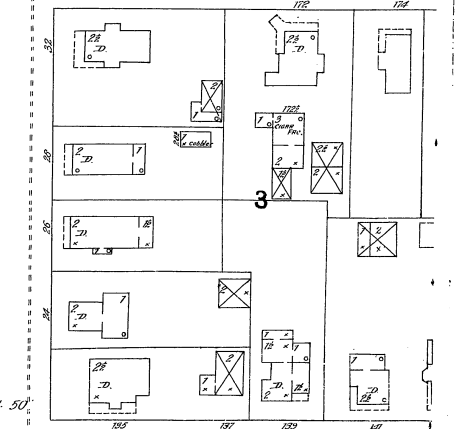

3

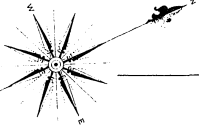


ARTHUR ST.


MAIN

NORTH

 Scale of Feet.



35

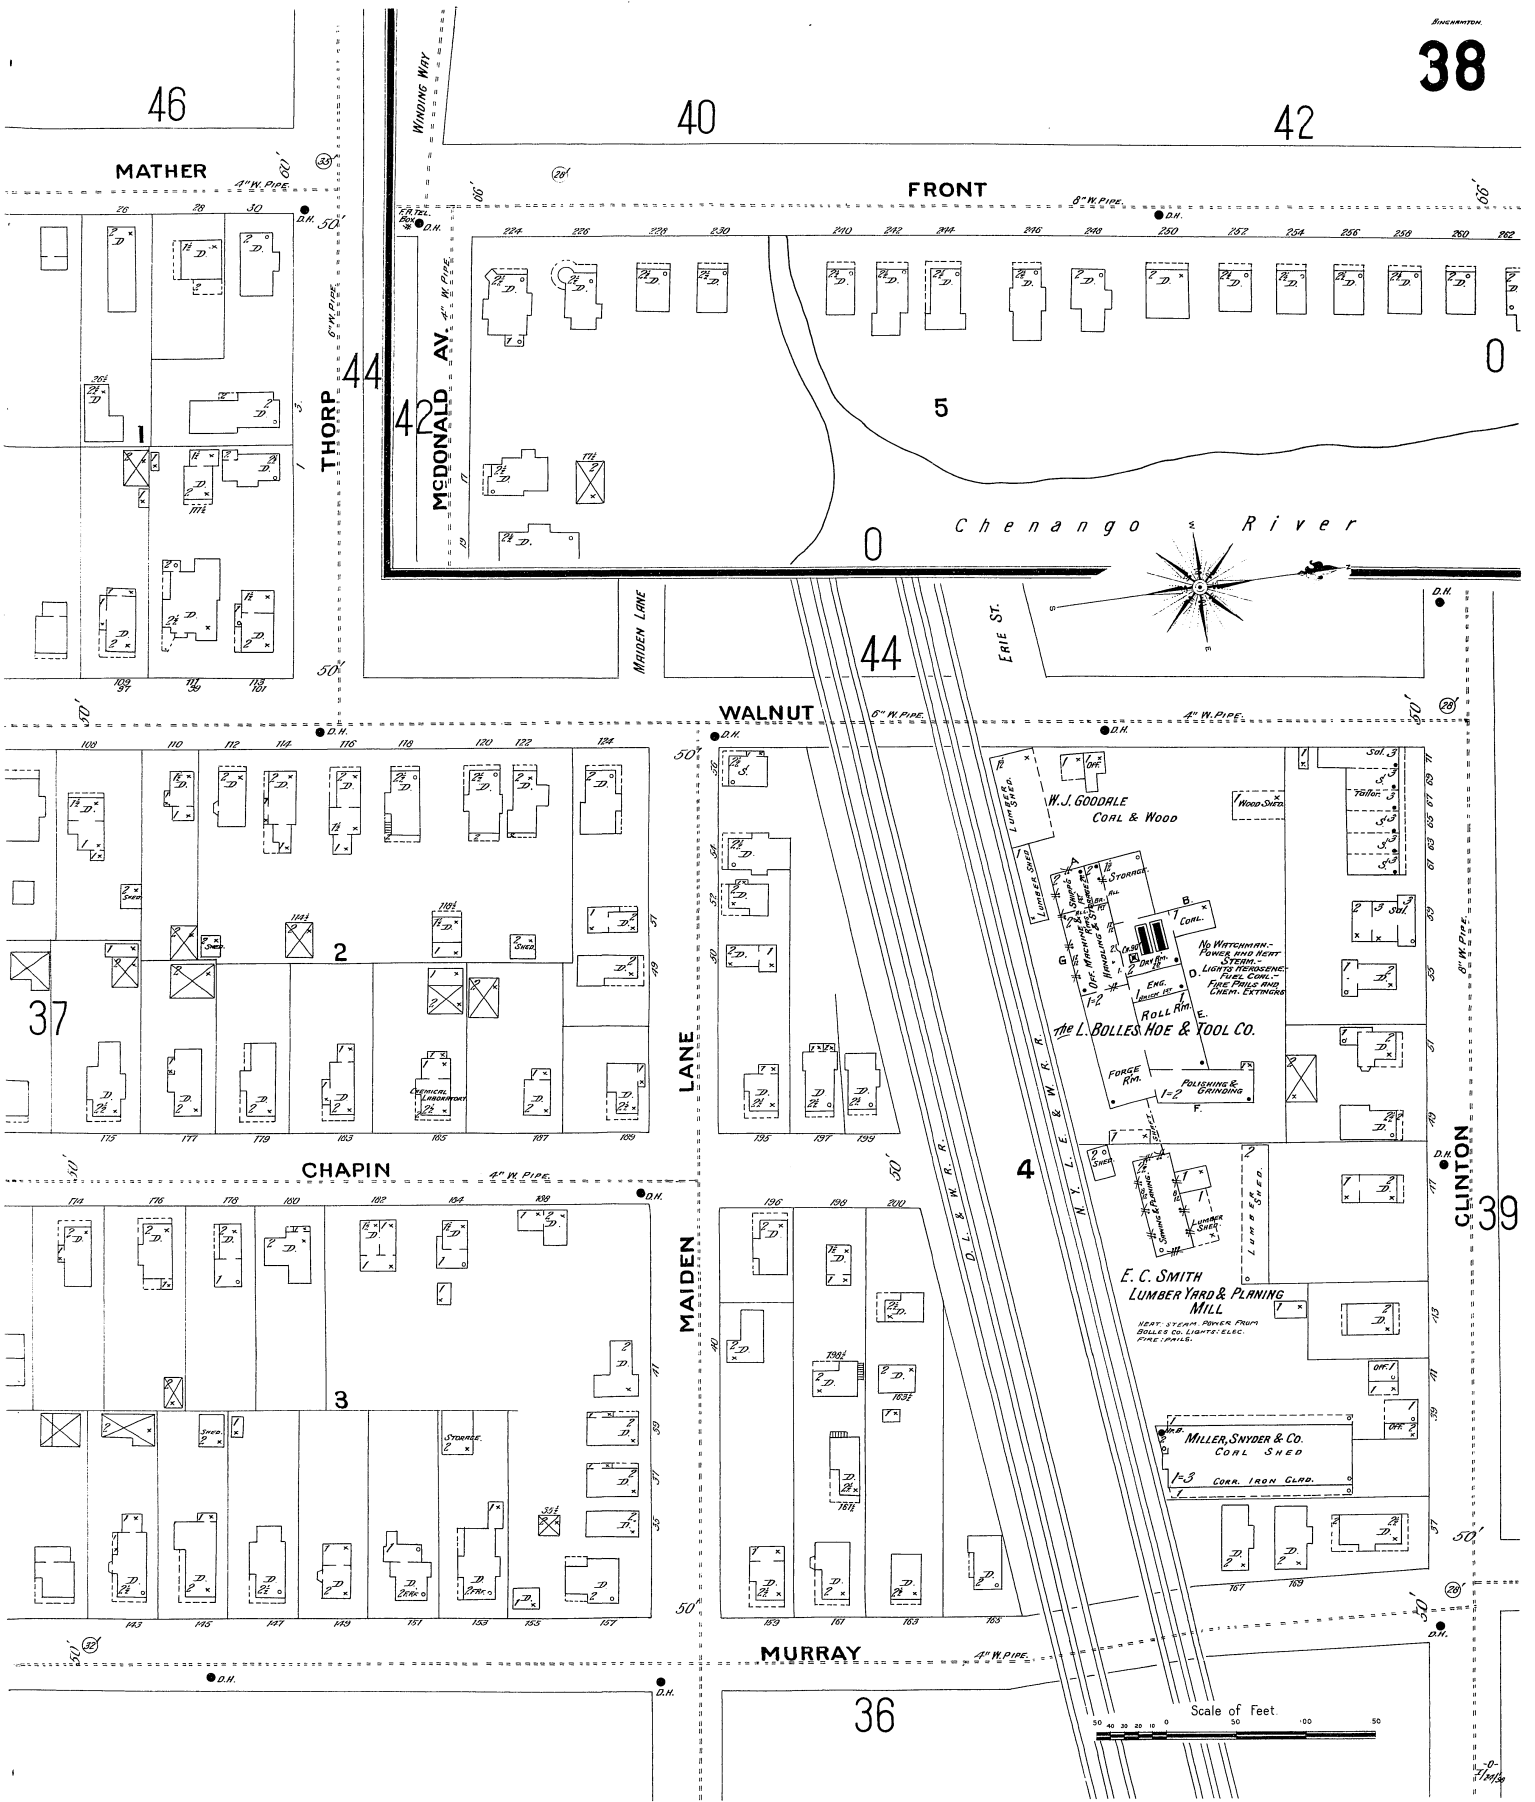

46

40

42

MATHER

FRONT

THORP

MCDONALD AV.

5

Chenango River

44

WALNUT

37

LANE

W.J. GOODALE  
Coal & Wood

The L. BOLLES HOE & TOOL CO.

E.C. SMITH  
LUMBER YARD & PLANING  
MILL

MILLER, SNYDER & CO.  
COAL SHED

CLINTON

39

CHAPIN

MAIDEN

3

MURRAY

36

Scale of Feet.




39

ELM ST.

41

LYDIA

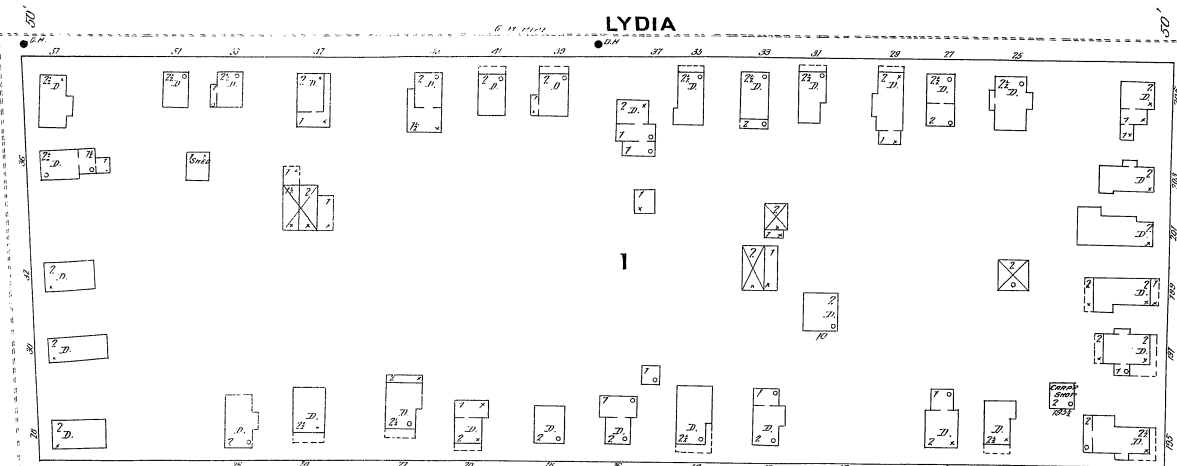

MEADOW


54

MYCATT



2

MURRAY

40

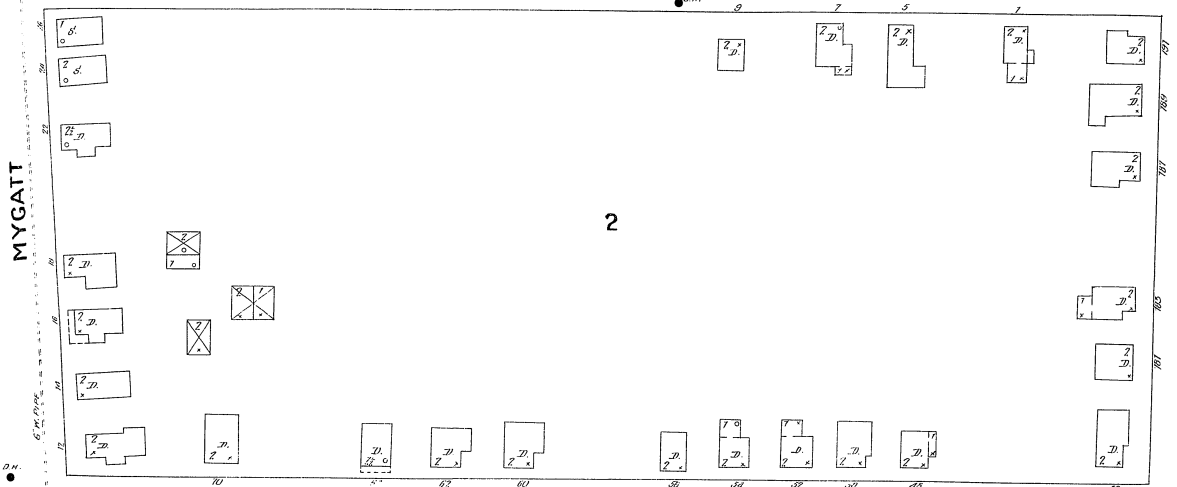

DICKINSON

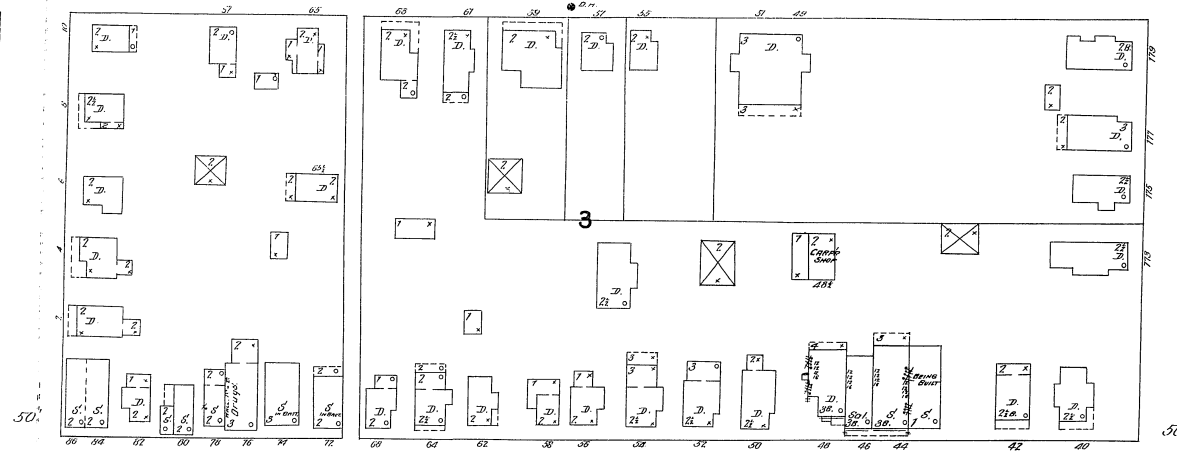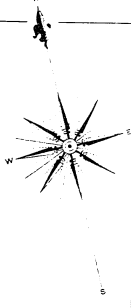


CLINTON

44






MELNUT ST.

 Scale of Feet.



38

MURRAY ST.

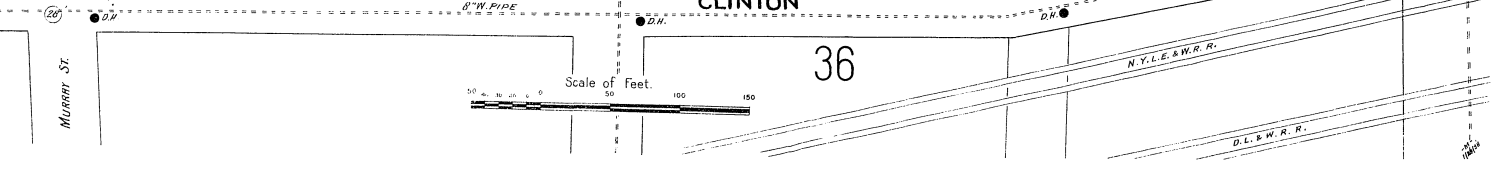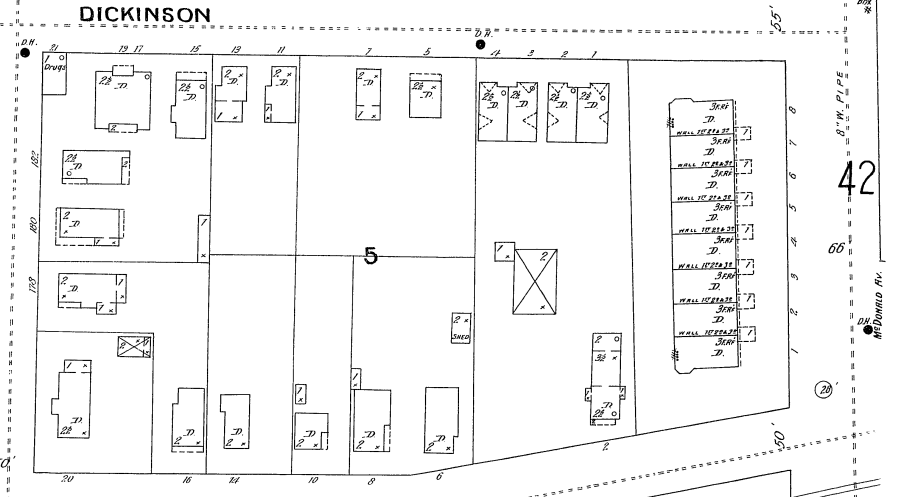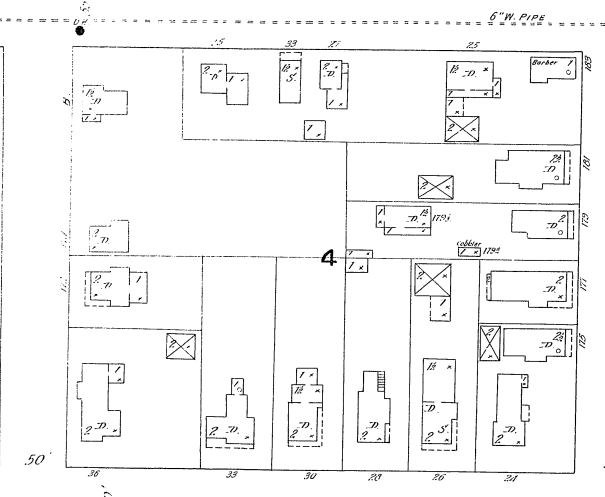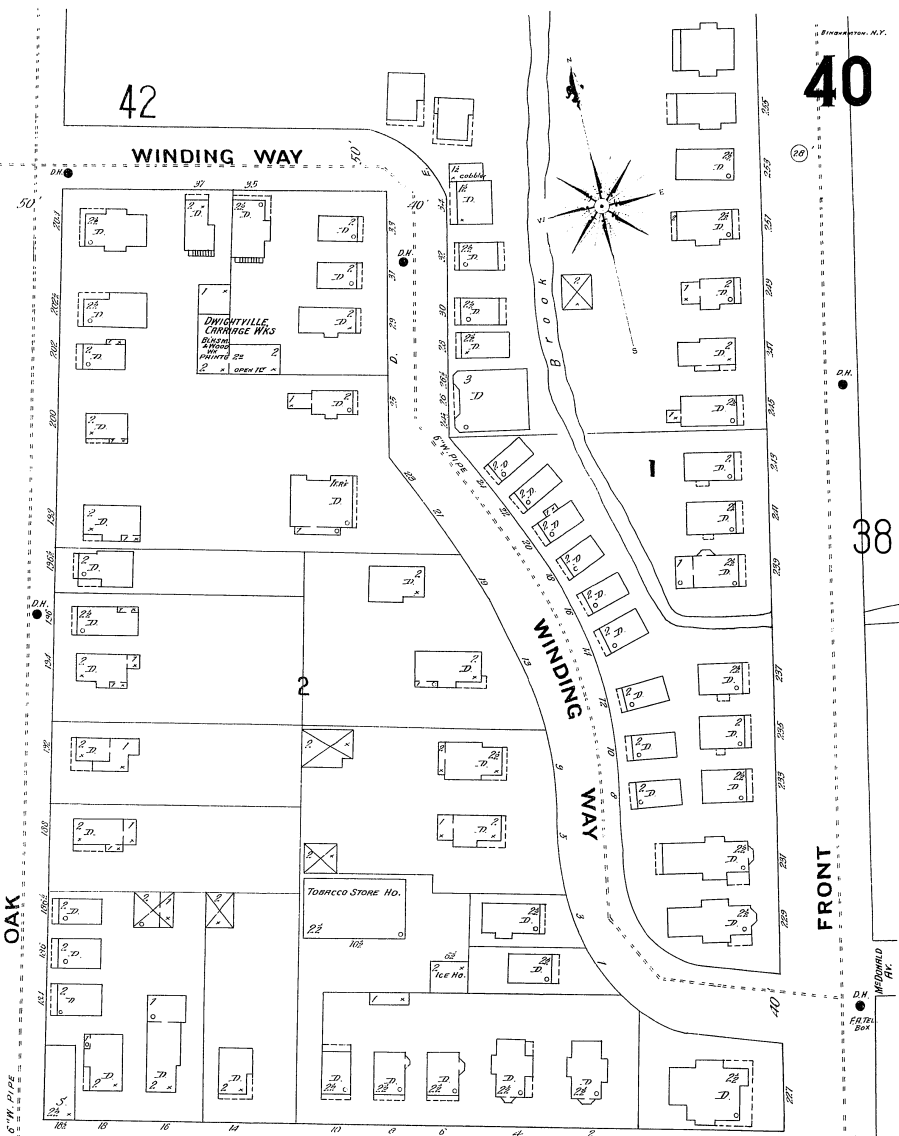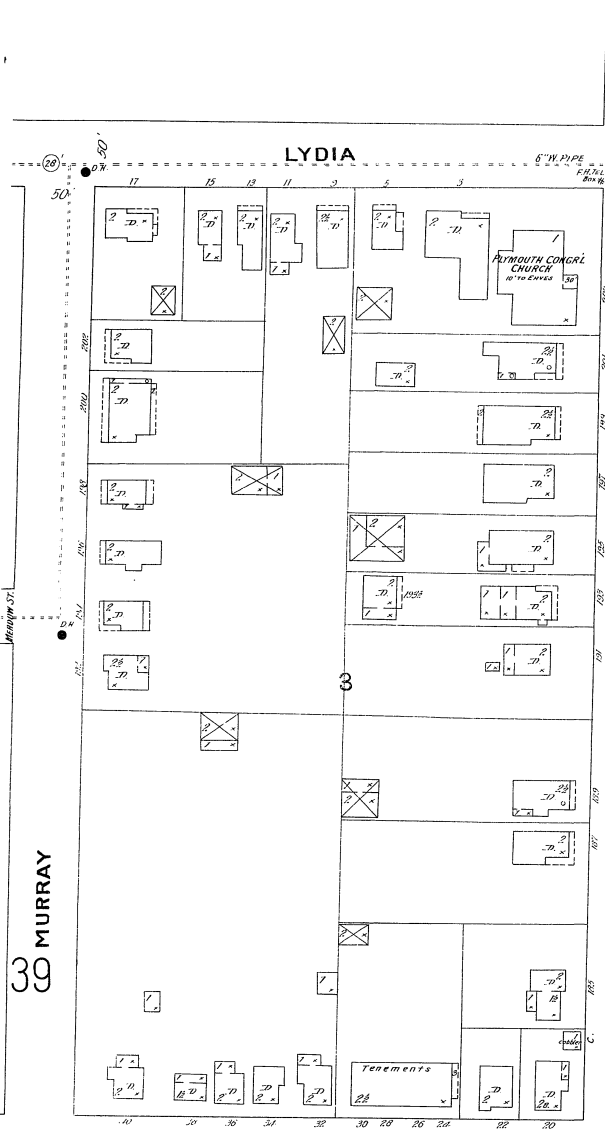

42

40

39 MURRAY

OAK

FRONT

DICKINSON

42

CLINTON


36

Scale of Feet. 0 50 100 150

N.Y.C. & W.R.R.

D.L.E.W.R.R.

41

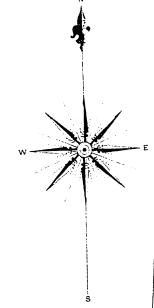

C E M E T E R Y

 


0


42

54

39




MURRAY ST.

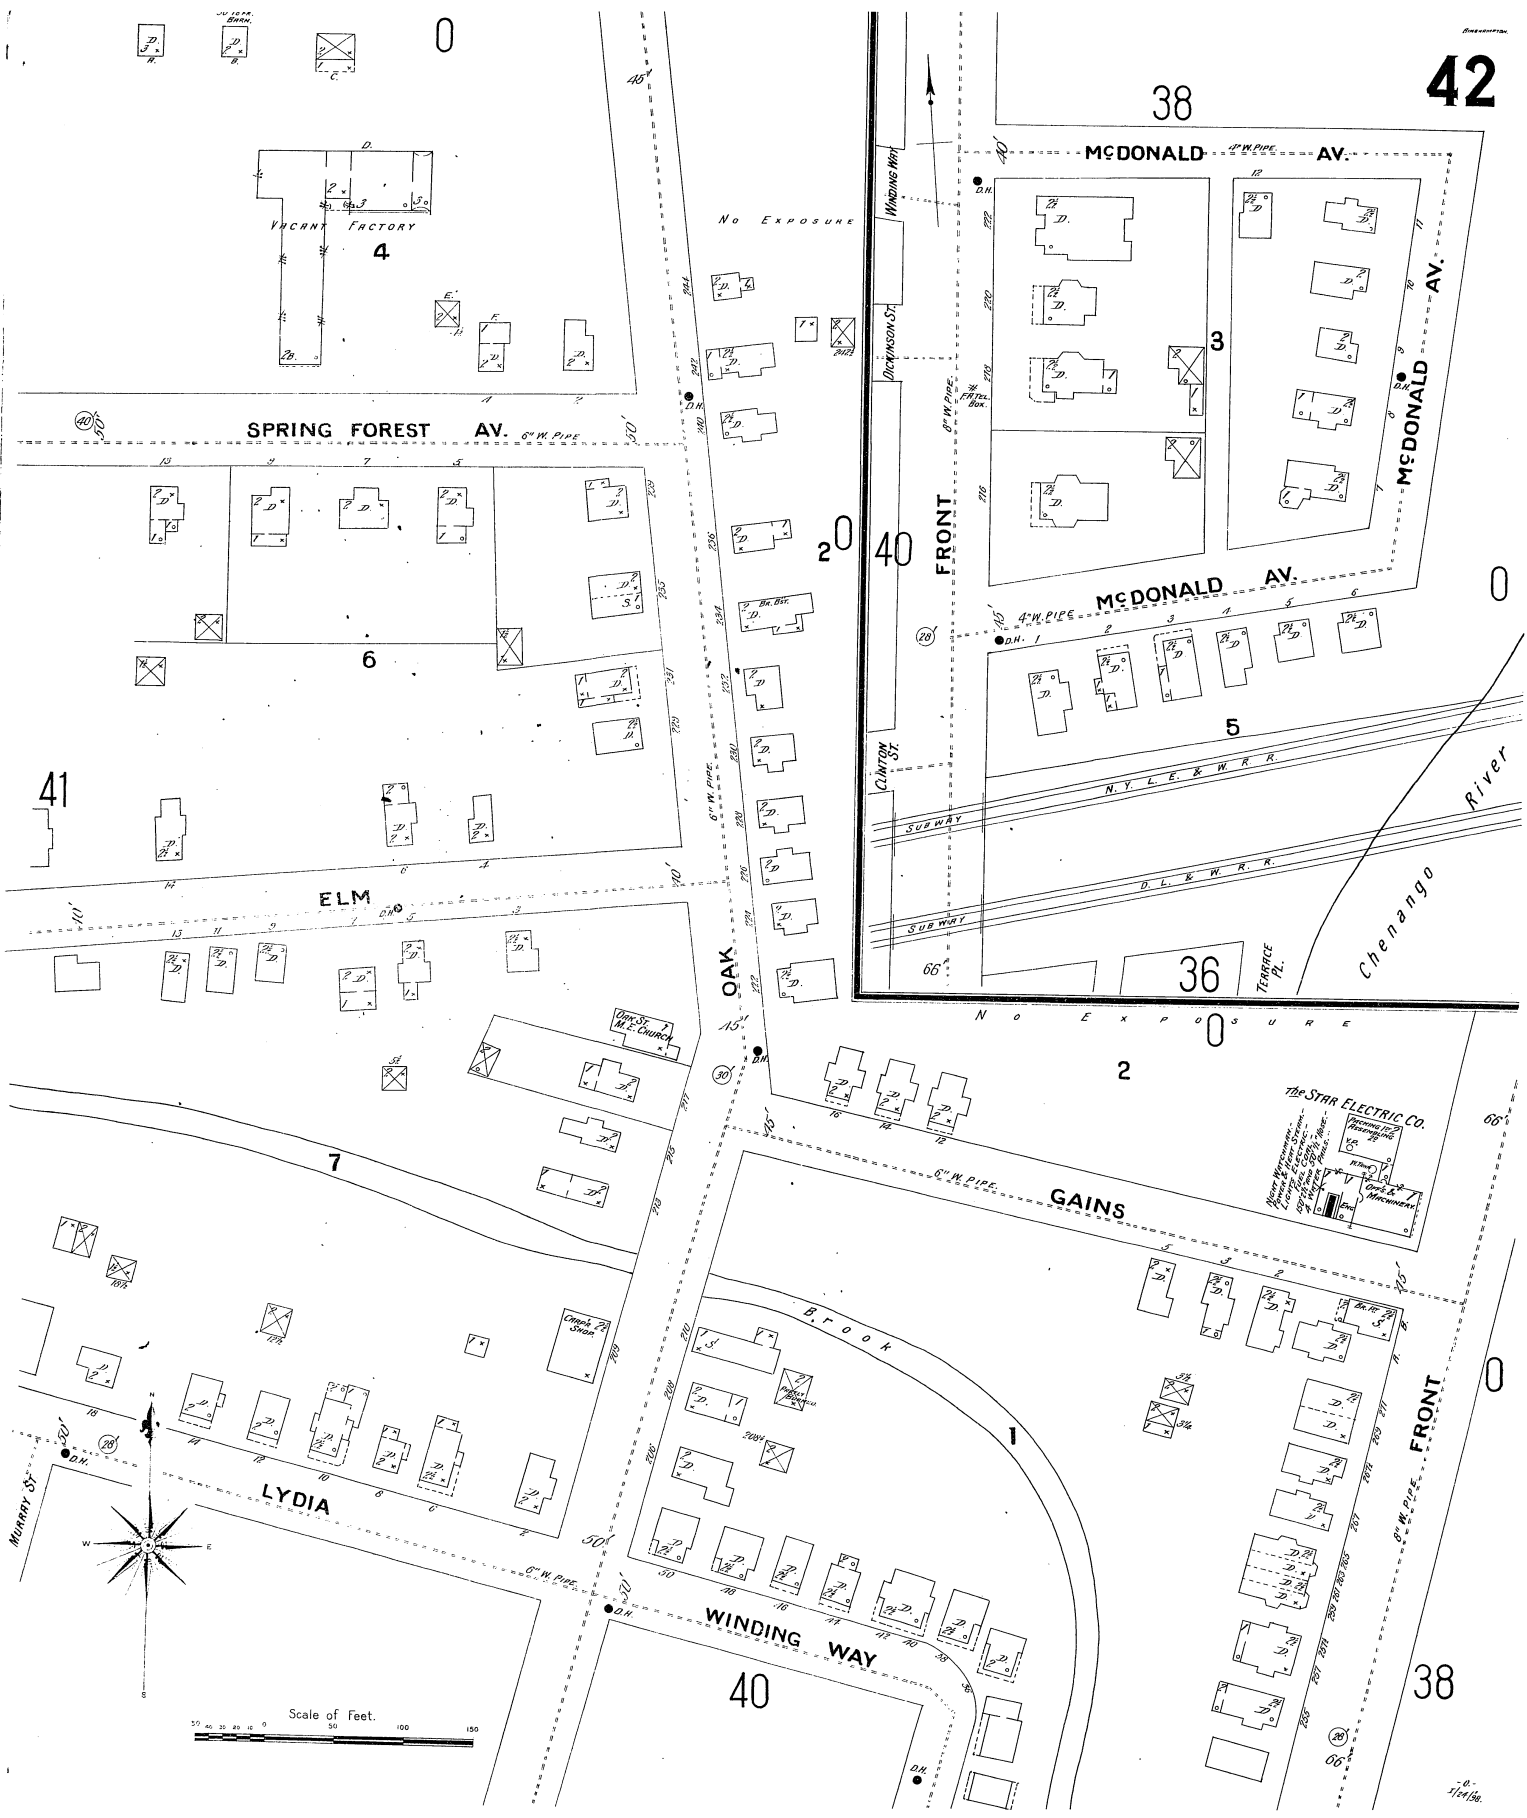

Scale of Feet.  
0 25 50 75 100 125 150

-8-  
1/4/46

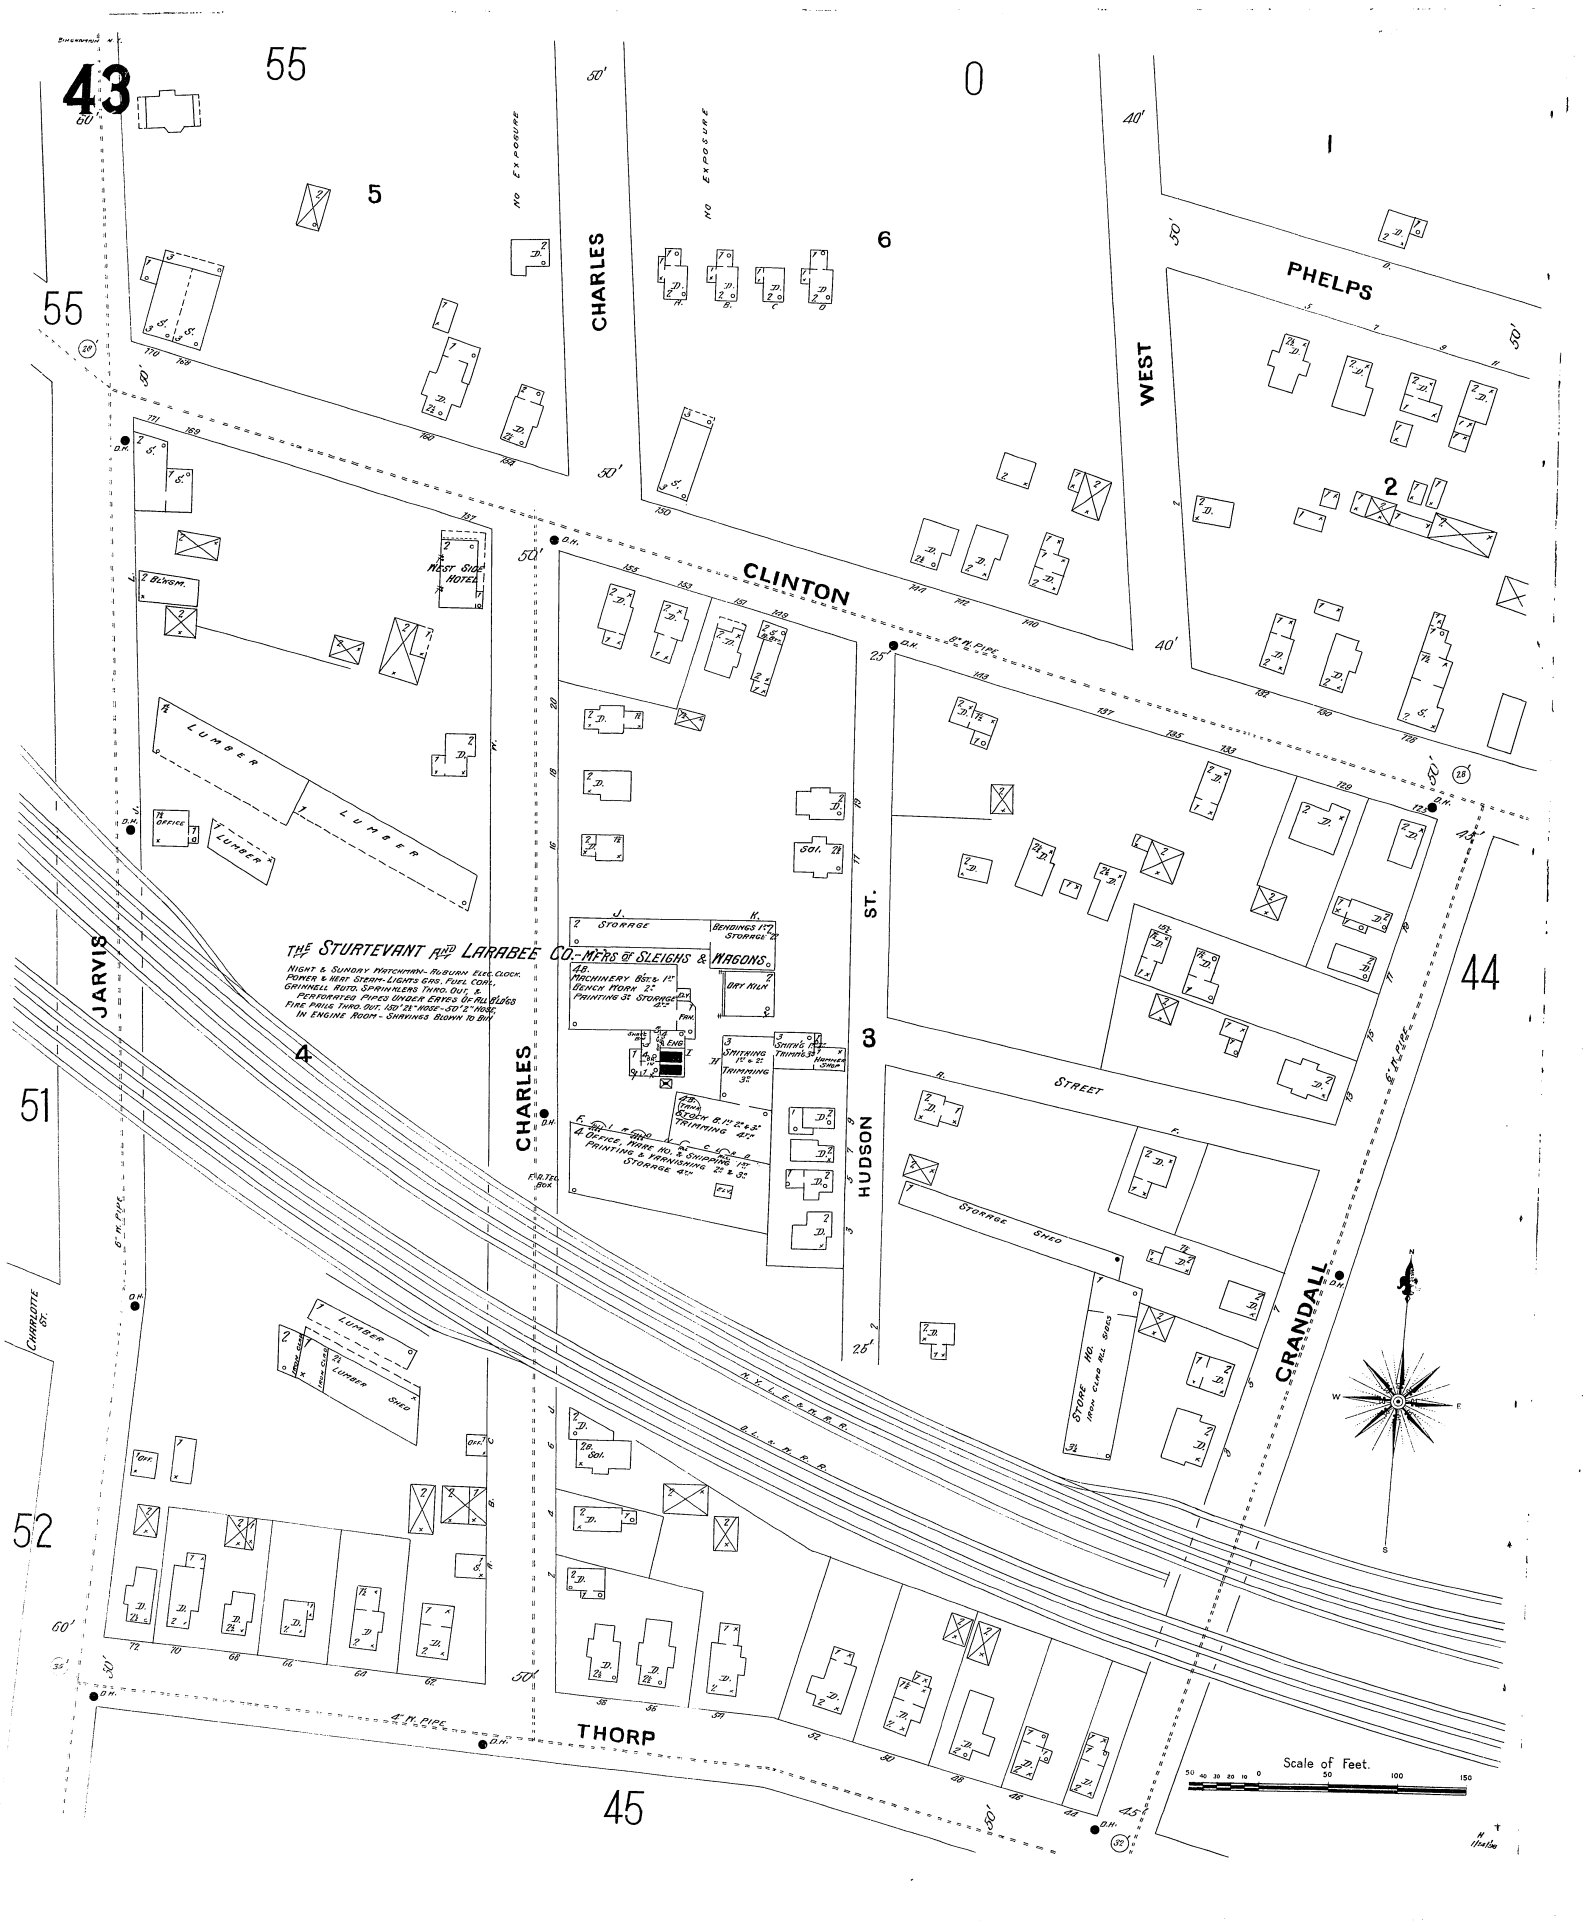

43

55

0

55

5

6

PHELPS

2

CLINTON

44

**THE STURTEVANT AND LARABEE CO. - MFRS OF SLEIGHS & WAGONS.**  
 NIGHT & SUNDAY MATCHMEN - RUBBER EEL COOK  
 PUMPS & HEAT STEAM LIGHTS ENG. FUEL CONT.  
 GRINDING ROPS, SPRING ROPS, TUNGS, OIL, &  
 FERRUGINATED PUMPS UNDER EYES OF ALL SLEIGHS  
 FINE PAINTS, TUNGS, OIL, 1 1/2" HOSE - 50' & 75' HOSE  
 IN ENGINE ROOM - SHIPPERS BURN TO BUY

CHARLES

3

HUDSON

STREET

 

CRANDALL



51

52


THORP

45

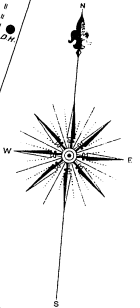

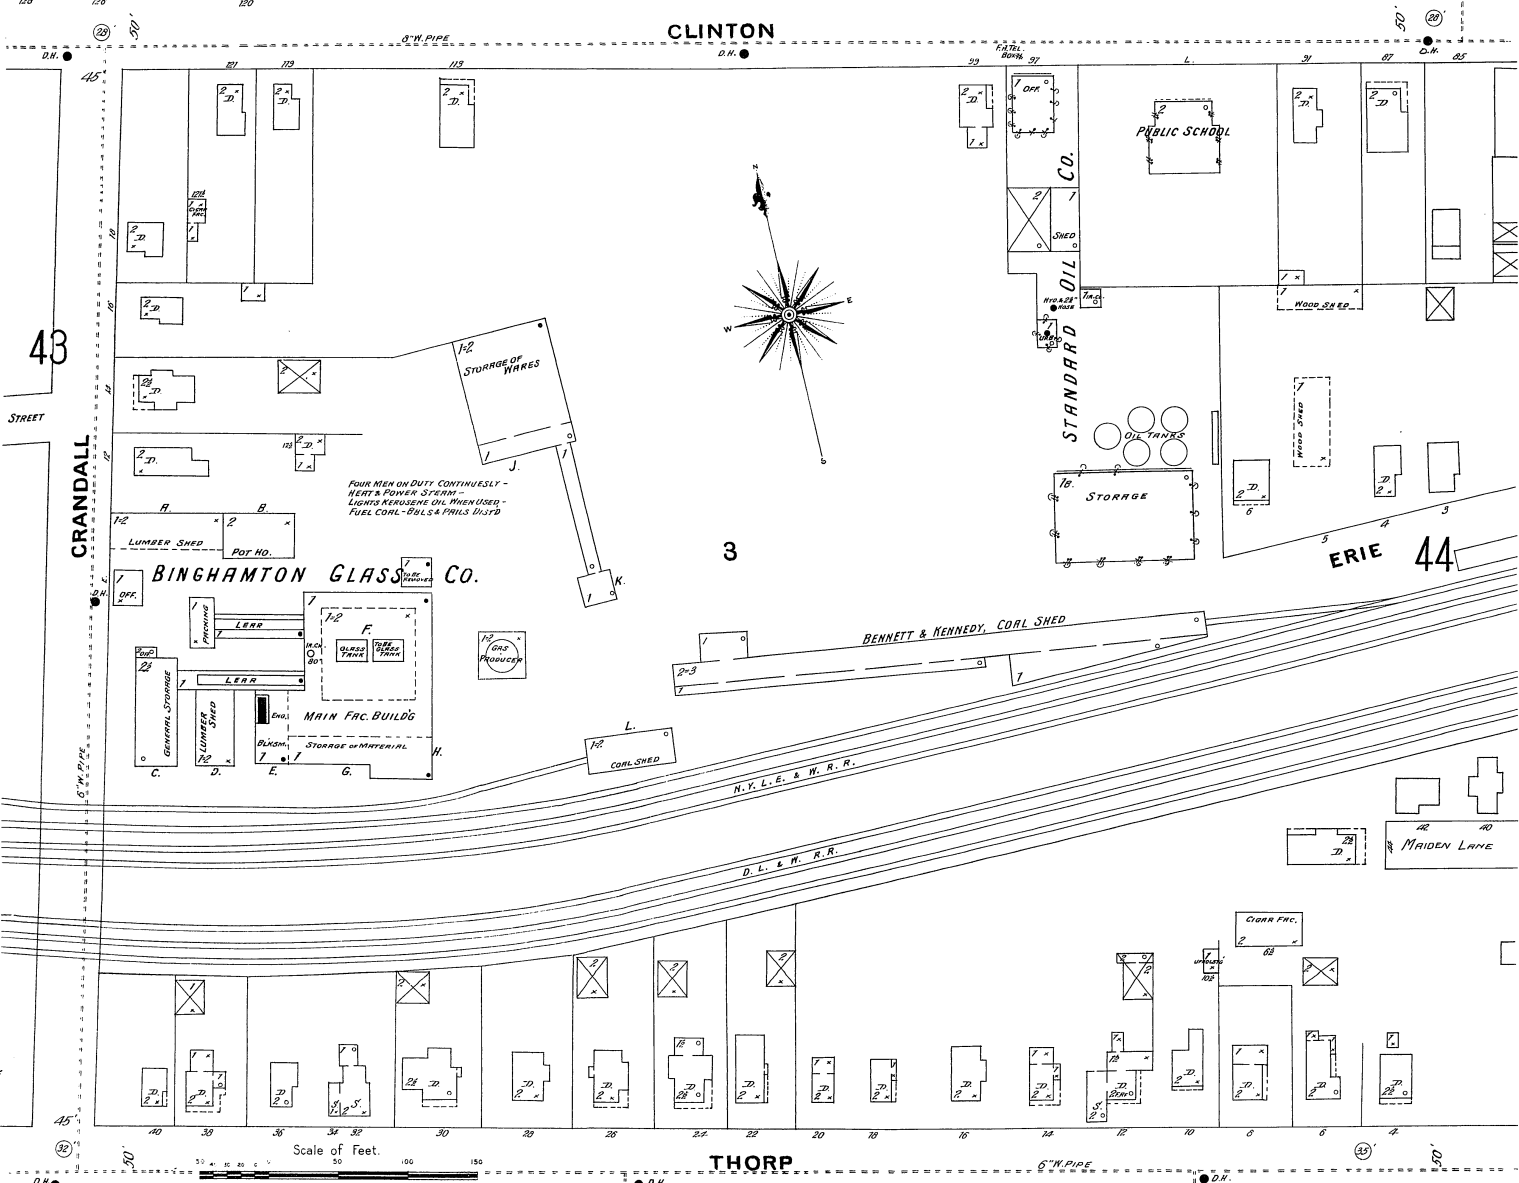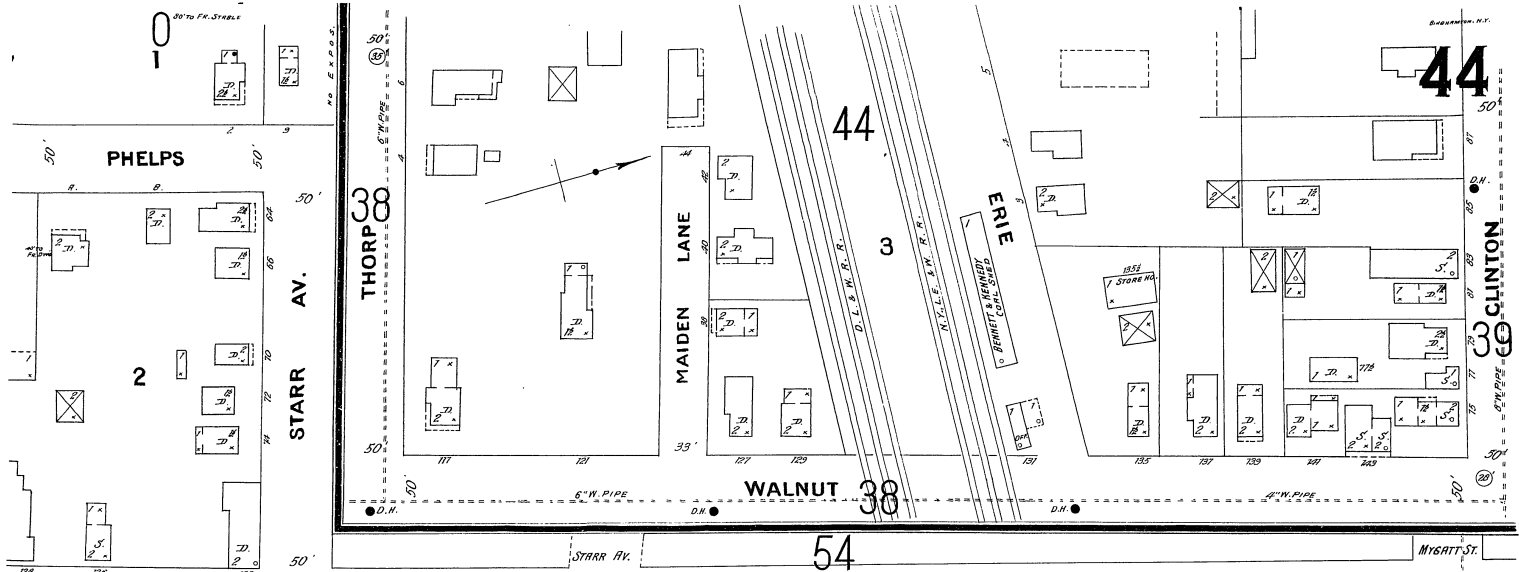

45

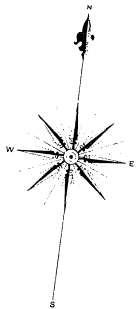

43

THORP

52

JARVIS

CRANDALL

46

52

CLARK

CATHERINE ST.

50

GARY ST.

MAIN


 
CEDAR

47

3


CHESTNUT

48

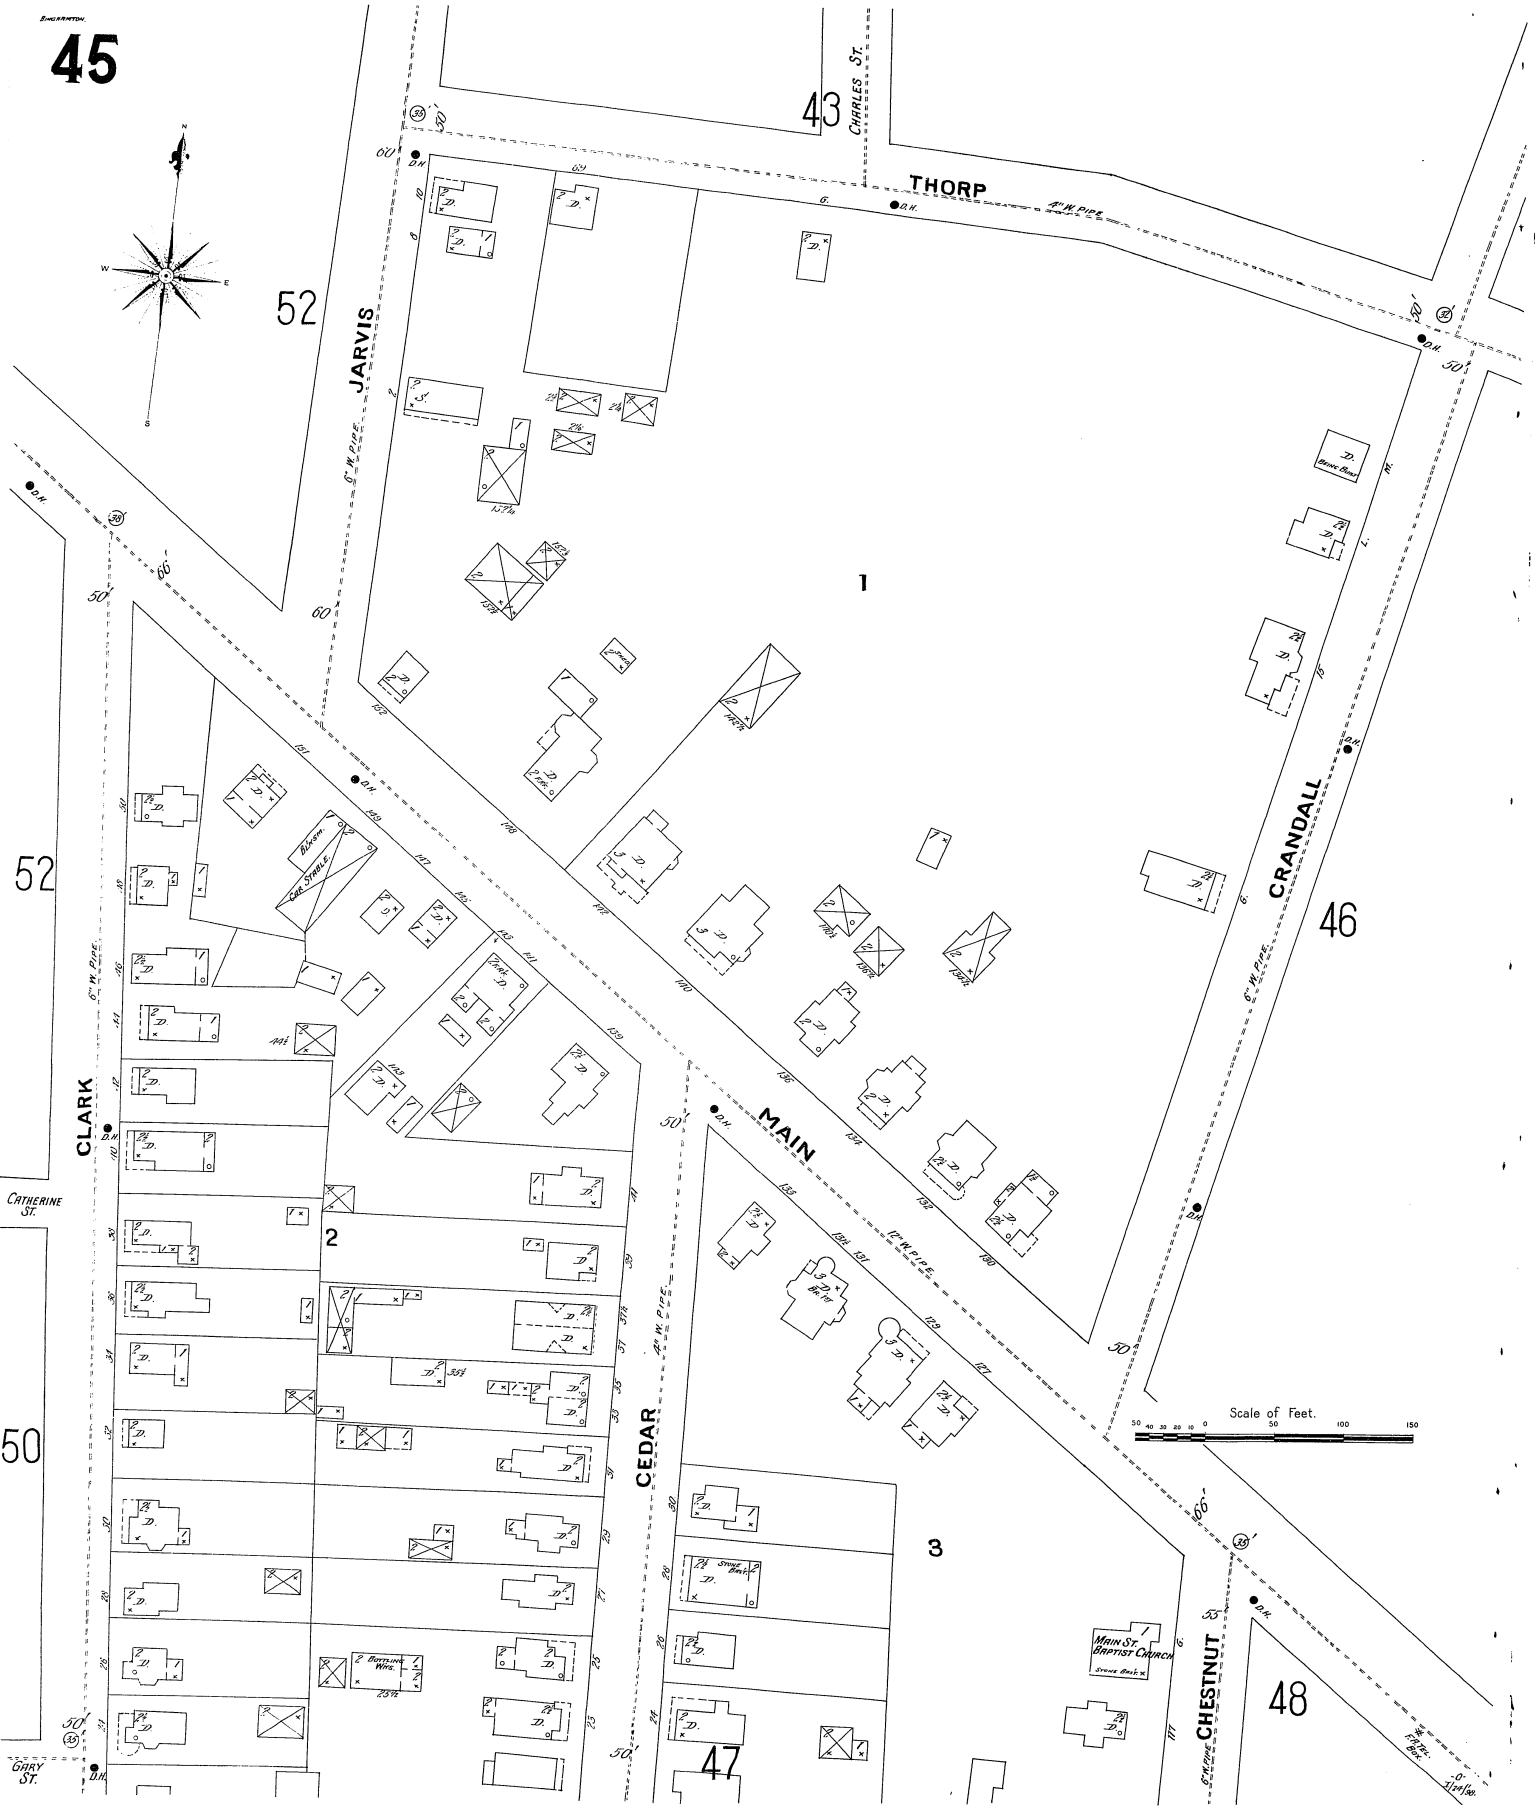





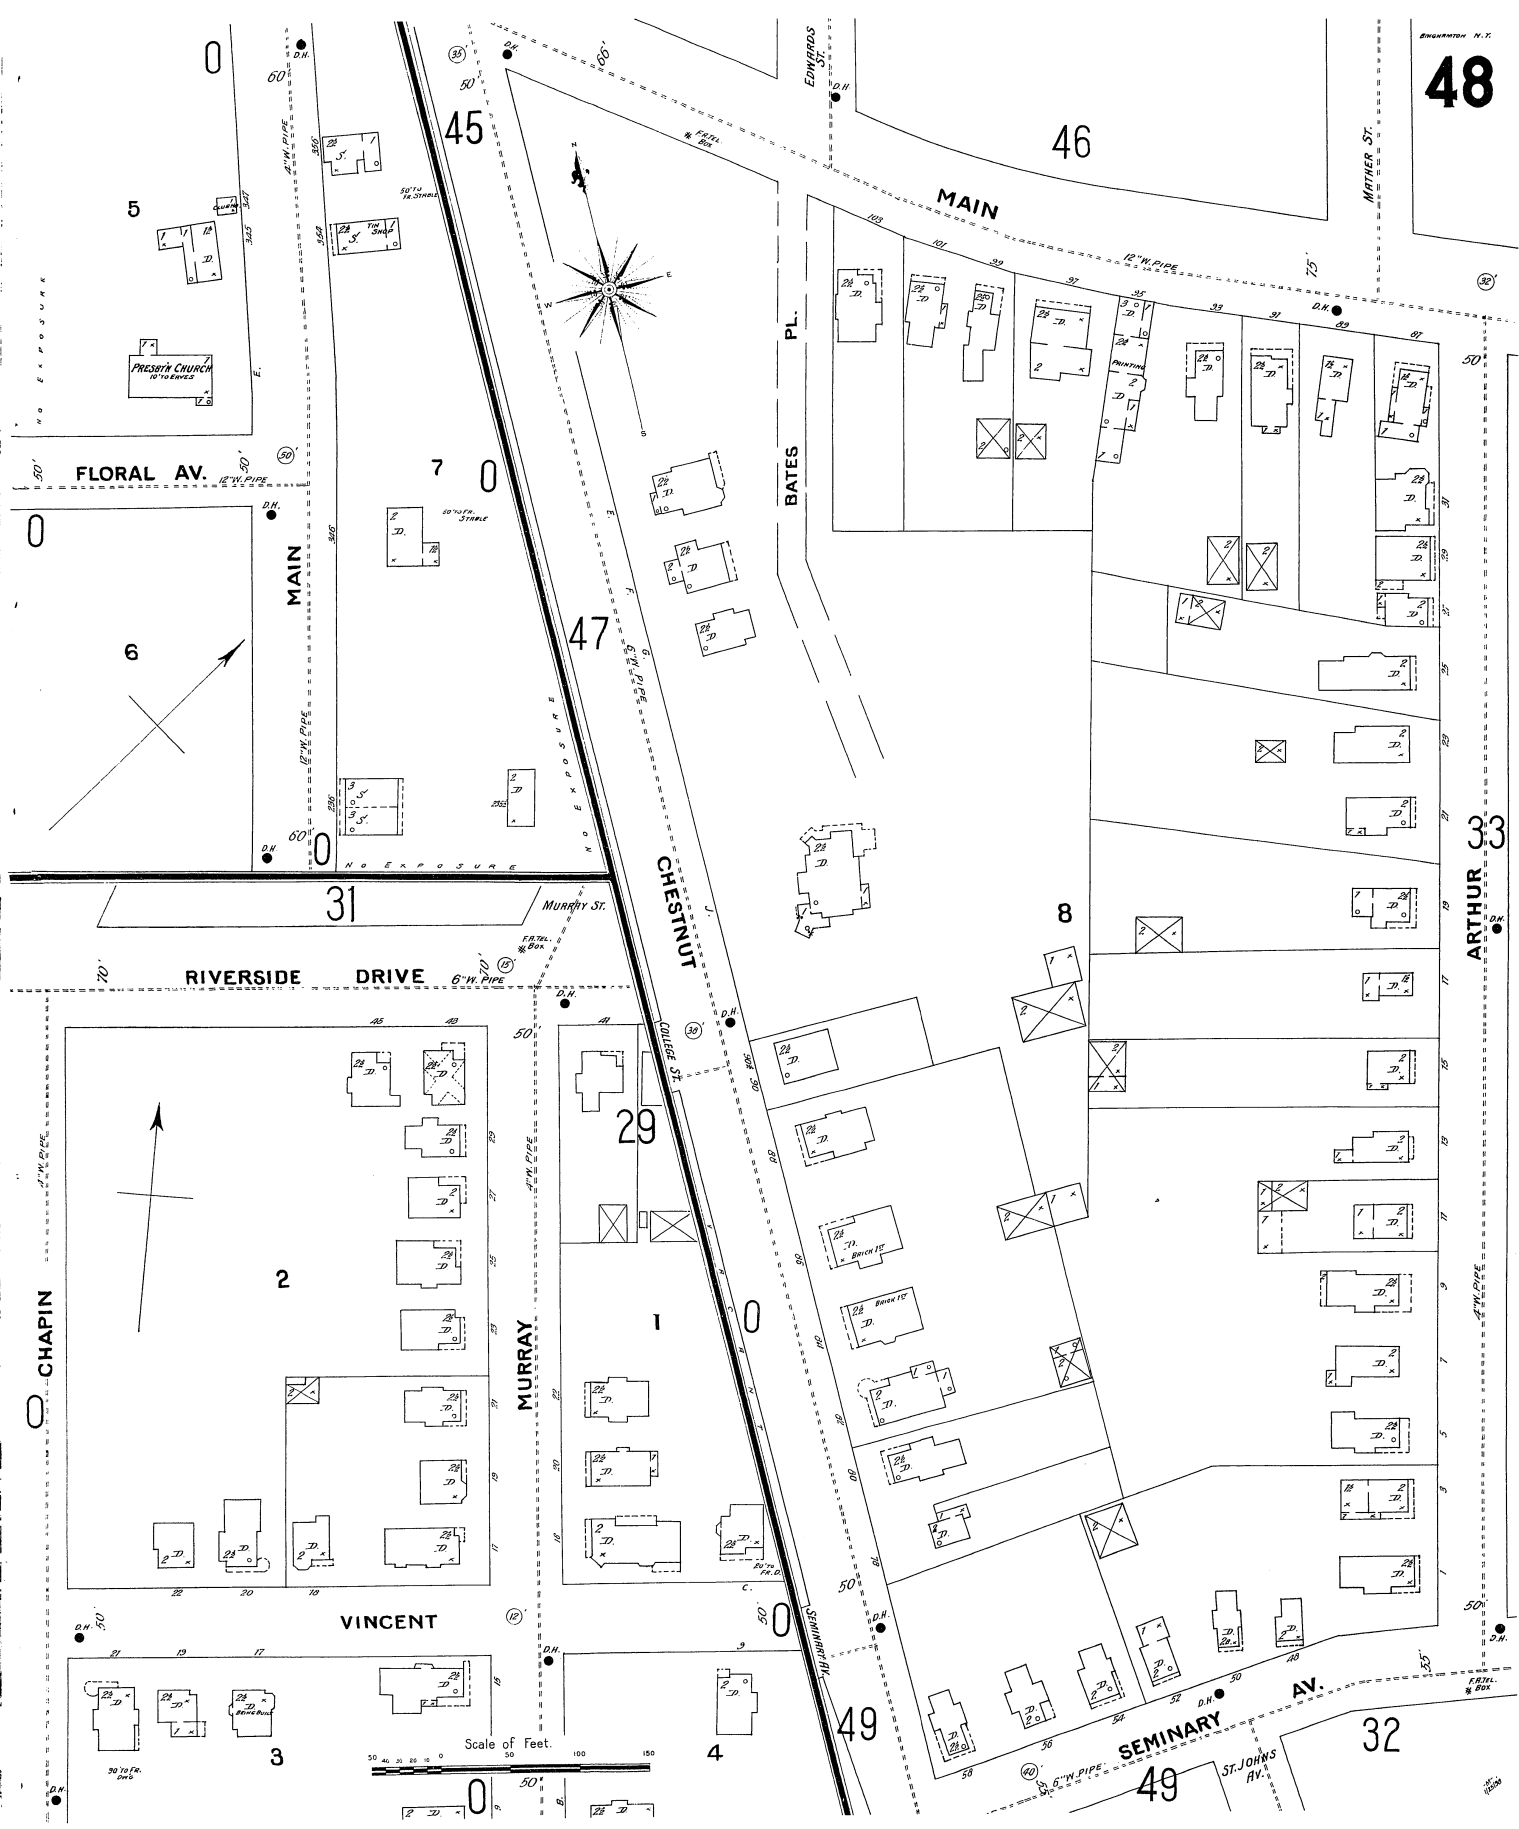

Scale of Feet. 0 50 100 150

ARTHUR ST. 33

SEMINARY AV. ST. JOHNS AV.

CHAPIN

CHESTNUT

BATES PL.

MAIN

FLORAL AV.

RIVERSIDE DRIVE

VINCENT

MURRAY

MATHER ST.

PRESBYT. CHURCH

0

3

31

2

7

47

29

4

49

8

46

45

32

5

6

0

0


0

0

49


47

SEMINARY AV.

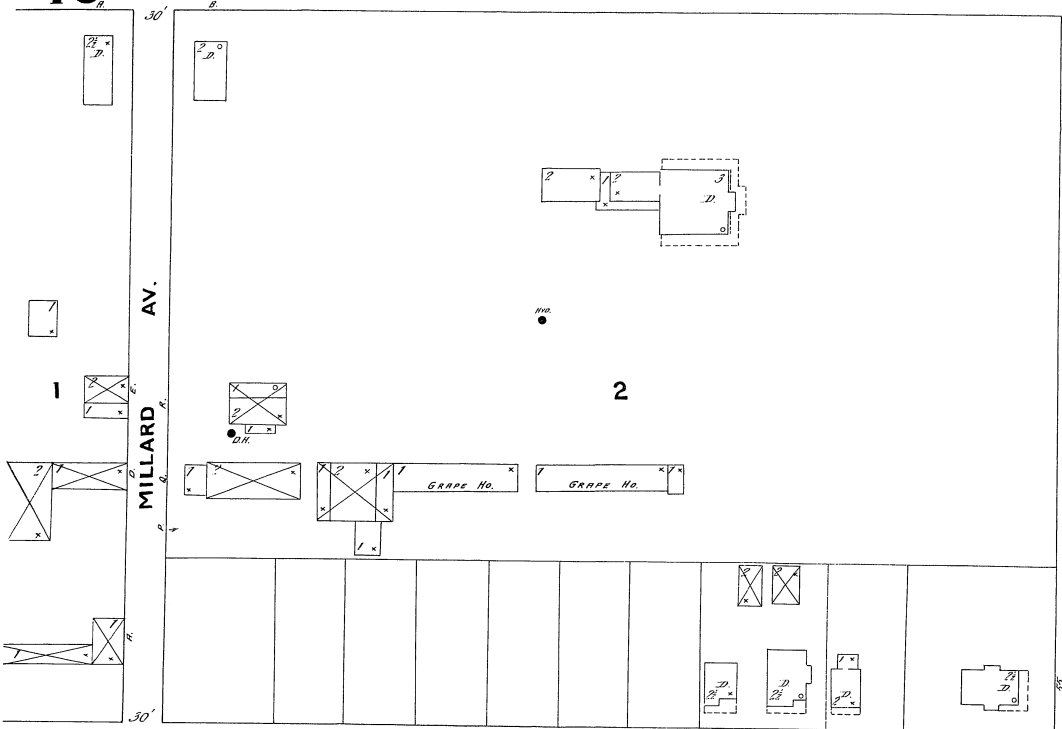


48

SEMINARY AV.

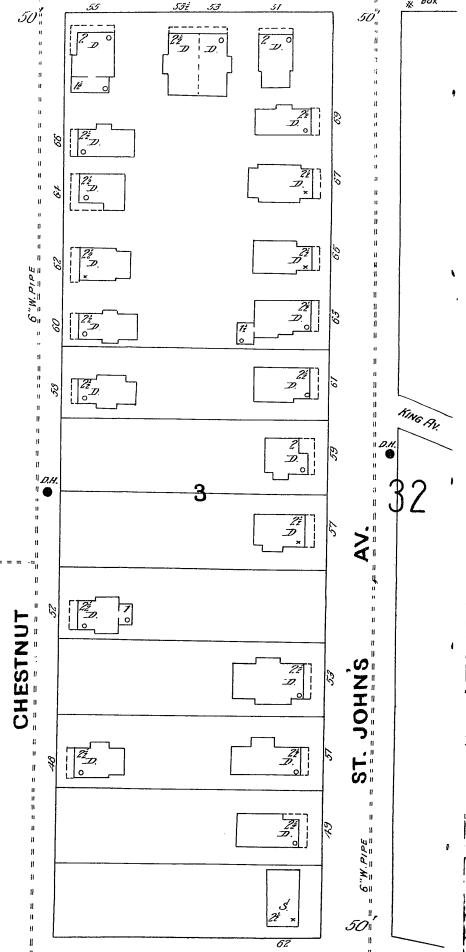

LINCOLN AV.

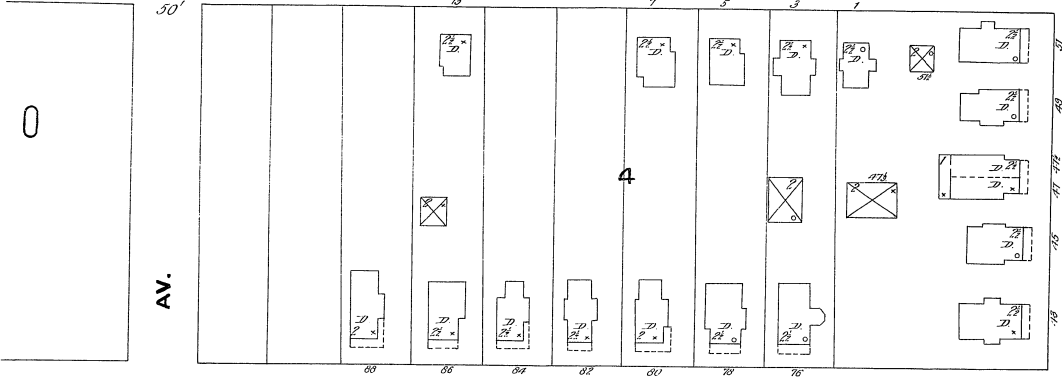


CHESTNUT

ST. JOHN'S AV.


32

LEROY

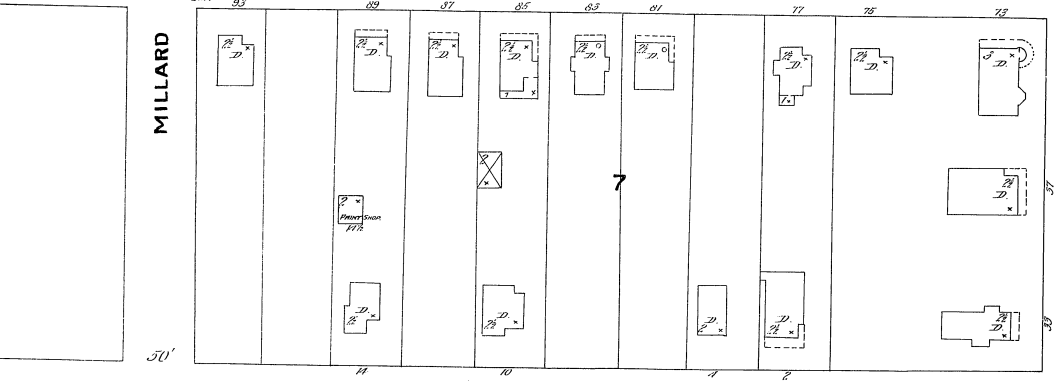

LATHROP AV.

32

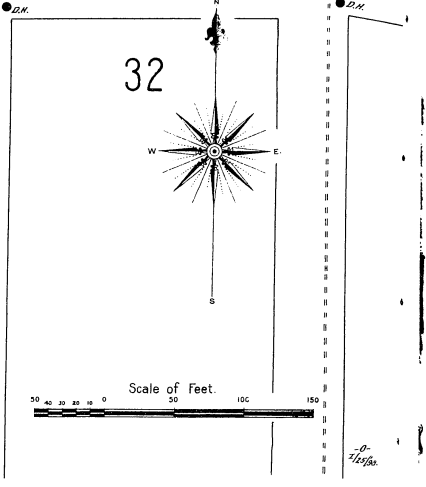

Scale of feet.





CHARLOTTE

43

THORP ST.

JARVIS

45

MAIN

51

BEETHOVEN

GOETHE ST.

LAUREL

2

CLARK

 



53

MENDELSSOHN

HAENDEL

CATHERINE

50

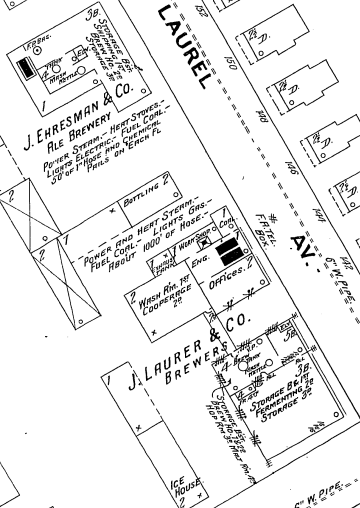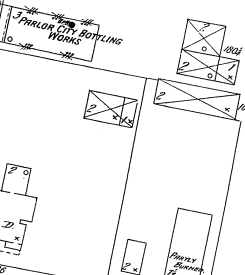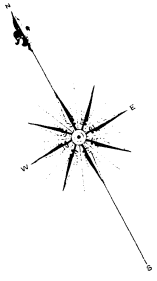

53

SCHILLER

SCHUBERT

HAENDEL




GOETHE

BEETHOVEN


MEYERSONN

ROSSVILLE CHEMICAL WKS  
V C H H

BAYLESS AV.

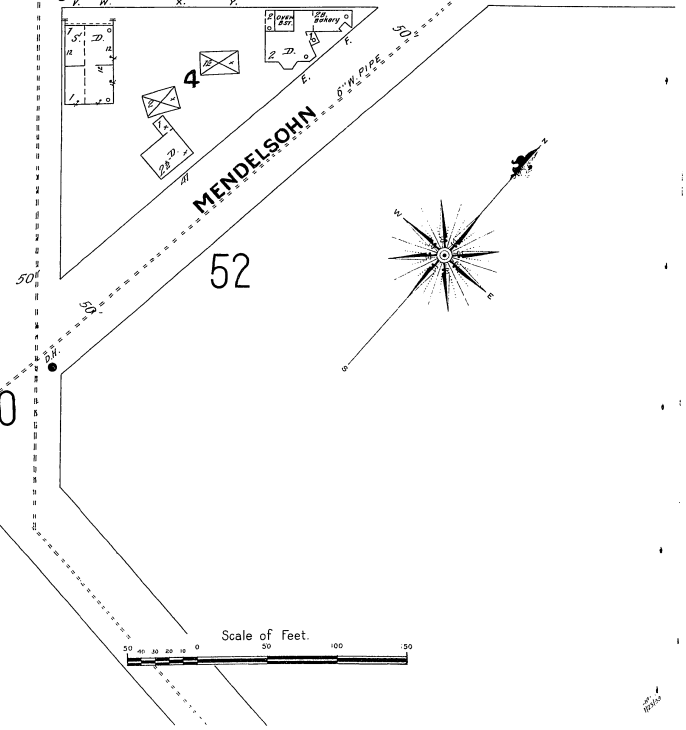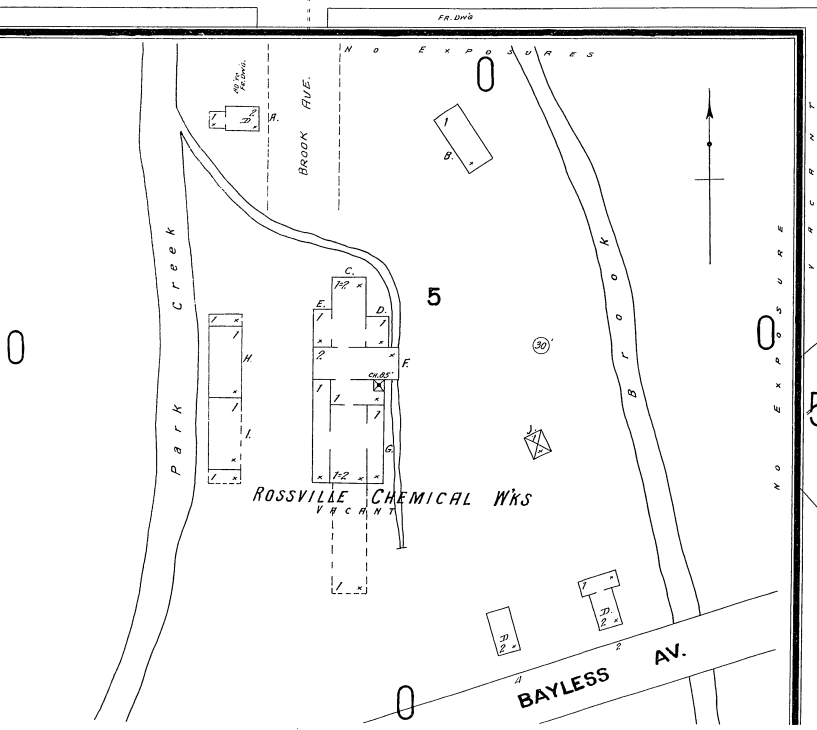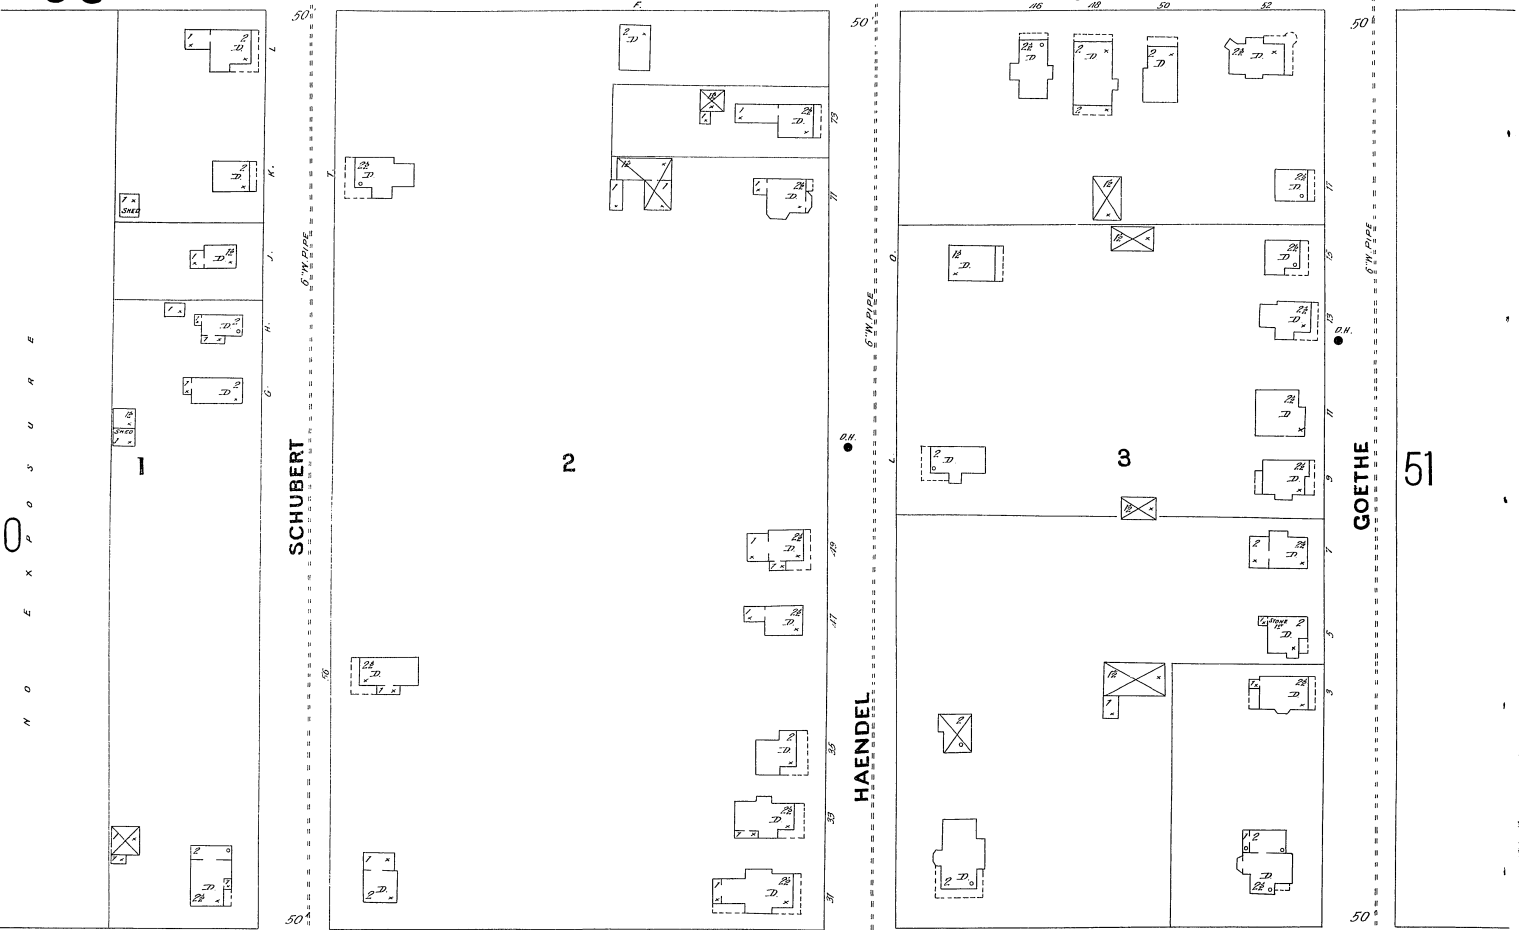

Scale of Feet. 0 50 100 50

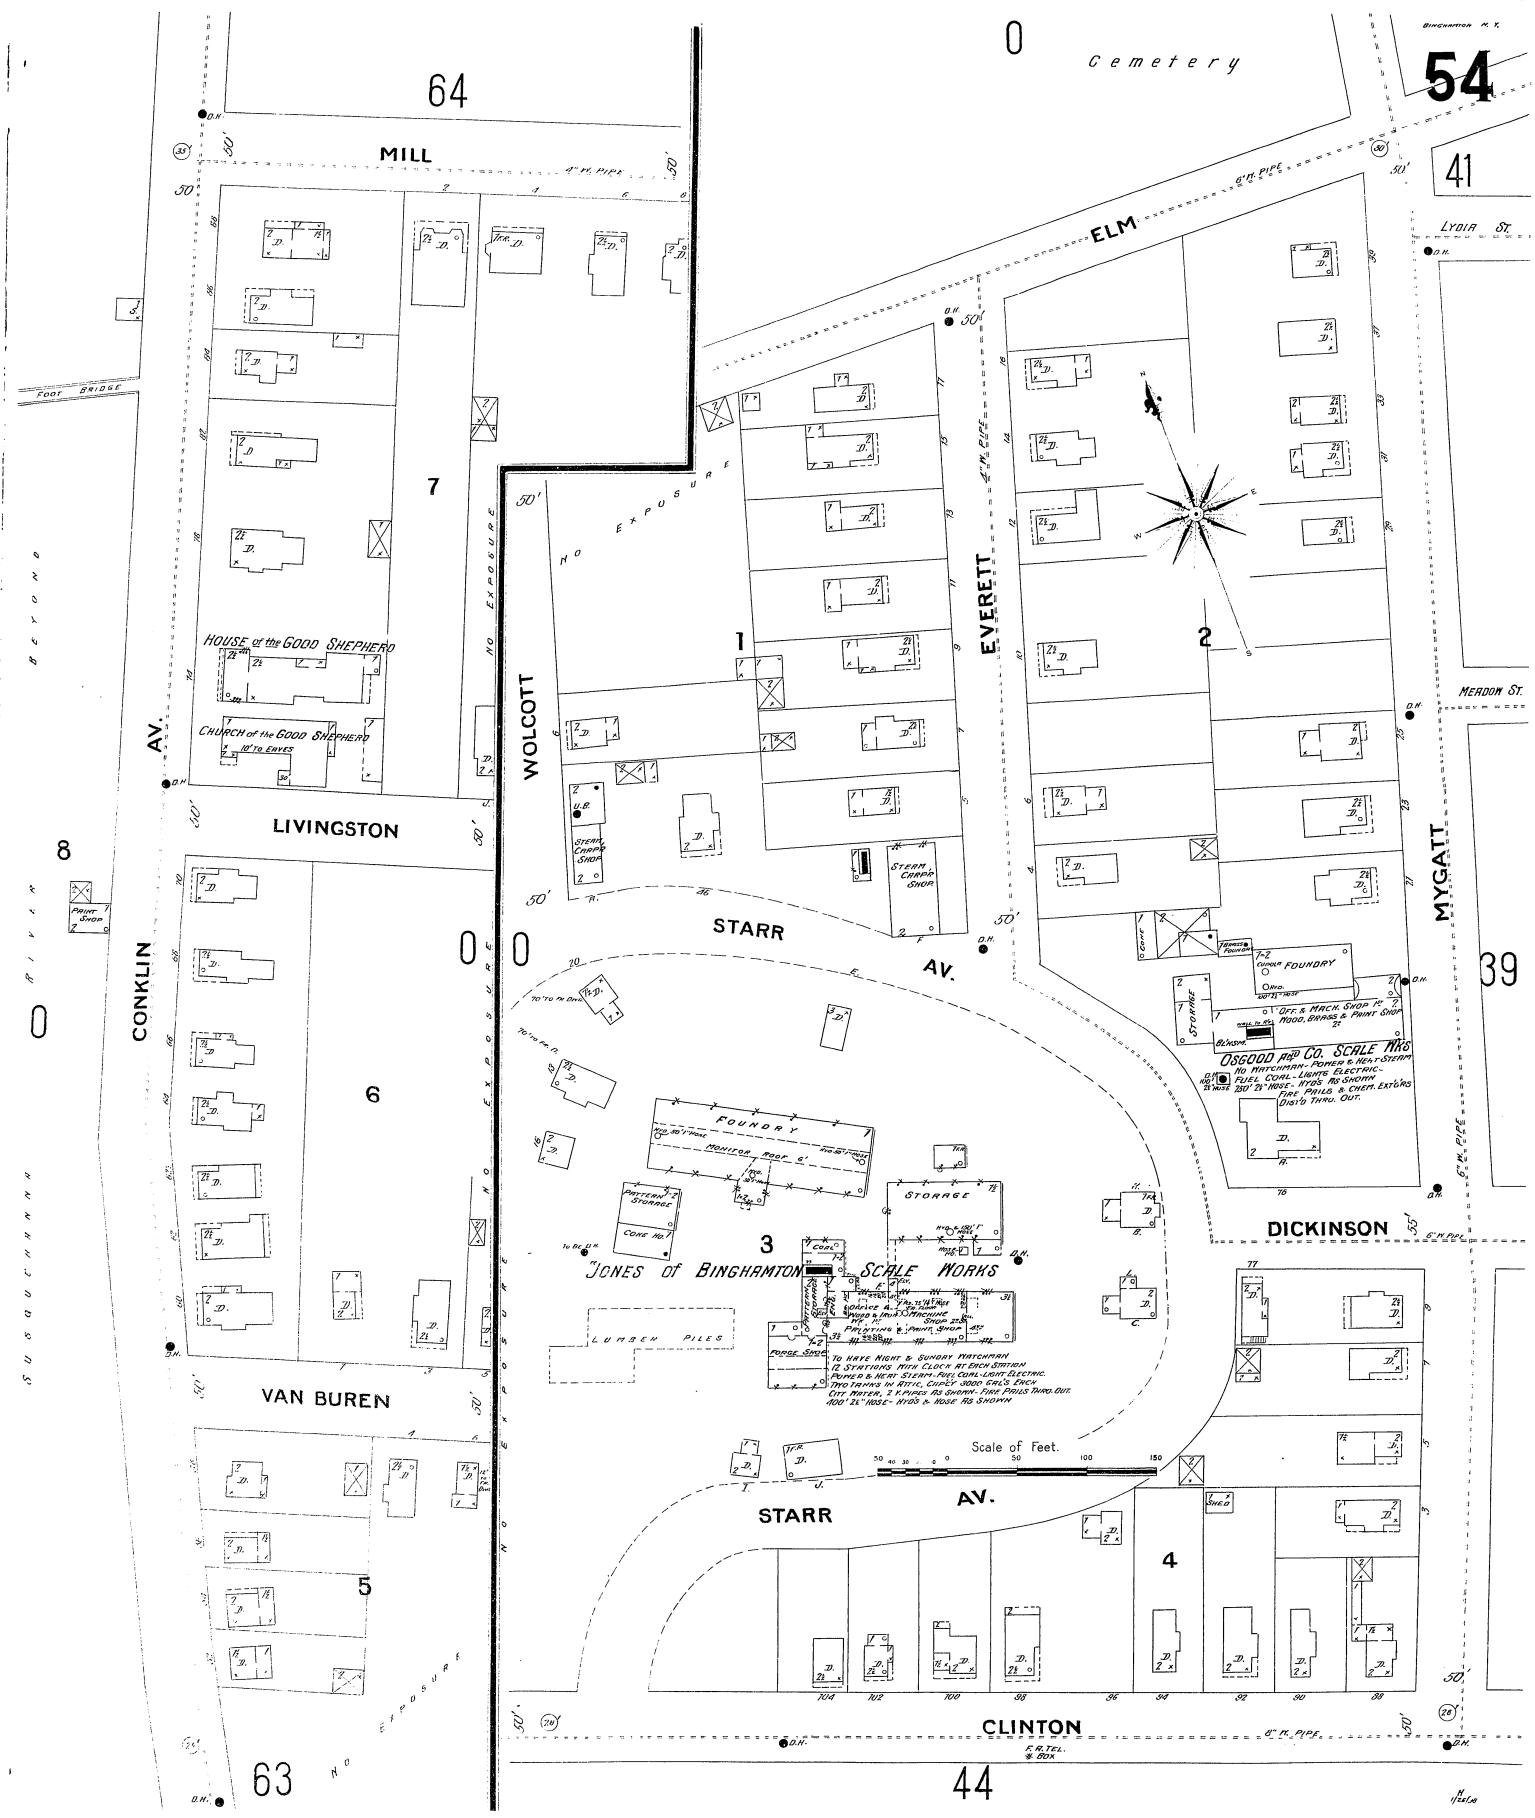

Cemetery

54

64

MILL

41

ELM

7

HOUSE of the GOOD SHEPHERD  
CHURCH of the GOOD SHEPHERD  
18' to EAVES

EVERETT

AV.

LIVINGSTON

WOLCOTT

STARR

AV.

8

CONKLIN

6

DICKINSON

JONES OF BINGHAMTON SCALE WORKS

39

VAN BUREN

STARR

4


CLINTON

63

44

Scale of Feet.

1/2" = 10'

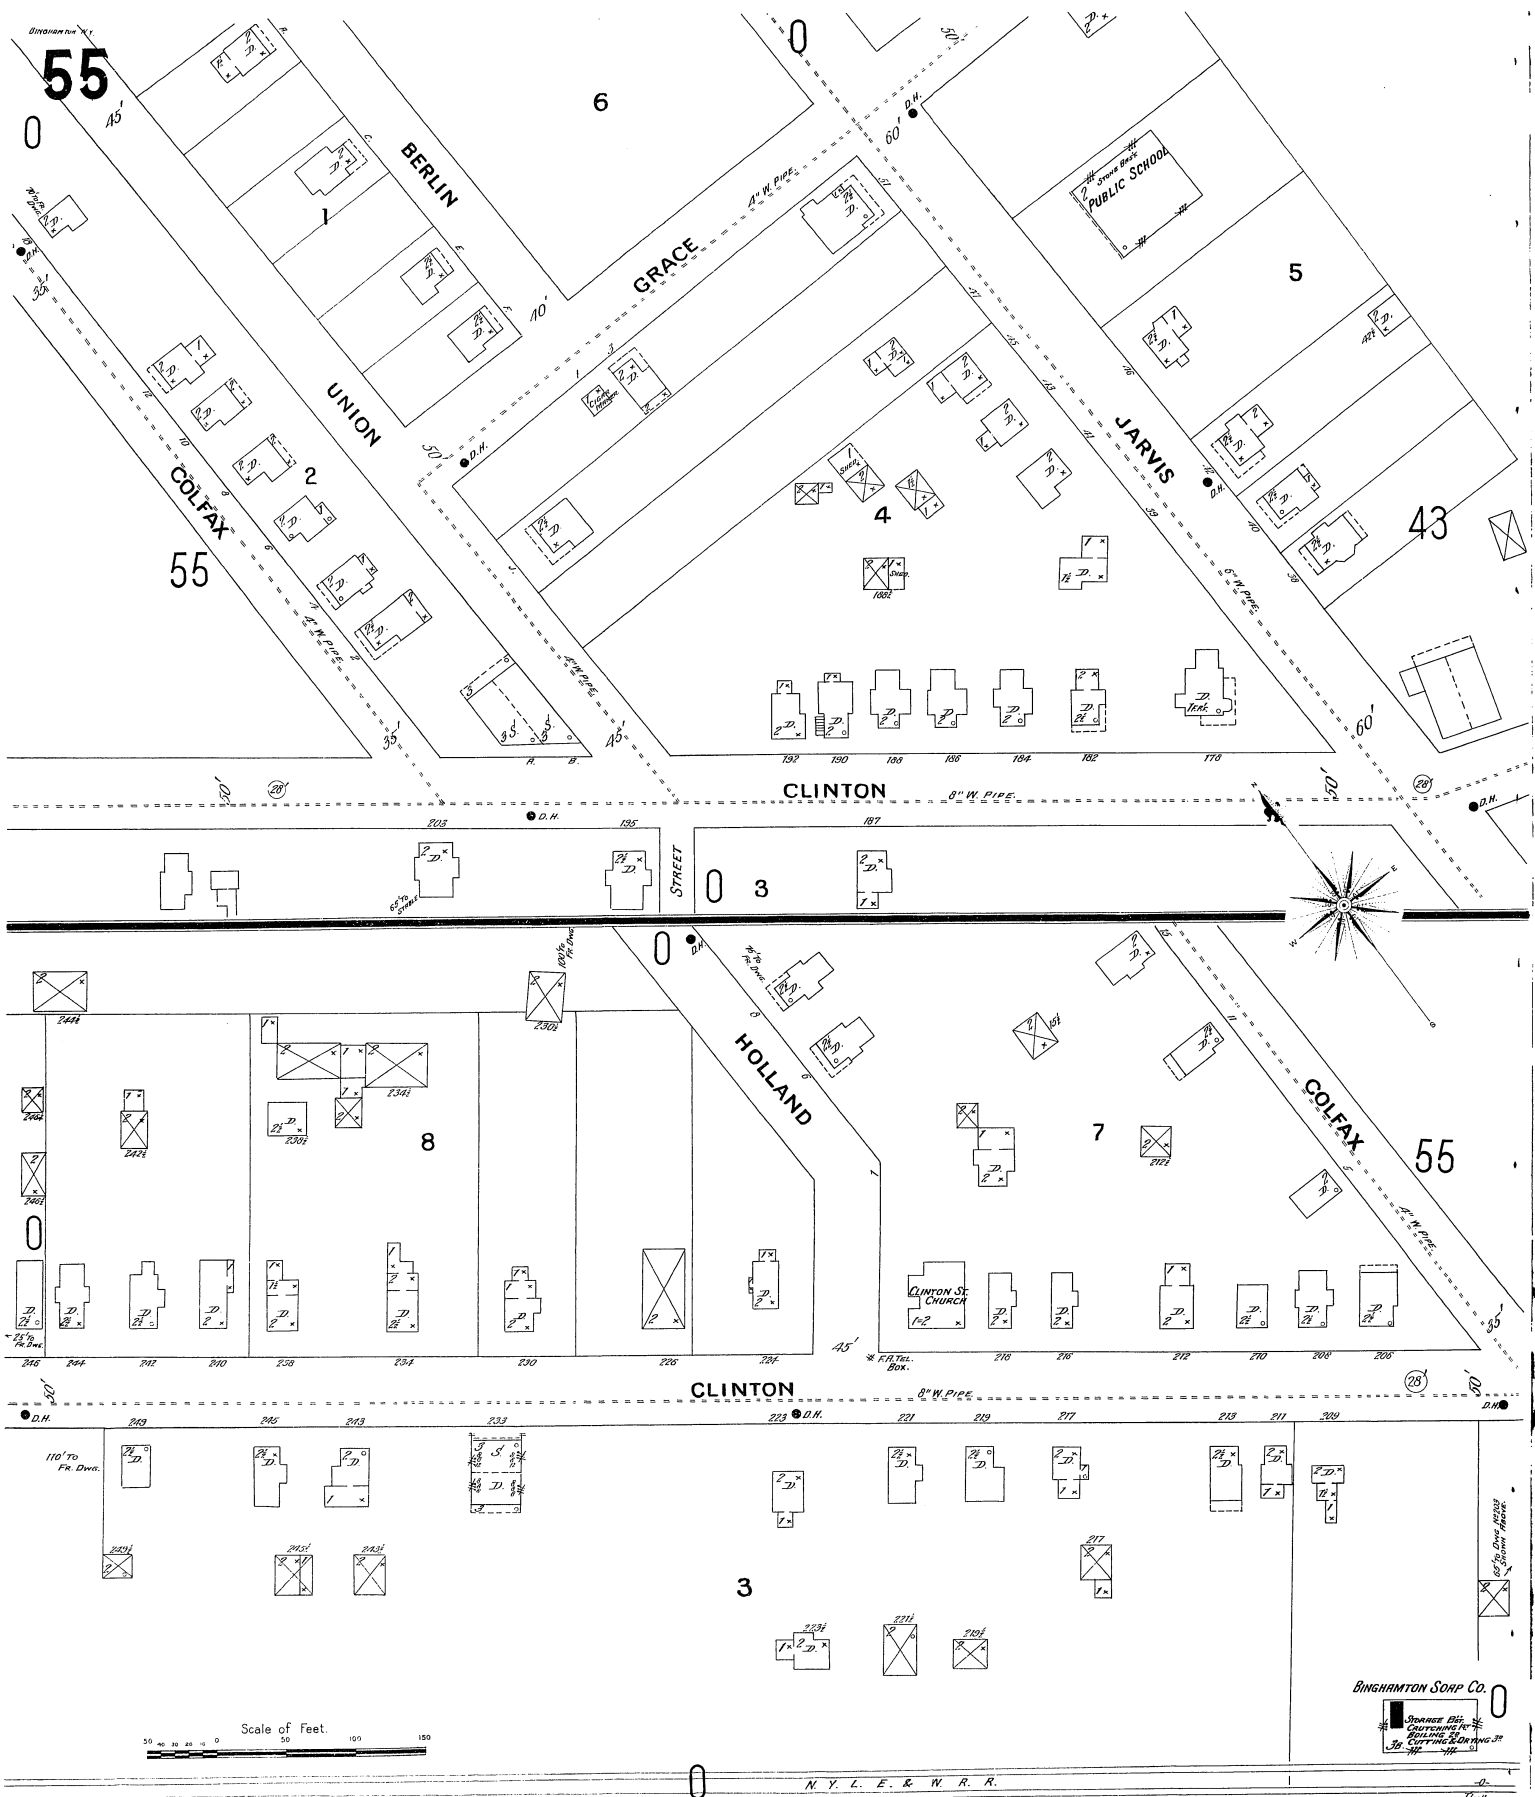

55

6

BERLIN

GRACE

PUBLIC SCHOOL

5

UNION

COLFAX

55

2

4

JARVIS

43

CLINTON

0

3

HOLLAND

COLFAX

55

8

7

CLINTON ST. CHURCH

CLINTON

 



3

Scale of Feet.

BINGHAMTON SOAP CO.

N. Y. L. E. & W. R. R.

N O E X P O S U R E

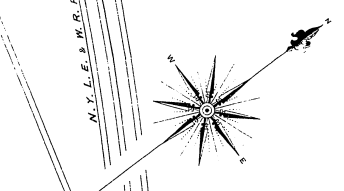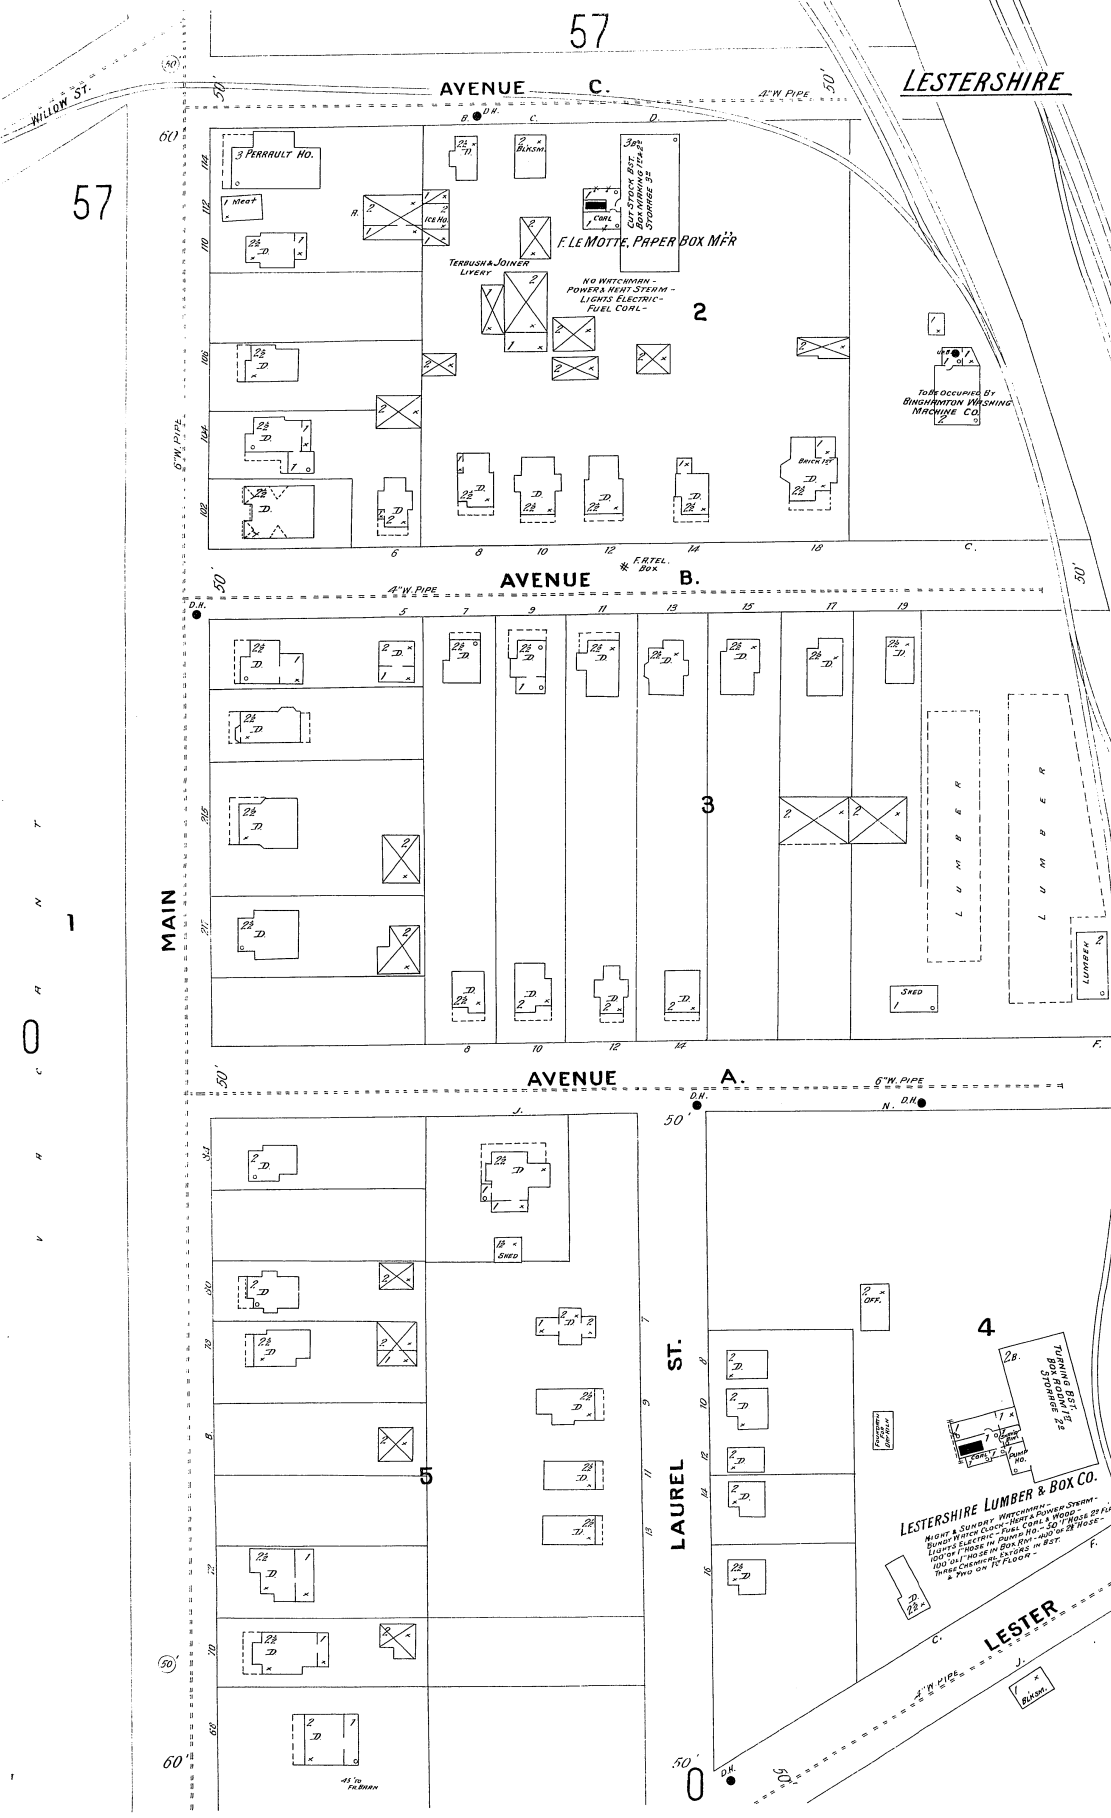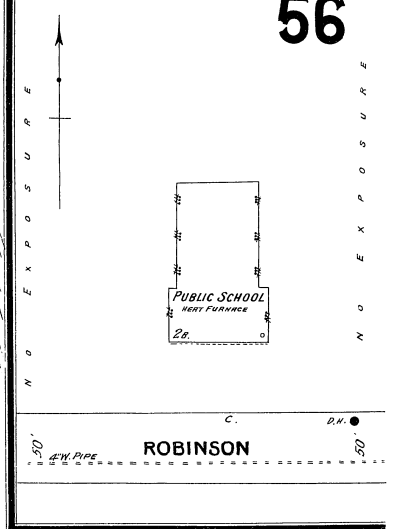

57

57

60

60

60

60

60

60

60

60

WILSON ST.

AVENUE C.

LESTERSHIRE

MAIN

AVENUE B.

AVENUE A.

LAUREL ST.

LESTER AV.

3 FERRAULT HD.

F. LE MOTTE, PAPER BOX MFR

TERBUSSA JOINER LIVERY

NO REFRIGERATION - POWER & HEAT STEAM - LIGHTS ELECTRIC - FUEL COAL

TABLE OCCUPIED BY BINGHAMTON WASHING MACHINE CO

ROBINSON

PUBLIC SCHOOL BEST FURNACE

**LESTERSHIRE LUMBER & BOX CO.**

TURNING OUT 1000 BOXES OF BOXES PER DAY

NIGHT & SUN DAY WORKING

BUILT BY JOHN C. HORTON & SONS

LESTER AVENUE - FROM CORNER A WOODS

100' x 100' IN DIMENSIONS - 100' x 100' IN AREA

100' x 100' IN DIMENSIONS - 100' x 100' IN AREA


100' x 100' IN DIMENSIONS - 100' x 100' IN AREA

100' x 100' IN DIMENSIONS - 100' x 100' IN AREA

45' 10" P.C. BRICK

LESTERSHIRE

56

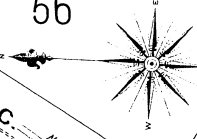

WILLOW

BROAD

58


 
ELIZABETH

ARCH

BALDWIN

59

Scale of Feet.

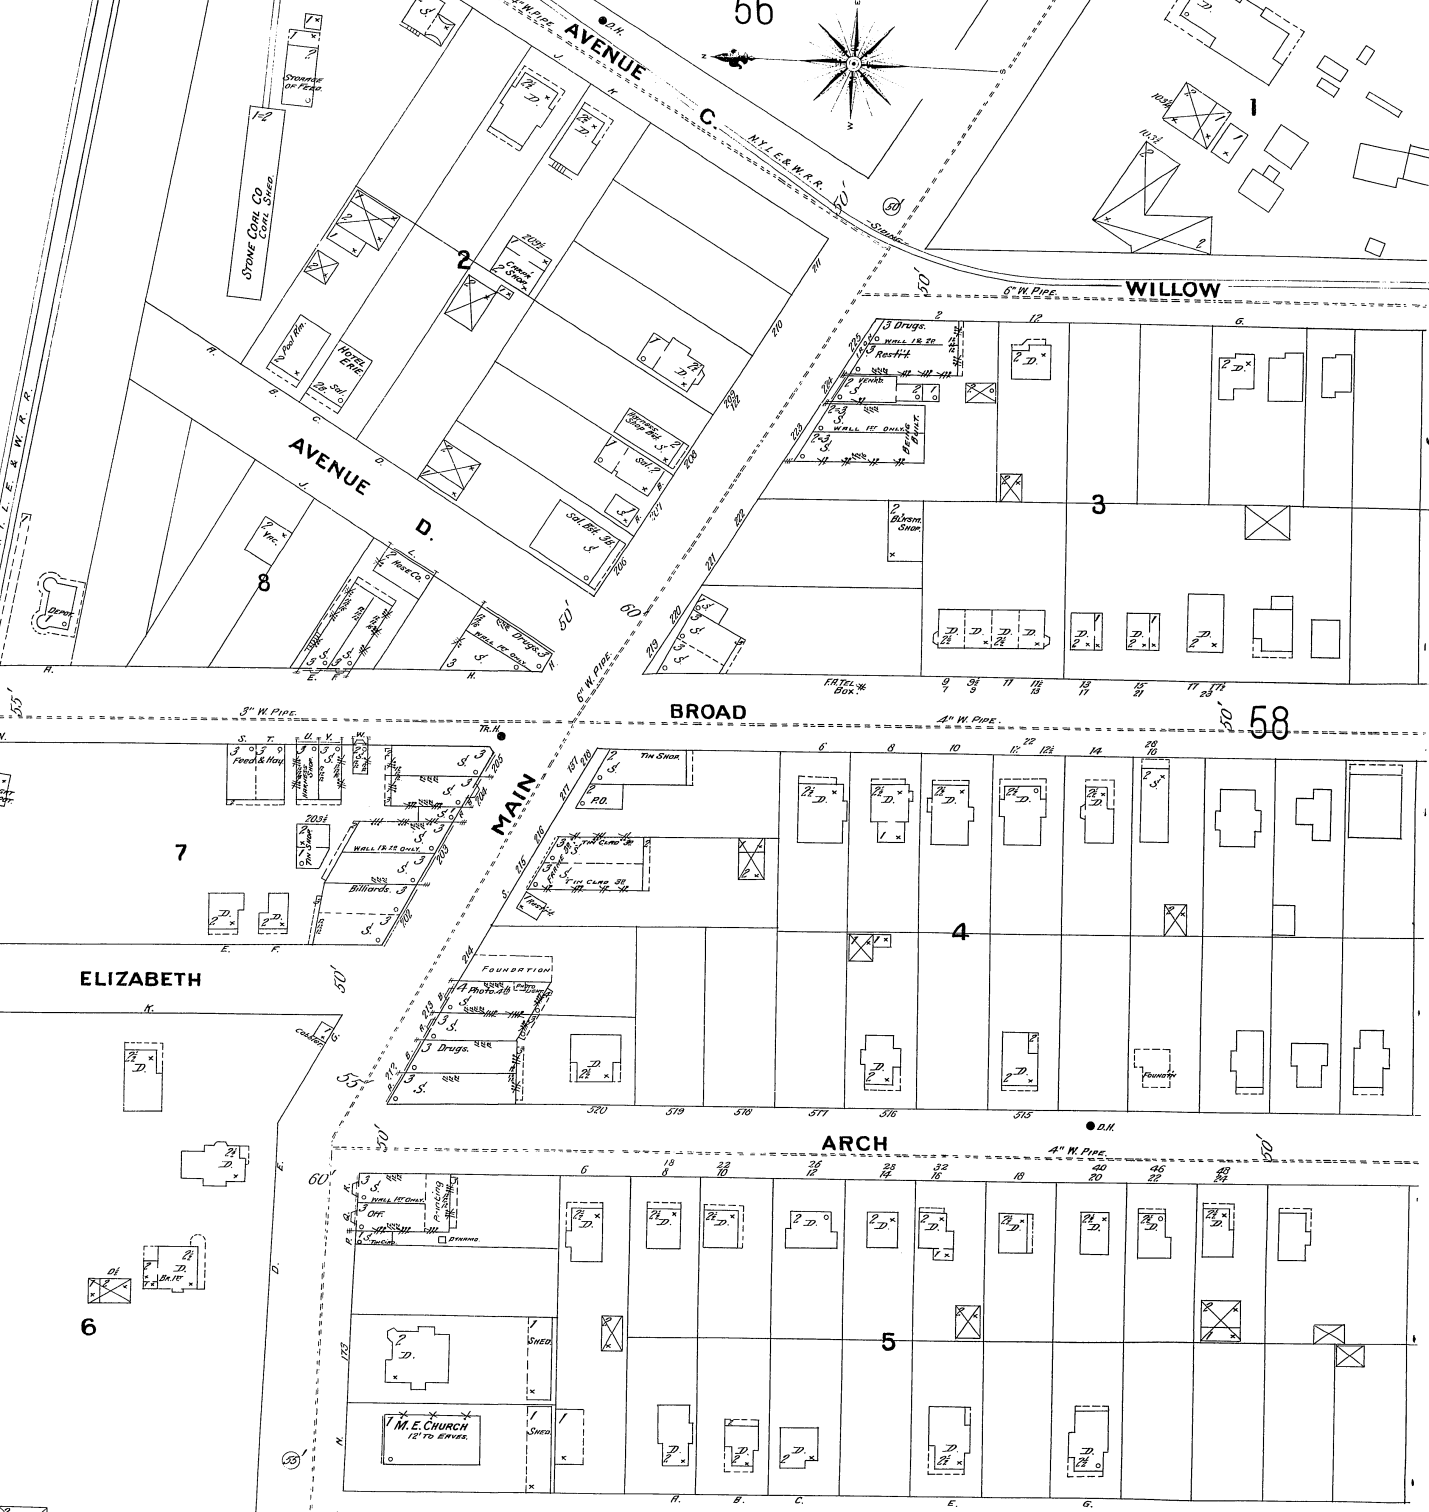


NO EXPOSURE

1-25-11





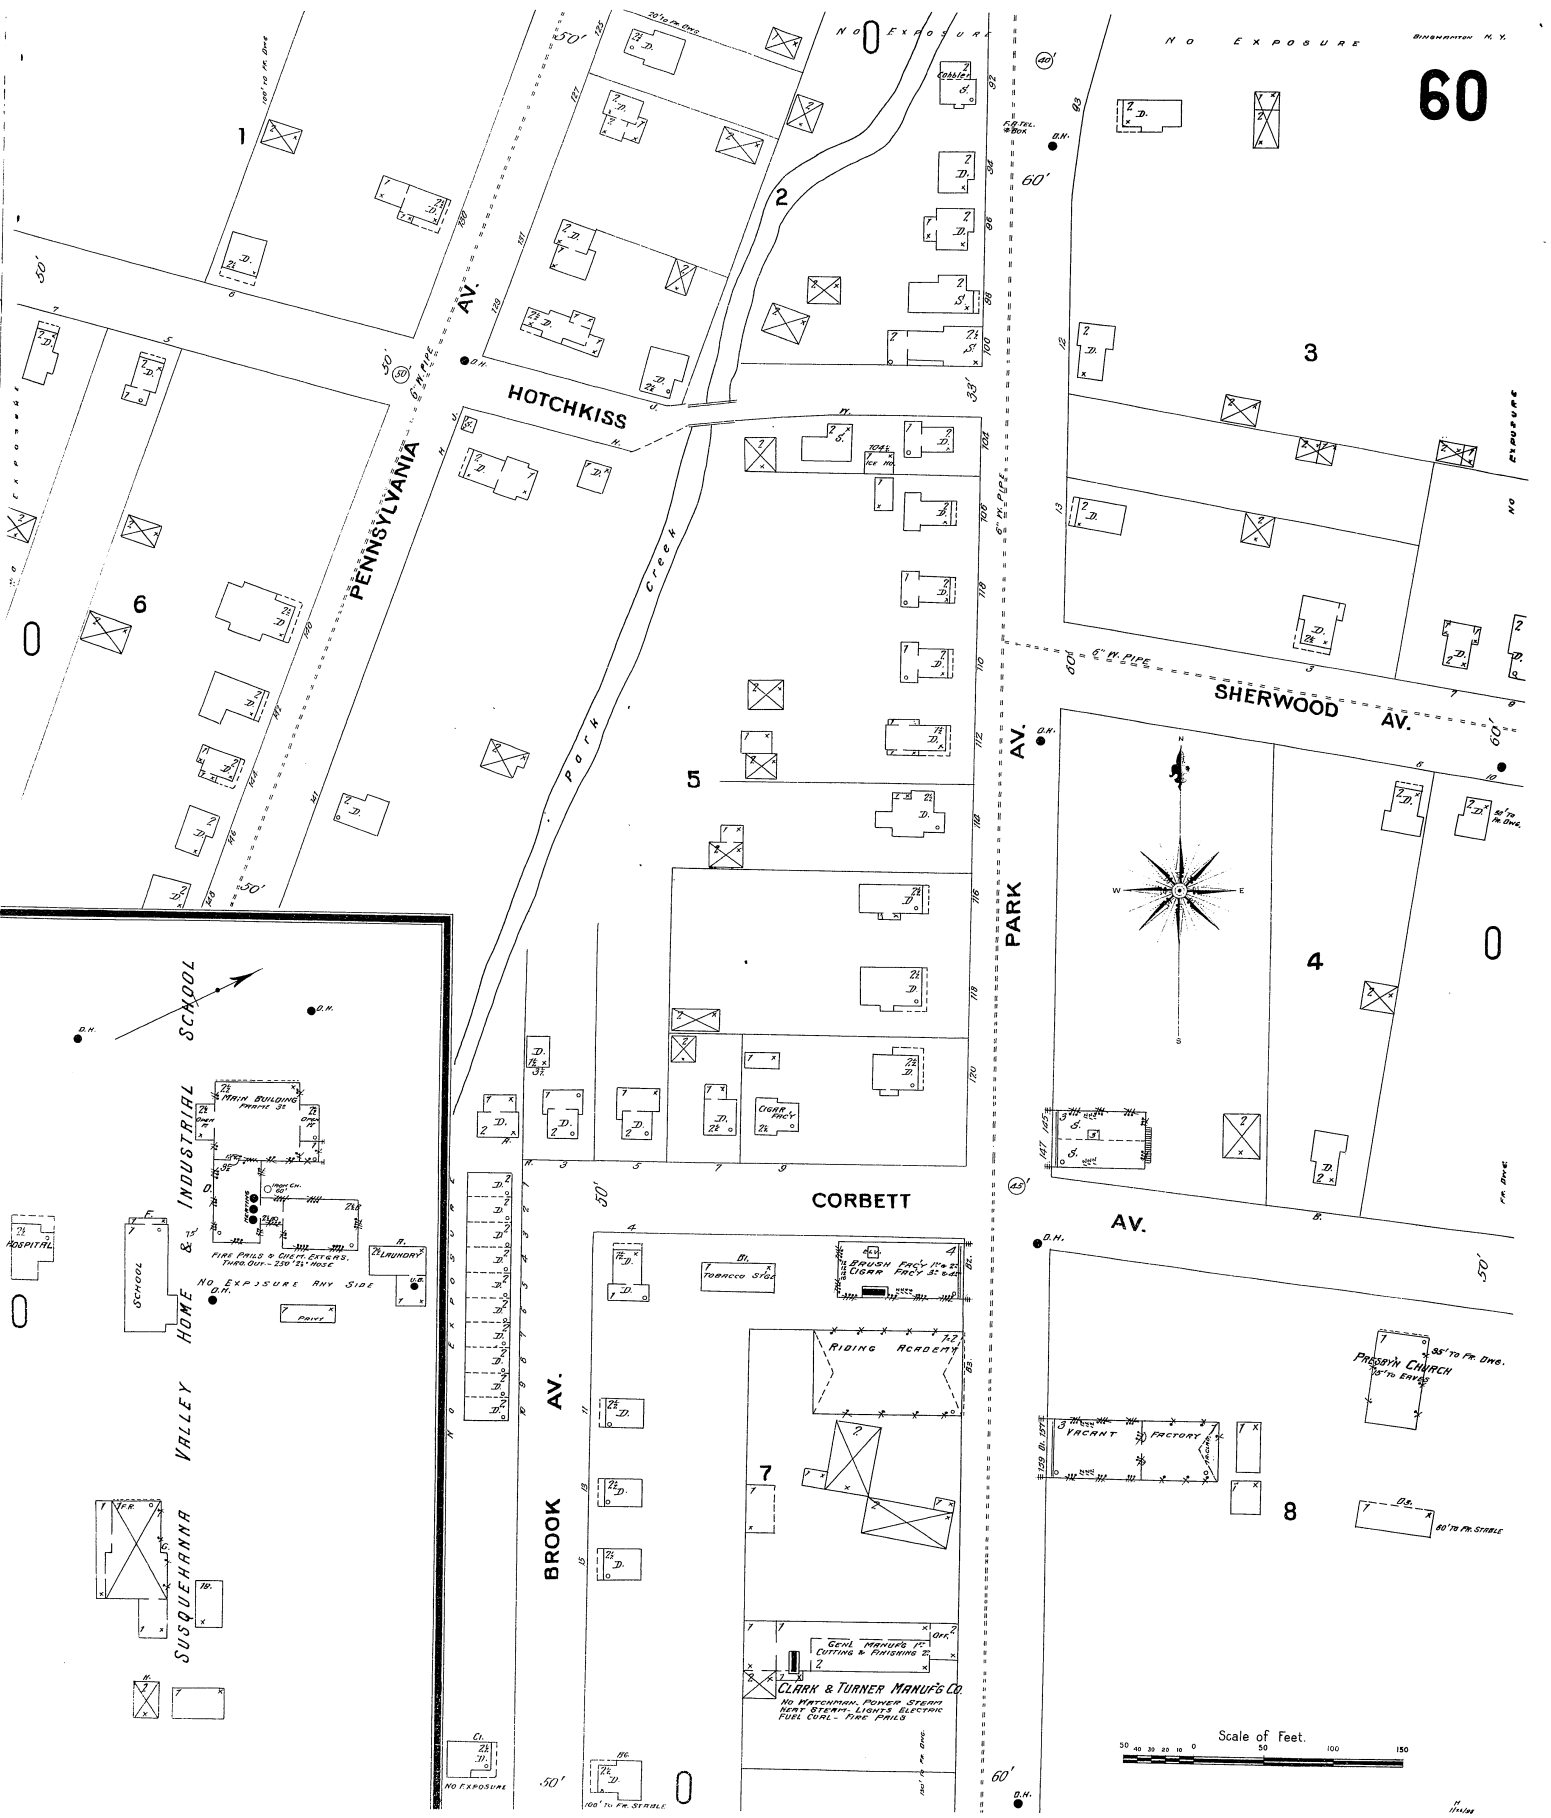

Scale of Feet.

0 10 20 30 40 50 60 70 80 90 100 110 120 130 140 150

SCHOOL

HOSPITAL

INDUSTRIAL HOME VALLEY SUSQUEHANNA

HOTCHKISS

CORBETT


BROOK AV.


PARK AV.

SHERWOOD AV.

CLARK & TURNER MANUFACTURING CO.  
 NO. BRUSHINGTON, PENNSYLVANIA  
 HEAT STOVES, LIGHTS, ELECTRIC  
 PAINTS, COALS - FIRE PIPES

85' TO PK. ANG.  
 10' TO ENDS  
 PROSPECT CHURCH

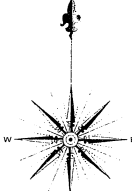

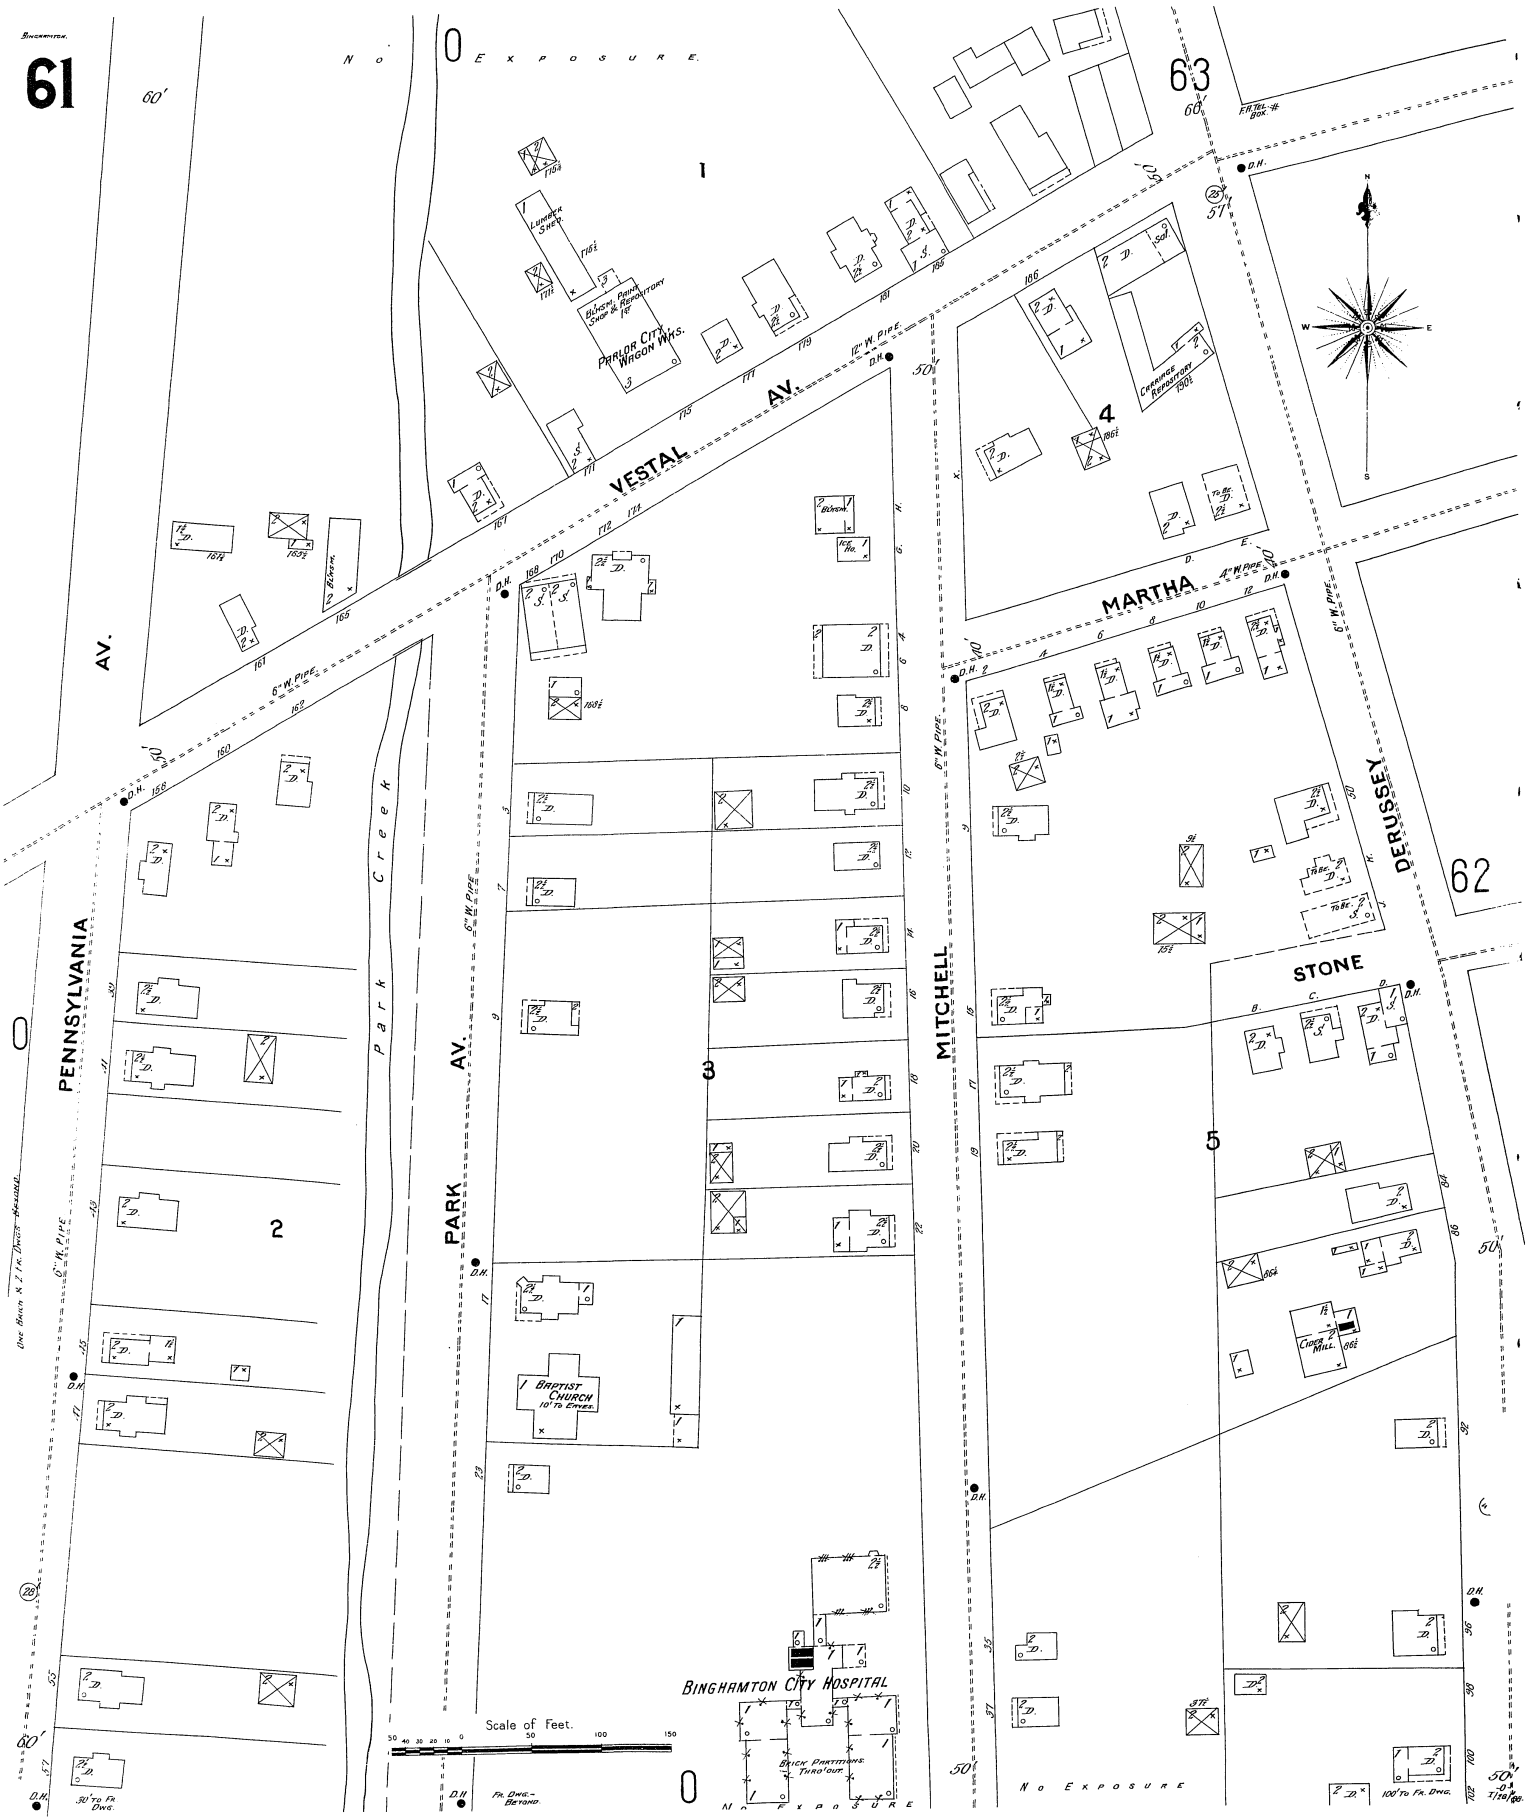


PRINCE CITY WAGON WHS.

BAPTIST CHURCH  
107 1/2 STONE

BINGHAMTON CITY HOSPITAL

Scale of Feet.  
50 100 150

 N O E X P O S U R E



One Block N. of Park Avenue

D.H. Fr. Dime - Berano

50' Fr. Dime



63

54

0

5

PUBLIC SCHOOL

NO EXPOSURE

NEW

3

MARY

CONKLIN

GIFFORD PL.

VESTAL

62

 
DERUSSEY

MENDALL BLK

SHALLICE BLK

4


61



River

Susquehanna

 Scale of Feet.



N O E X O P O S U R A

64

65

BIRCH

CARLTON

HIGH

MILL

65

8

0


 
 
CONKLIN AV.

HANCOCK

VESTAL AV.

High St. M.E. Church  
25' to Eaves

Scale of Feet

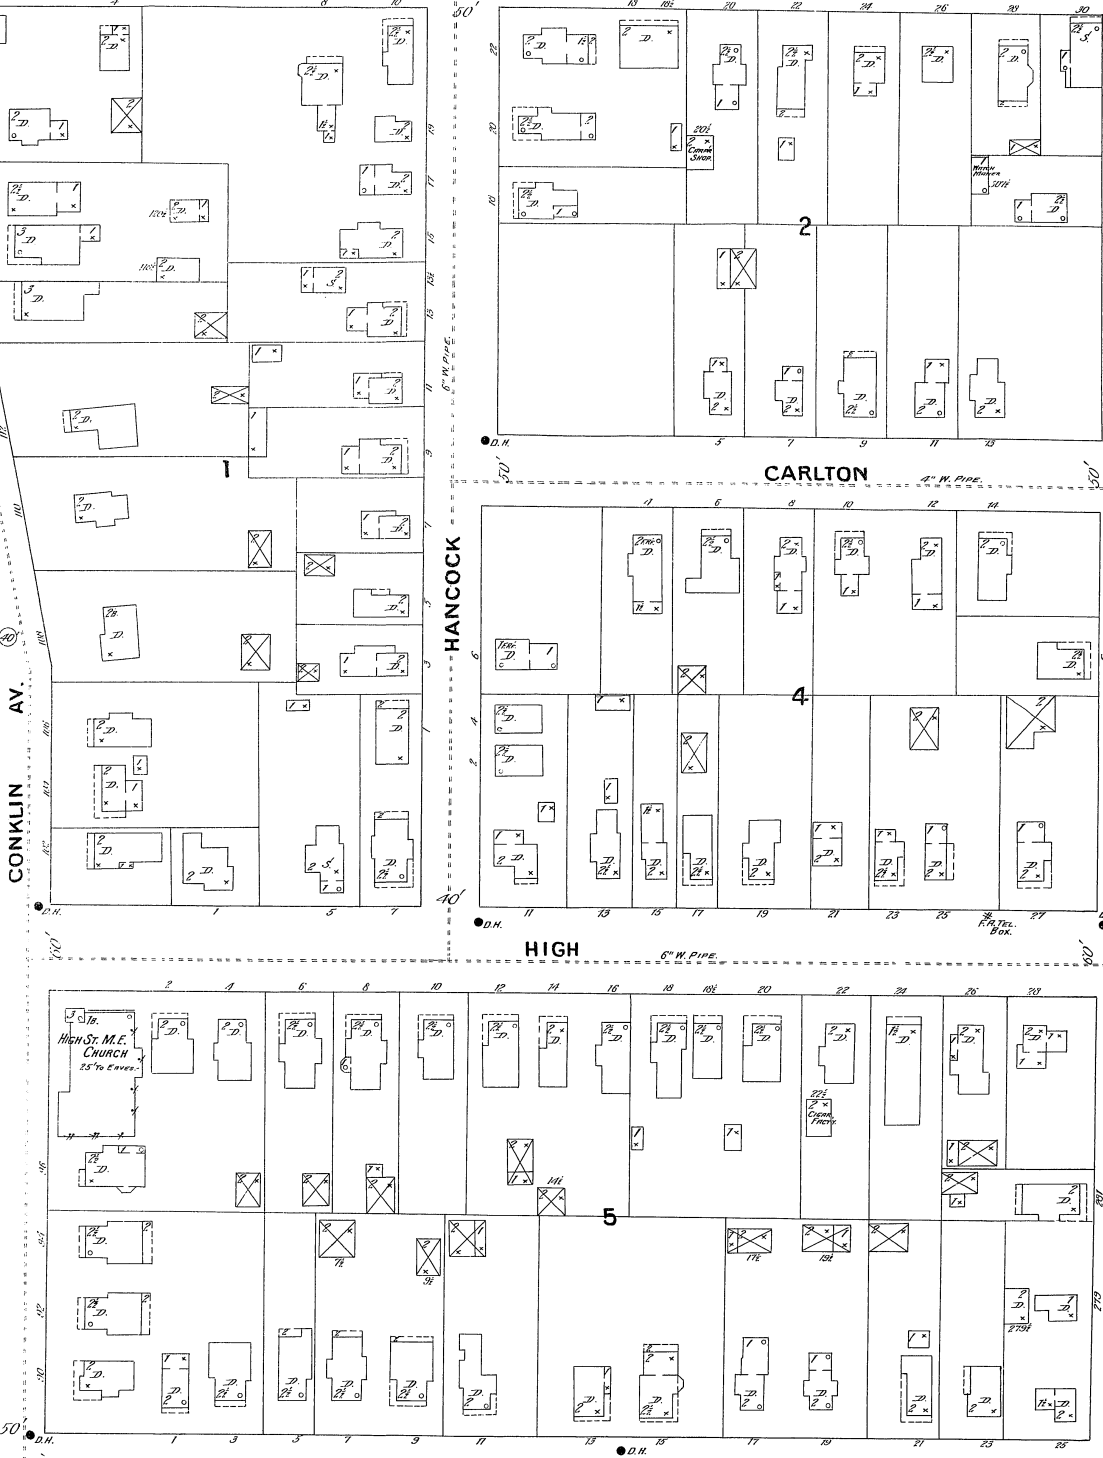

54

7







0

30


50

17 1/2 ft.



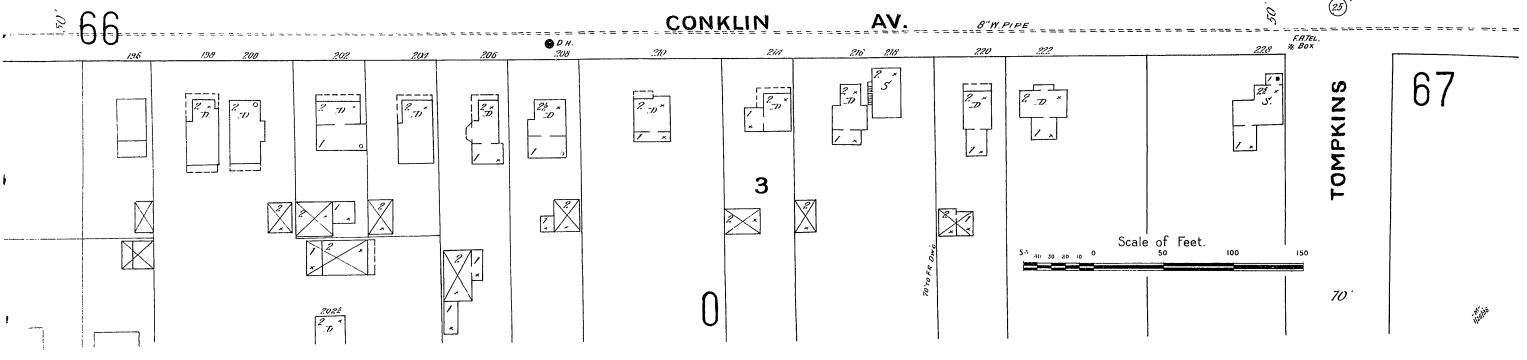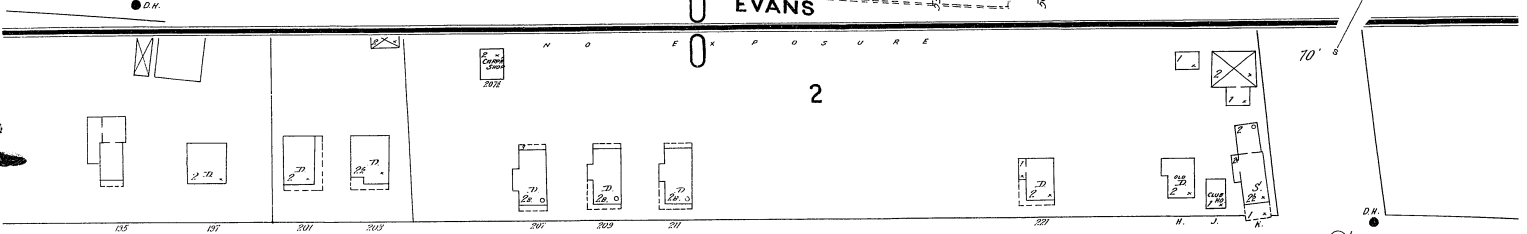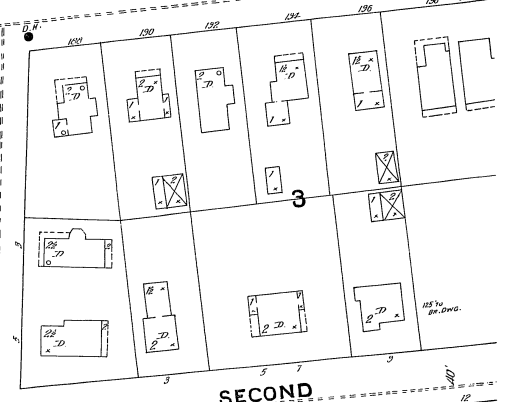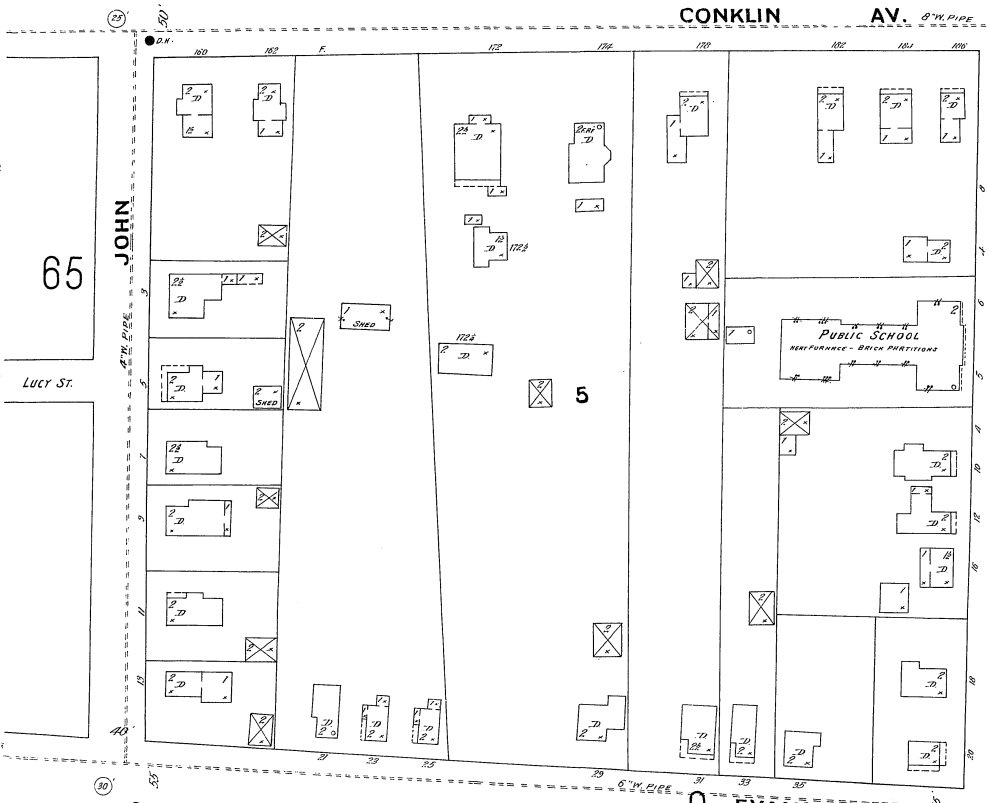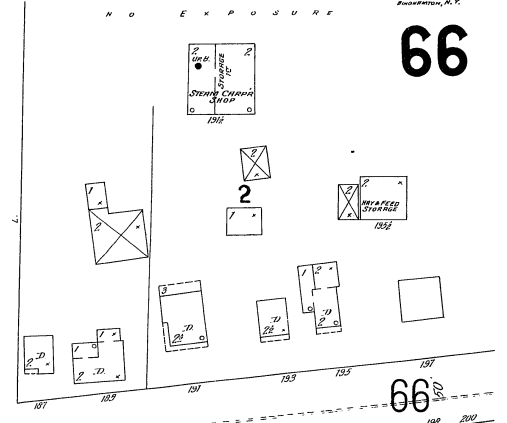
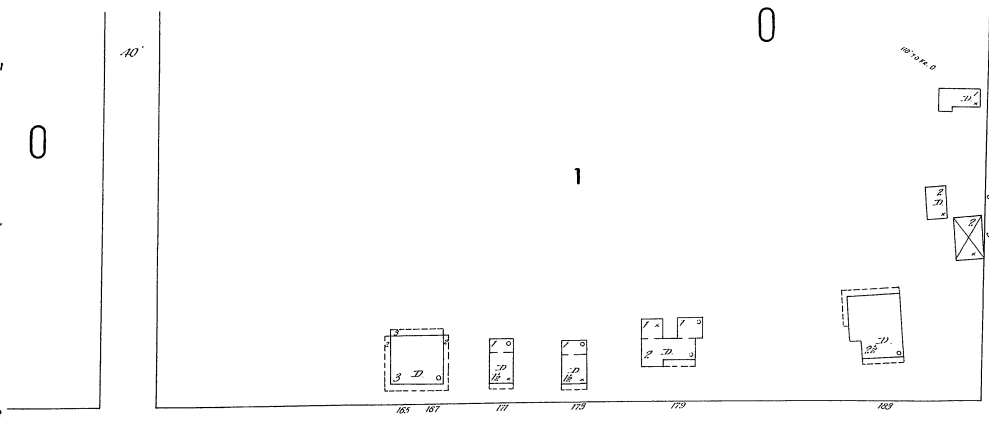


67 70'

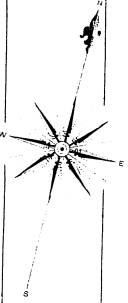


0 2


TOMPKINS

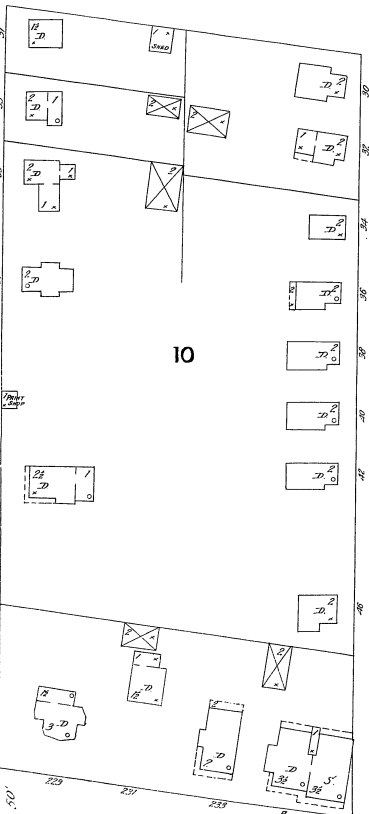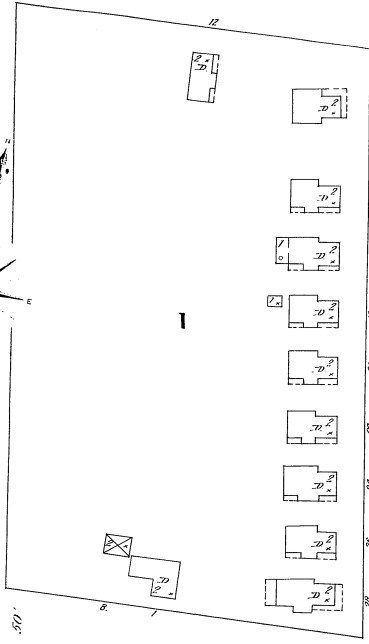


BROOME

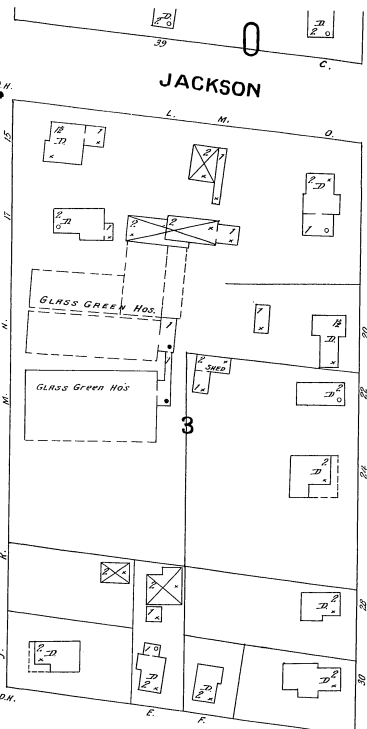


BELDEN

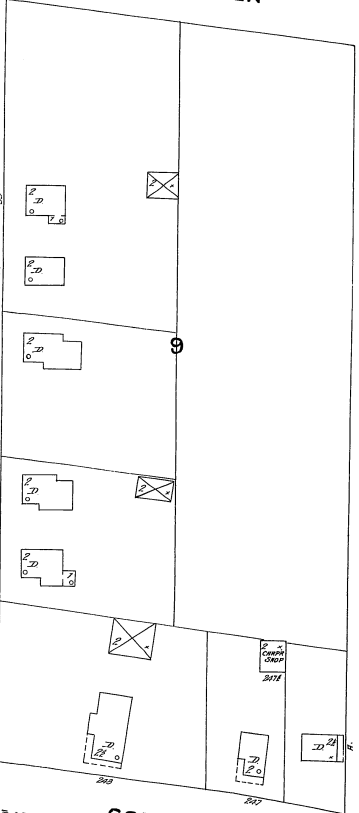


BALDWIN

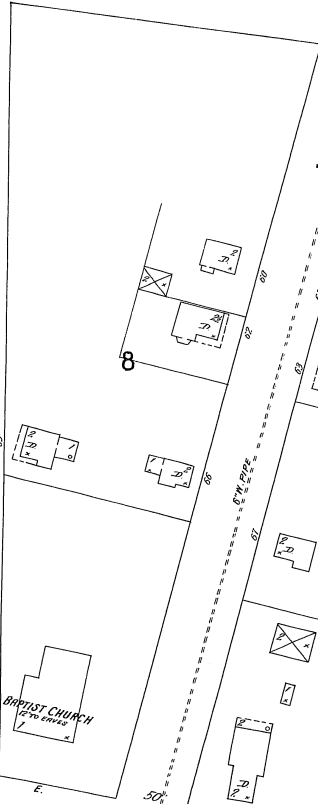


CONKLIN AV.

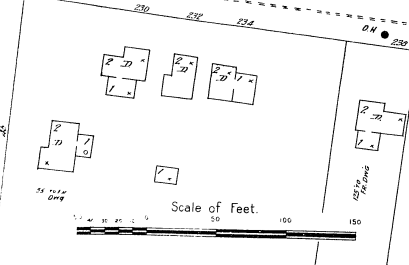

Scale of Feet.

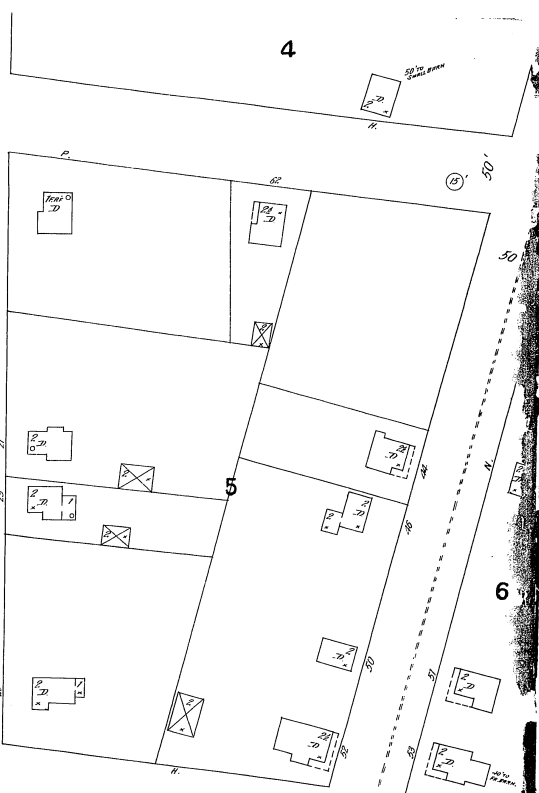

HAYES

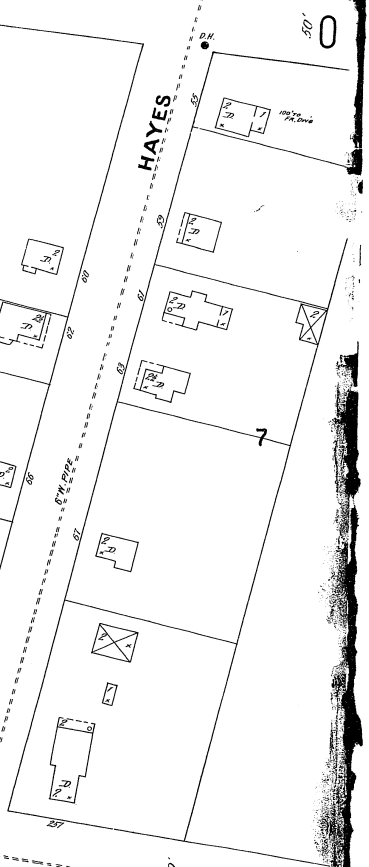

HOMES ST.

66

70'